




**MEDECINS DU MONDE
MDM**

DESIGN DRAWINGS

**REHABILITATION OF HEALTH FACILITIES PROJECTS IN
AFGHANISTAN**

**Rehabilitation/Improvement of Health Facilities Infrastructure for Health Sub
Center Project at Jilargi Village, Dalaram District, Nimruz Province**

PLAN AND SECTION

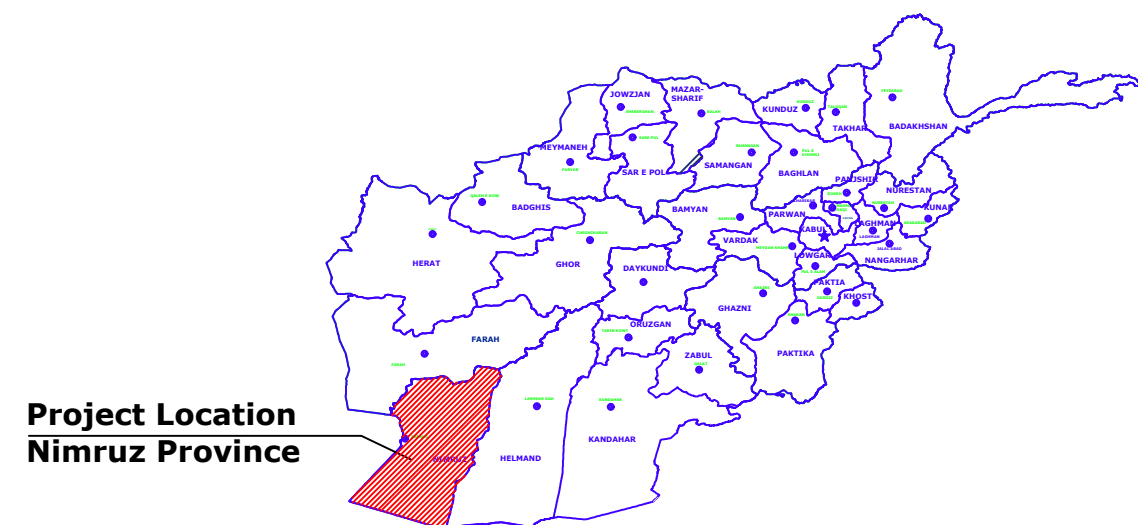

SUBMISSION DATE : - APR- 2026

Jilargi (HSC)-Dalaram District-Nimruz Province-GIS Plan



Legends

- Existing Boundary Wall
- Existing Rooms
- Existing Conex
- Existing Water Well
- Main Gate
- Existing M-Toilet
- Existing F-Toilet
- Existing Waste Area

Jilargi SHC


Coordinate Details						
No	Location			N	E	Remark
1	Province	District	Village	3530000	533303	HSC
	Nimruz	Dalaram	Jilargi			



Rehabilitation of HSC Building in Jilargi, Dalaram District, Nimruz, Afghanistan


Index Sheet

SHEET REF. #	SHEET TITLE	DATE
	GENERAL	
	COVER SHEET	APR-26
C-01	PROJECT VICINITY AERIAL MAP & LOCATION MAP	APR-26
C-02	INDEX SHEET	APR-26
C-03	EXISTING SITE PLAN	APR-26
C-04	DETAIL UPGRADE PLAN	APR-26
C-05	SIDE WALK PLAN	APR-26
C-06	WATER SUPPLY PLAN	APR-26
C-07	SEWER PLAN	APR-26
C-08	POWER PLAN	APR-26
C-09	DOORS AND WINDOWS PLAN	APR-26
C-10	DOORS AND WINDOWS DETAILS	APR-26
C-11	SEPTIC TANK AND TOILETS DETAILS	APR-26
C-12	WASTE AREA DETAILS	APR-26
C-13	SOLAR PANEL DETAILS	APR-26

 

INDEX SHEET

 	MEDECINS DU MONDE MDM	SURVEYED BY	MDM ENGINEER	CHECKED BY	MDM TEAM	SCALE		SHEET NO. 	PROVINCE	NIMROZ	PROJECT NAME: MAJOR REHABILITATION OF HEALTH CENTER
		DESIGNED BY	MDM ENGINEER	REVIEWED BY	MDM TEAM	DATE	26-04-2026		DISTRICT	DALARAM	
		DRAWN BY	MDM ENGINEER	APPROVED BY	MDM TEAM	DRAWING NO.			VILLAGE	JILARGI	

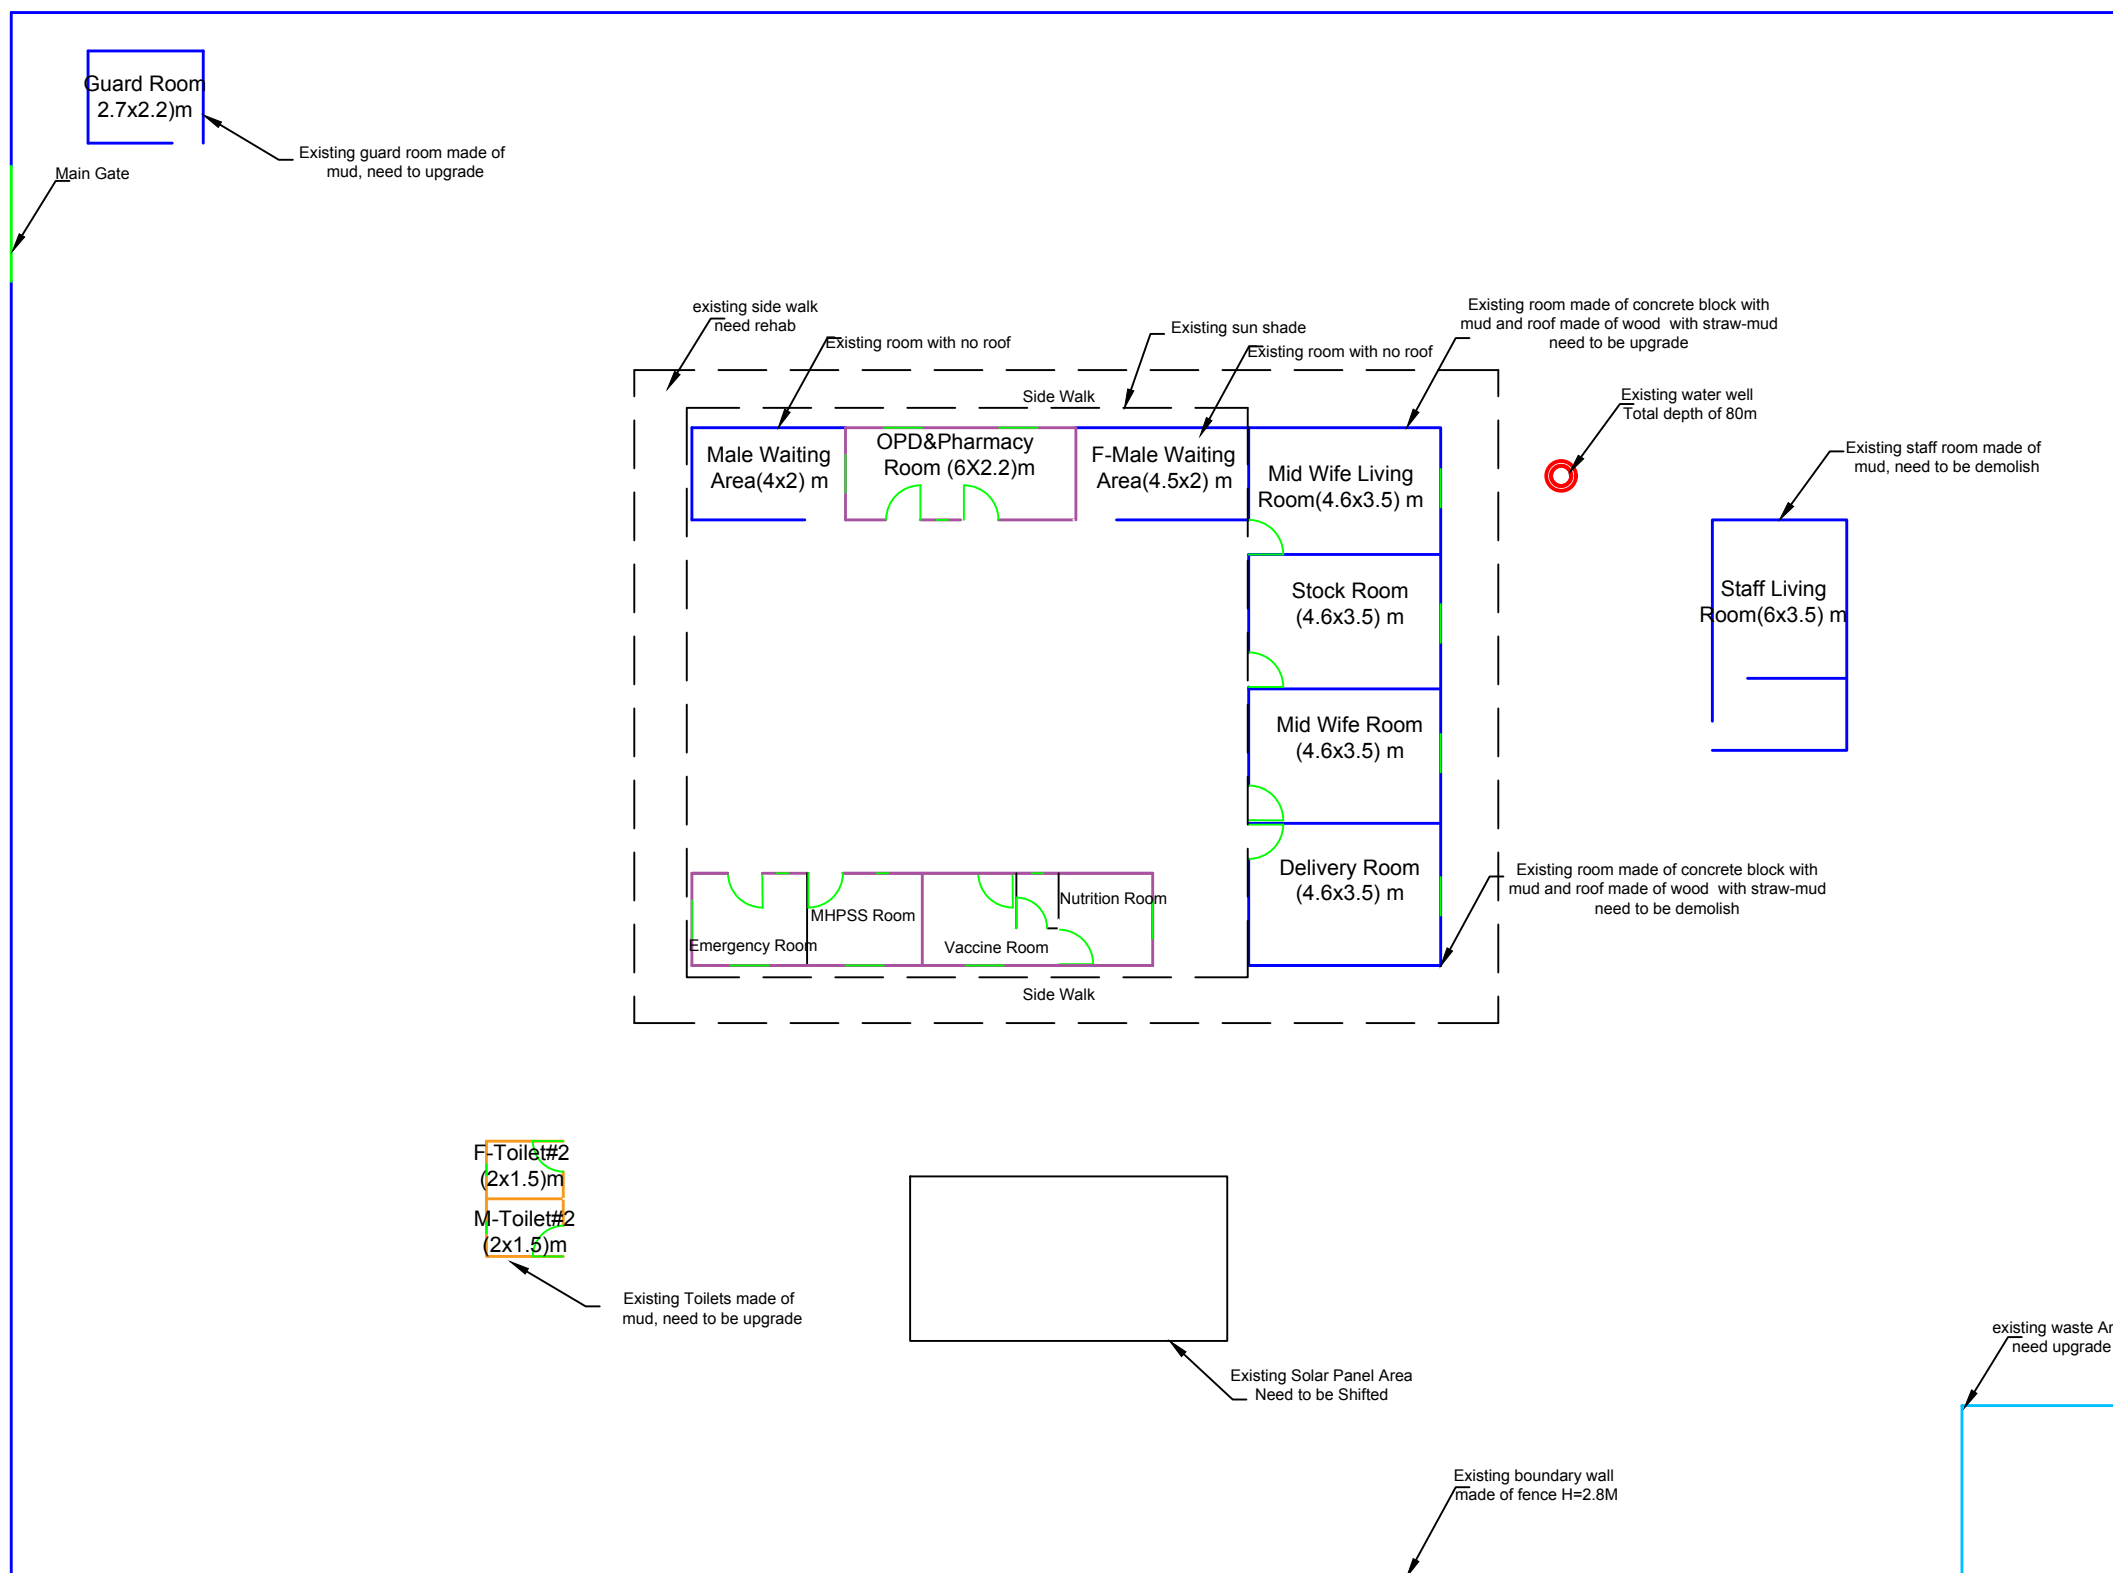


Legends

- Existing Boundary Wall
- Existing Rooms
- Existing Conex
- ⊙ Existing Water Well
- Main Gate
- Existing M-Toilet
- Existing F-Toilet
- Existing Waste Area

1 EXISTING SITE PLAN

	SURVEYED BY	MDM ENGINEER	CHECKED BY	MDM TEAM	SCALE		SHEET NO. 3/13	PROVINCE	NIMROZ	PROJECT NAME: MAJOR REHABILITATION OF HEALTH CENTER
	DESIGNED BY	MDM ENGINEER	REVIEWED BY	MDM TEAM	DATE	26-04-2026		DISTRICT	DALARAM	
	DRAWN BY	MDM ENGINEER	APPROVED BY	MDM TEAM	DRAWING NO.			VILLAGE	JILARGI	DRAWING TITLE: C-03

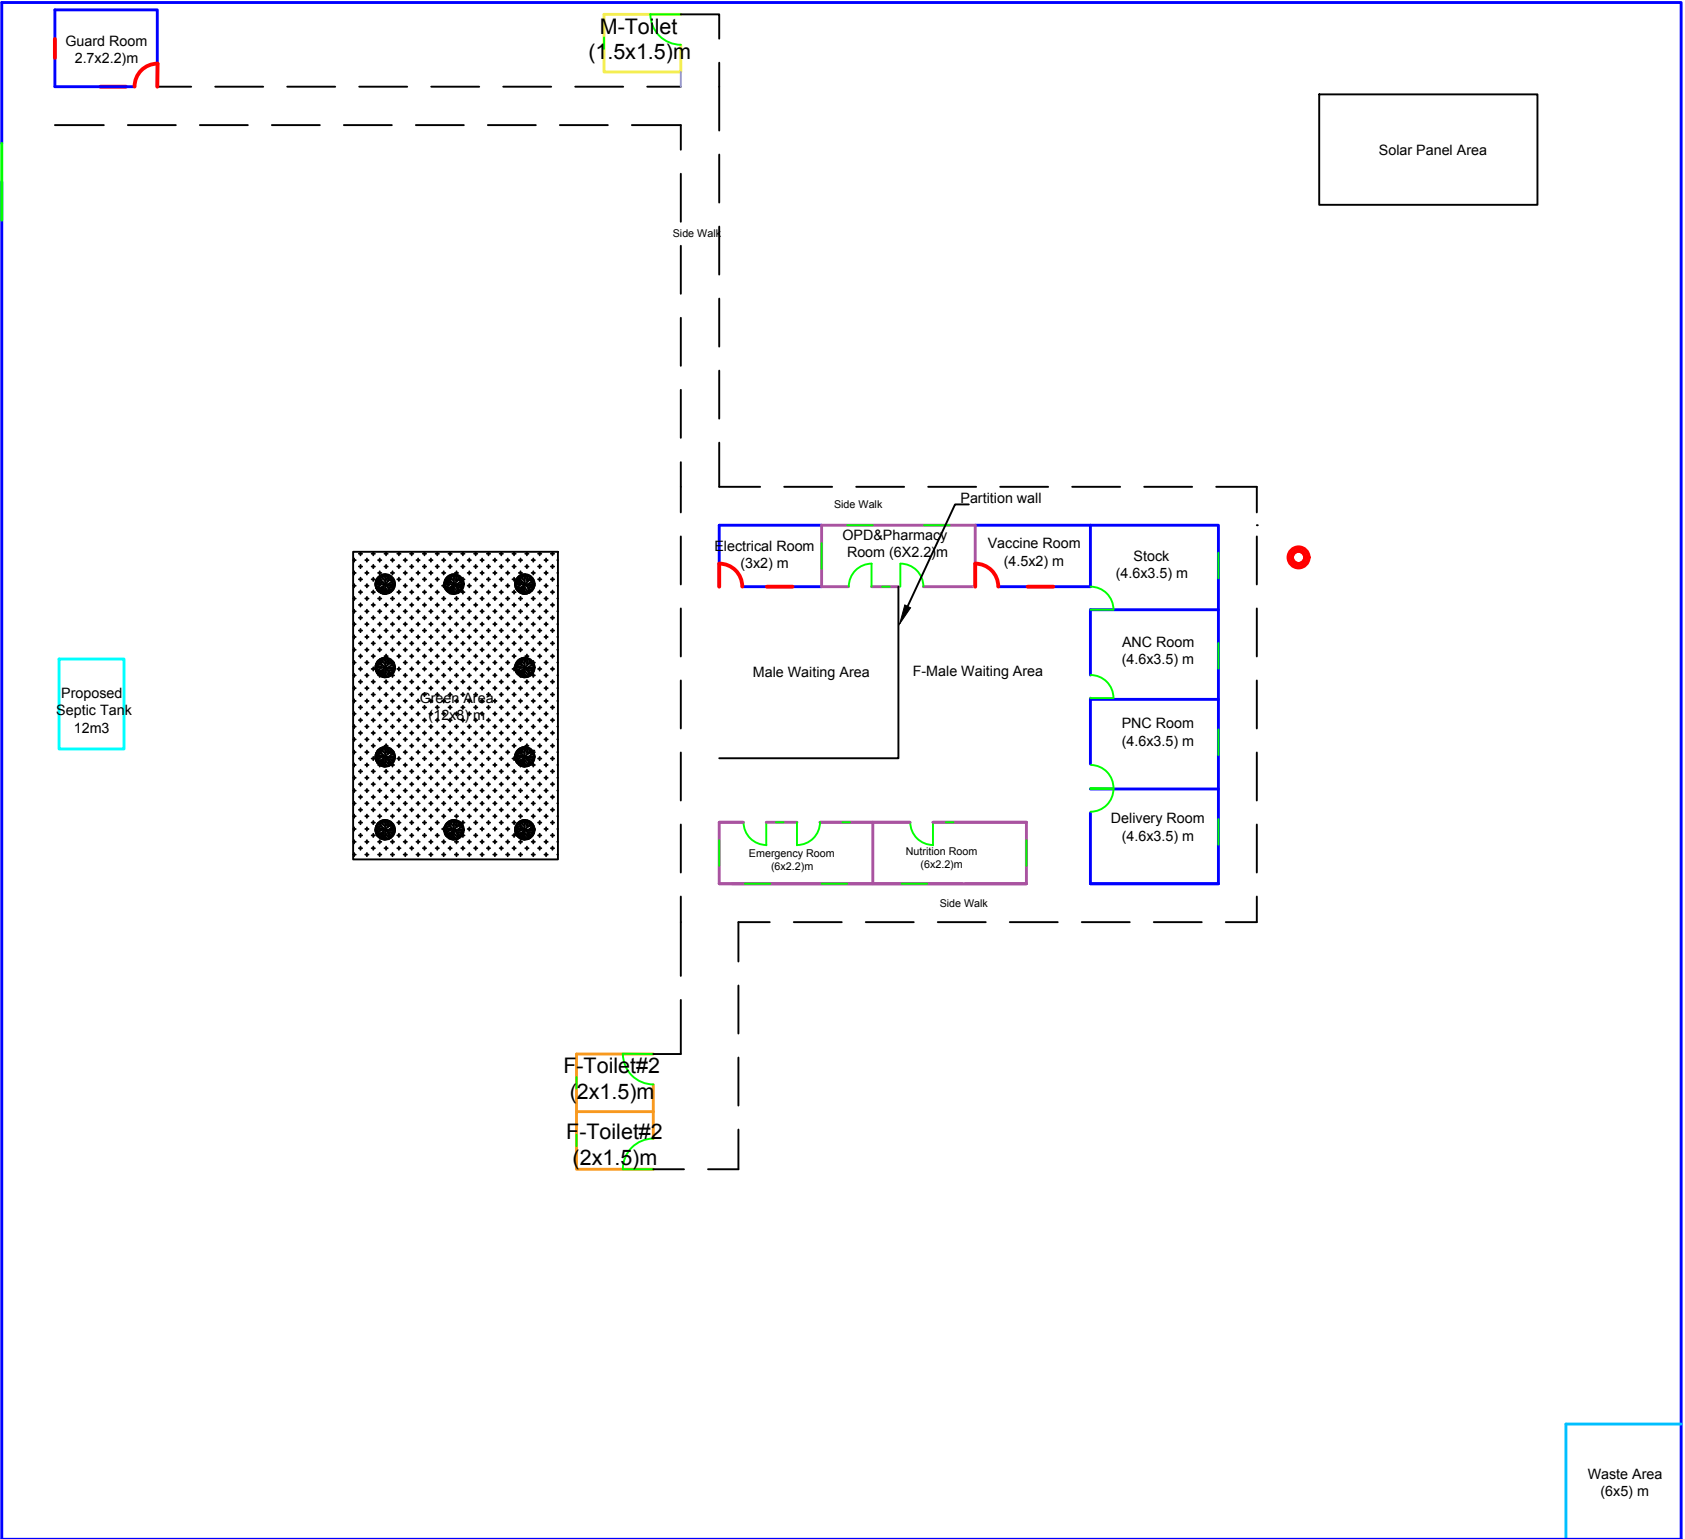


Legends

- Existing Boundary Wall
- New Construction
- Existing Conex
- Existing Water Well
- Main Gate
- Existing F-Toilet
- Proposed M-Toilet
- Existing Waste Area
- Proposed Septic Tank




DETAIL UPGRADE SITE PLAN

 MEDECINS DU MONDE MDM	SURVEYED BY	MDM ENGINEER	CHECKED BY	MDM TEAM	SCALE		SHEET NO. 4/13	PROVINCE	NIMROZ	PROJECT NAME: MAJOR REHABILITATION OF HEALTH CENTER	
	DESIGNED BY	MDM ENGINEER	REVIEWED BY	MDM TEAM	DATE	26-04-2026		DISTRICT	DALARAM	DRAWING TITLE: C-04	
	DRAWN BY	MDM ENGINEER	APPROVED BY	MDM TEAM	DRAWING NO.			VILLAGE	JILRAGI		

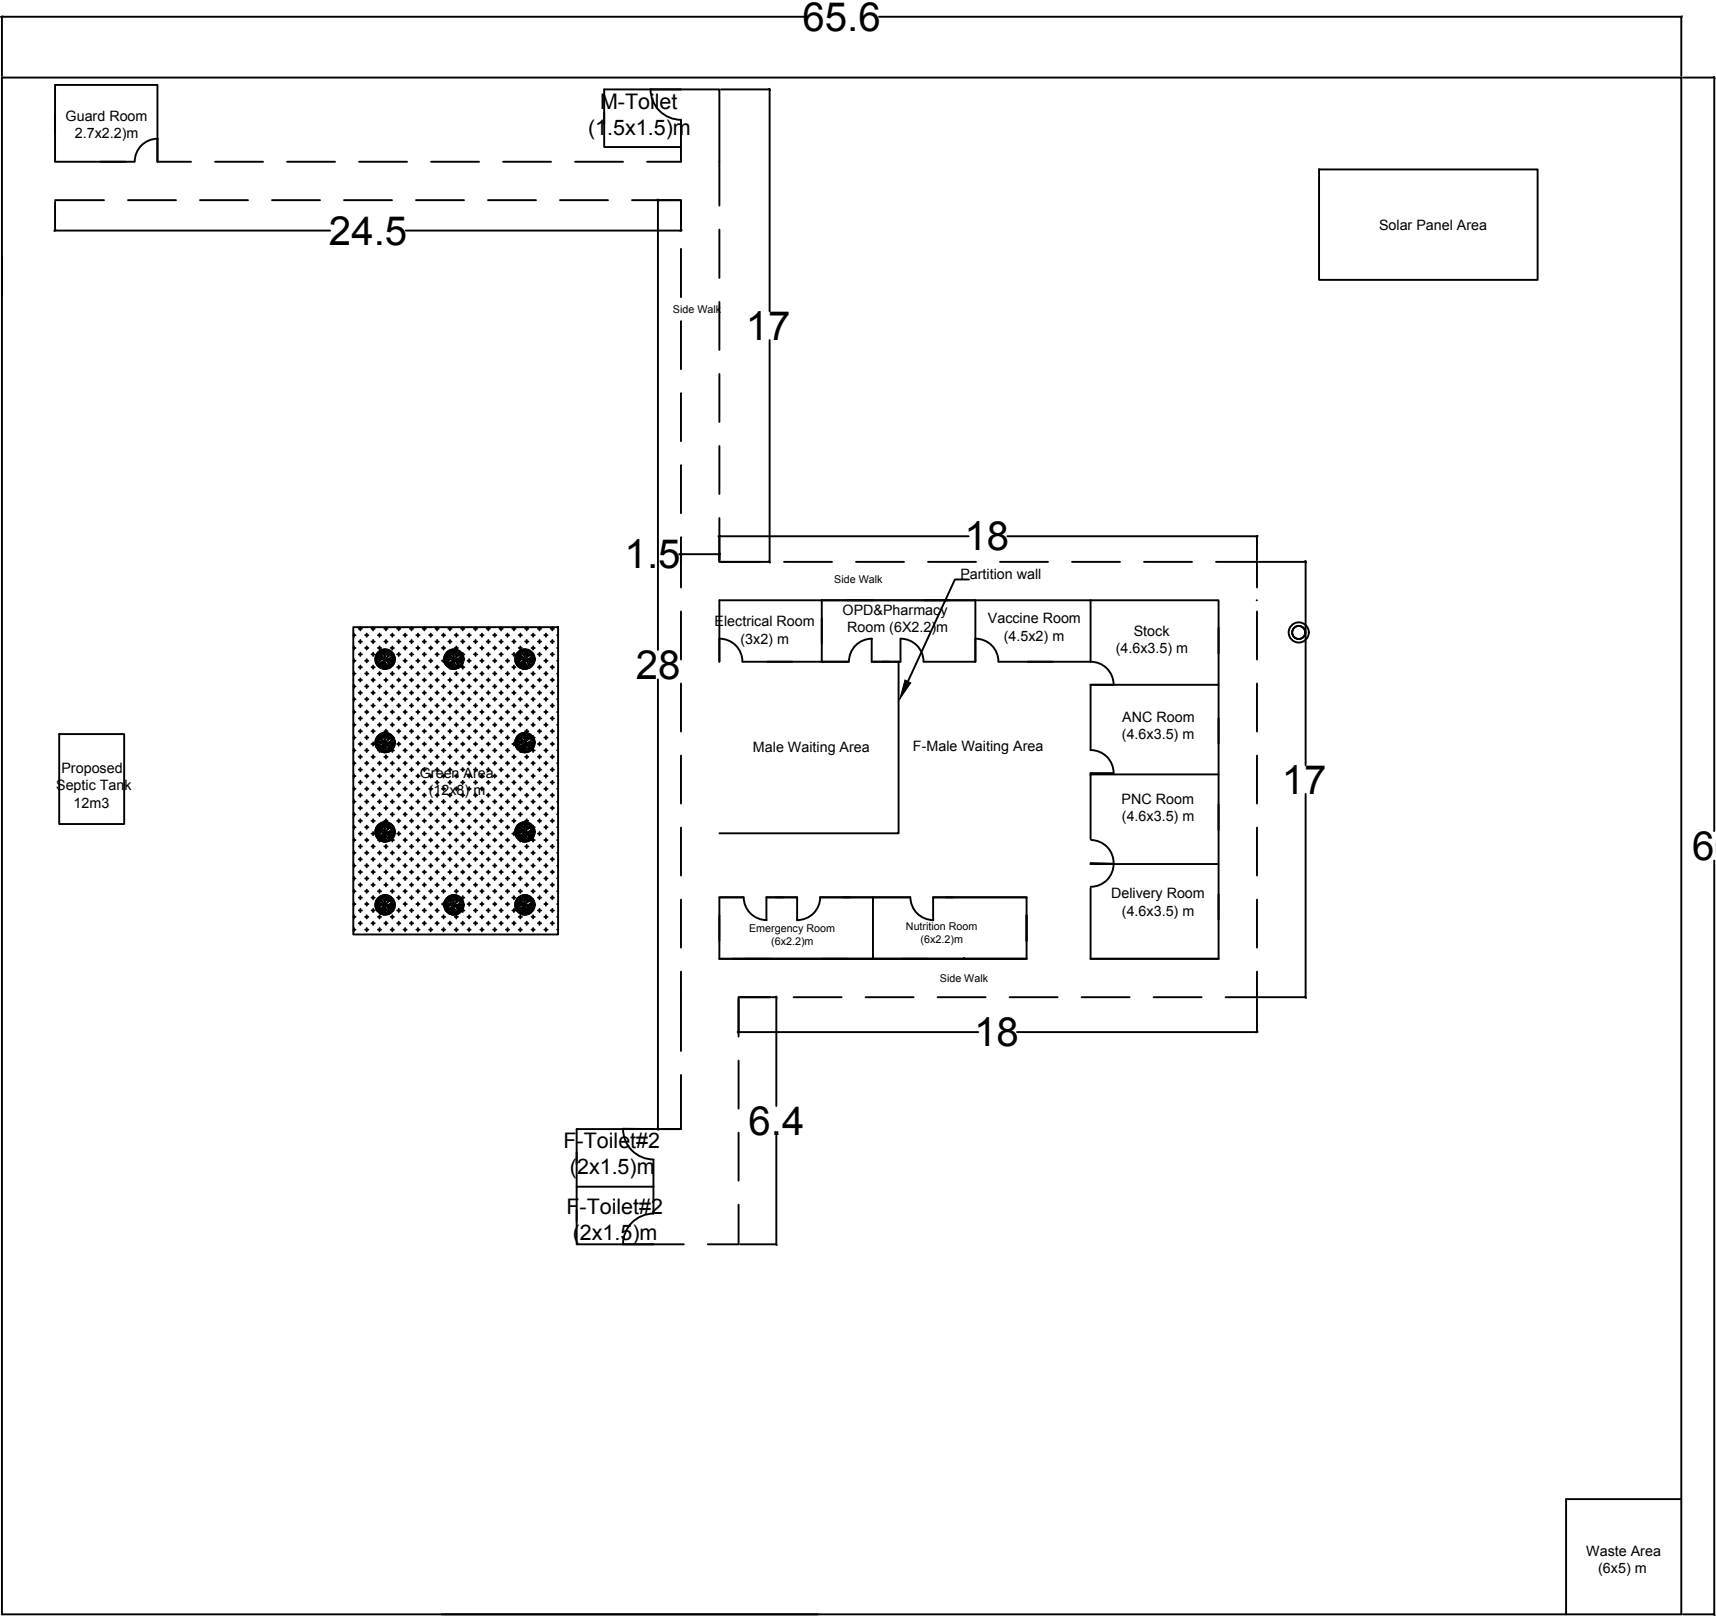



1 SIDE WALK PLAN
C-05

 MEDECINS DU MONDE MDM	SURVEYED BY	MDM ENGINEER	CHECKED BY	MDM TEAM	SCALE		SHEET NO. 5/13	PROVINCE	NIMROZ	PROJECT NAME: MAJOR REHABILITATION OF HEALTH CENTER
	DESIGNED BY	MDM ENGINEER	REVIEWED BY	MDM TEAM	DATE	26-04-2026		DISTRICT	DALARAM	
	DRAWN BY	MDM ENGINEER	APPROVED BY	MDM TEAM	DRAWING NO.			VILLAGE	JILRAGI	DRAWING TITLE: C-05

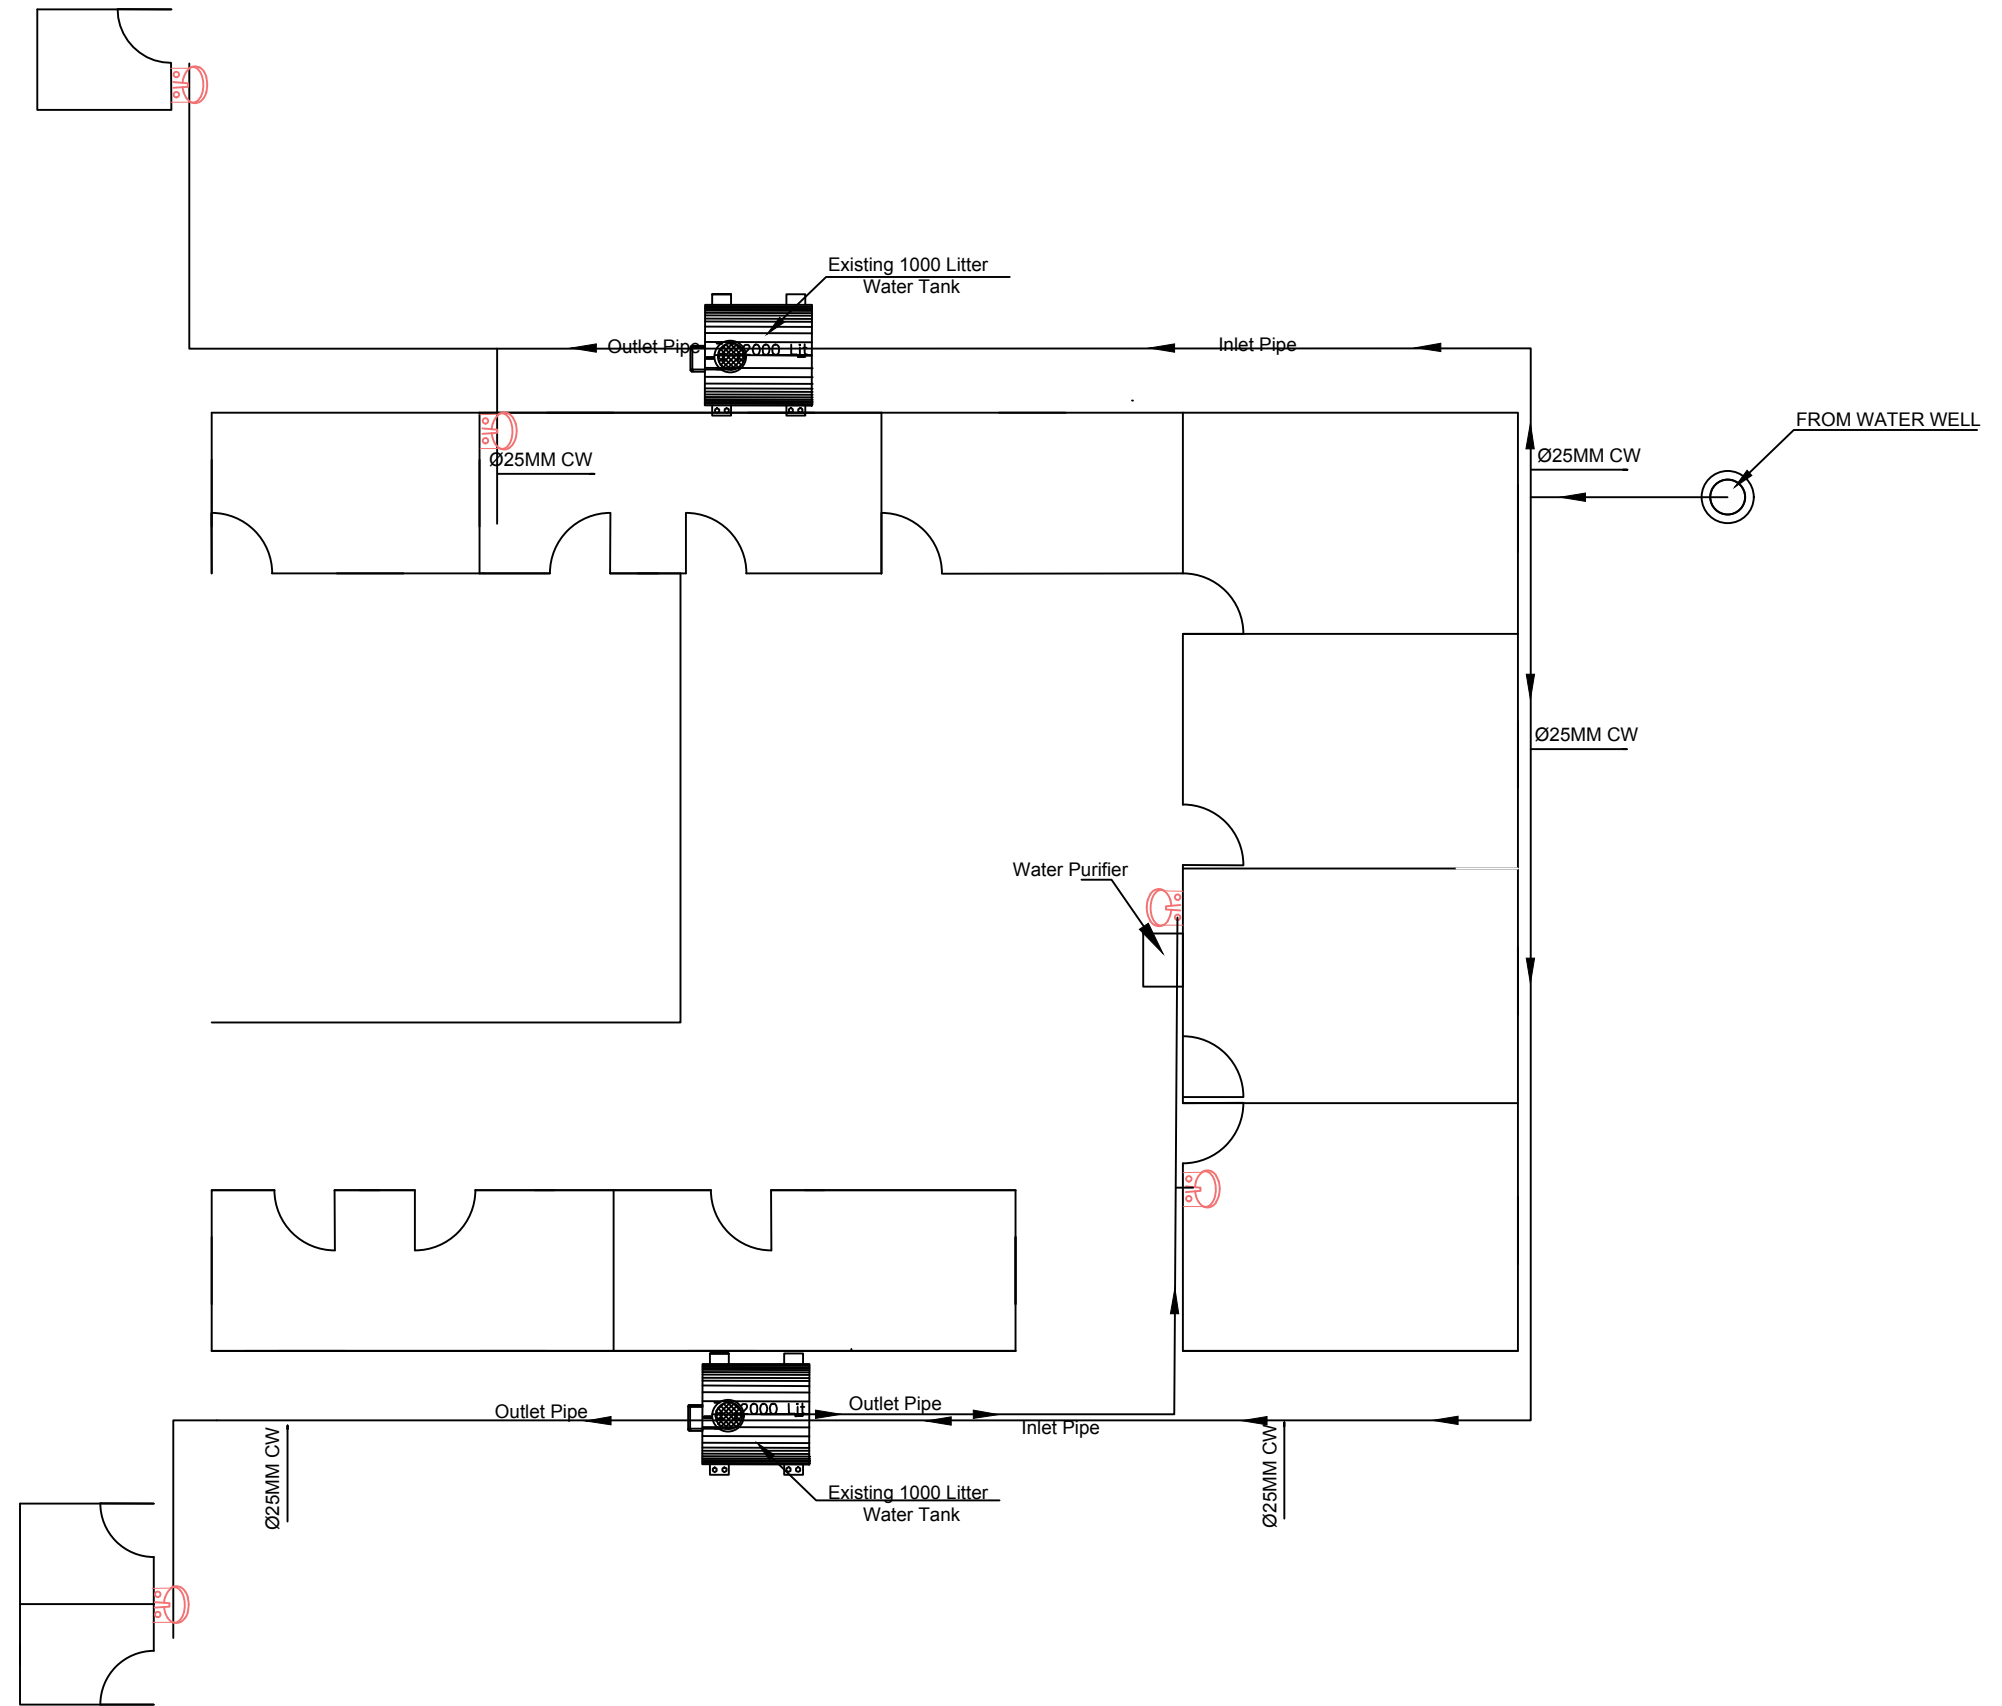


1 WATER SUPPLY PLAN
C-06

  MEDECINS DU MONDE MDM	SURVEYED BY	MDM ENGINEER	CHECKED BY	MDM TEAM	SCALE		SHEET NO. 	PROVINCE	NIMROZ	PROJECT NAME: MAJOR REHABILITATION OF HEALTH CENTER	
	DESIGNED BY	MDM ENGINEER	REVIEWED BY	MDM TEAM	DATE	26-04-2026		DISTRICT	DALARAM	DRAWING TITLE:	
	DRAWN BY	MDM ENGINEER	APPROVED BY	MDM TEAM	DRAWING NO.			VILLAGE	JILRAGI	C-06	

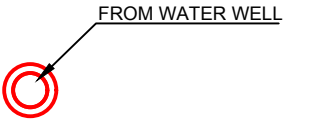

Water Purifier



Absorption Pit

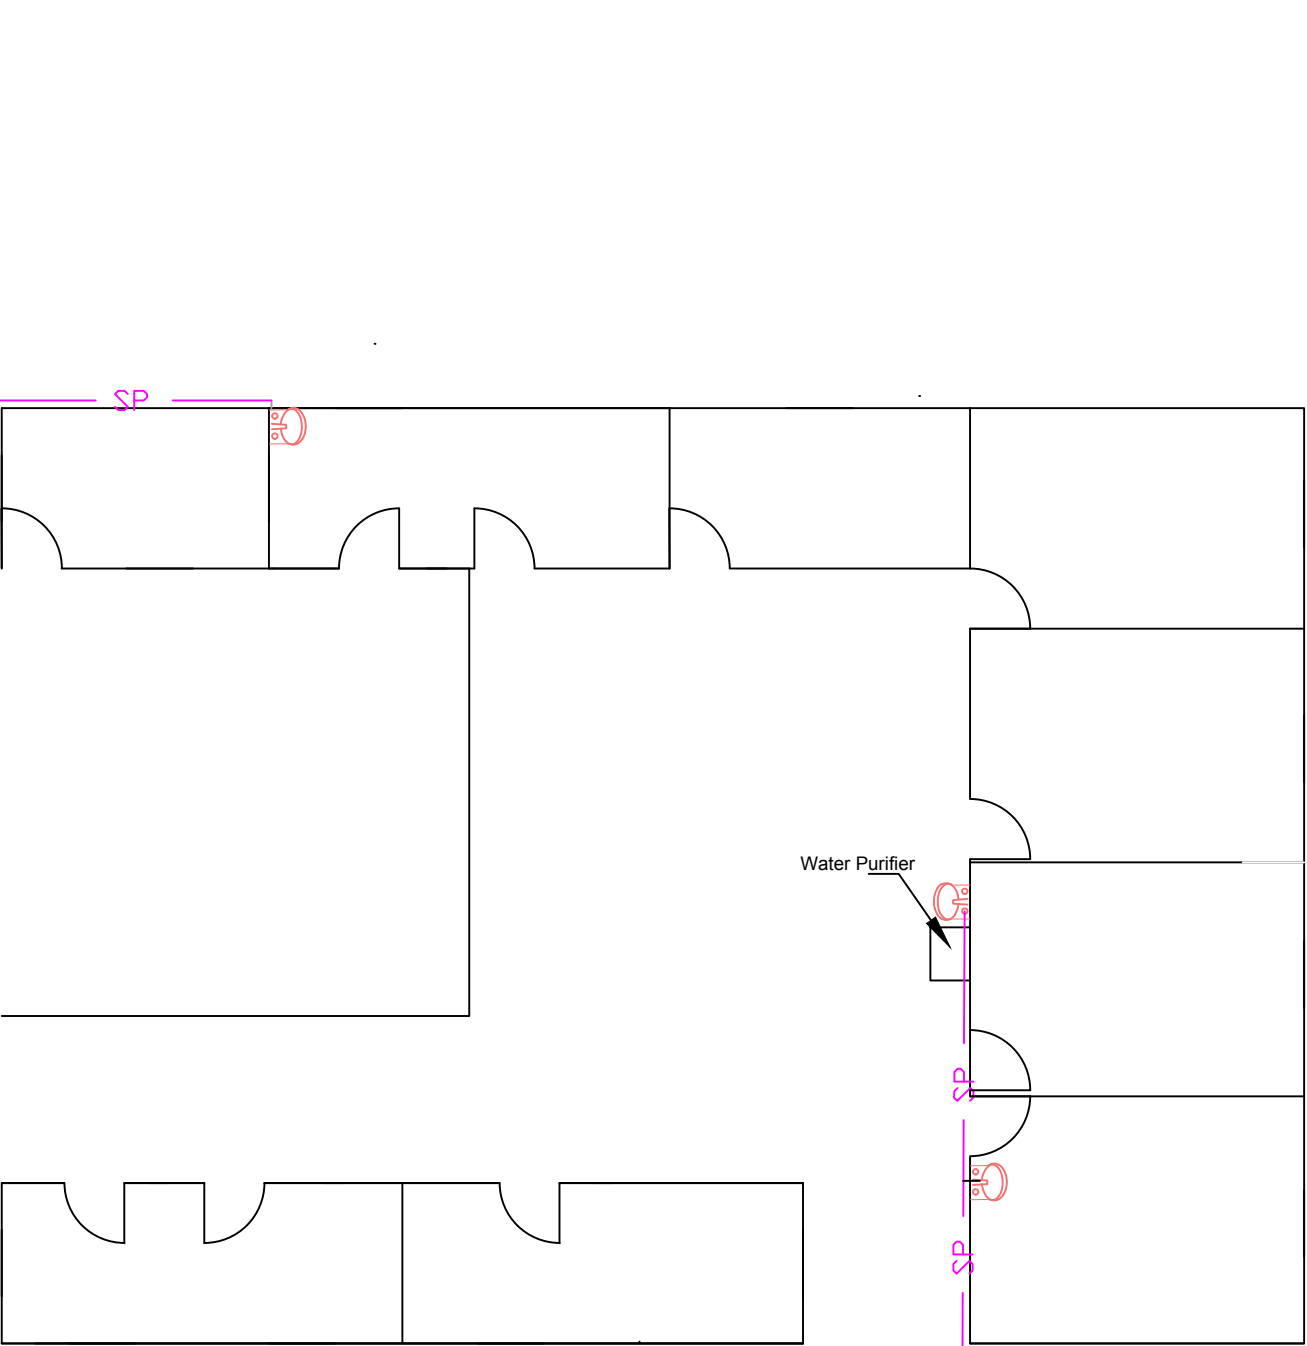

Ø4inch, SLOPE 0.5%

Ø4inch, SLOPE 0.5%

 Proposed
Septic Tank
12m3

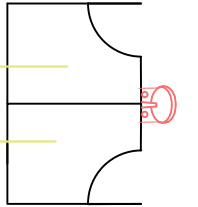

Sewer Table		
No	Items	Symbol
1	Commode	—
2	Sink Water	—

SEWER PLAN

1
C-07



MEDECINS DU MONDE
MDM

SURVEYED BY
DESIGNED BY
DRAWN BY

MDM ENGINEER
MDM ENGINEER
MDM ENGINEER

 
CHECKED BY
REVIEWED BY
APPROVED BY

MDM TEAM
MDM TEAM
MDM TEAM

SCALE
DATE
DRAWING NO.

26-04-2026


SHEET
NO.





PROVINCE
DISTRICT
VILLAGE


NIMROZ
DALARAM
JILRAGI

 PROJECT NAME:
MAJOR REHABILITATION OF HEALTH CENTER
DRAWING TITLE:
C-07

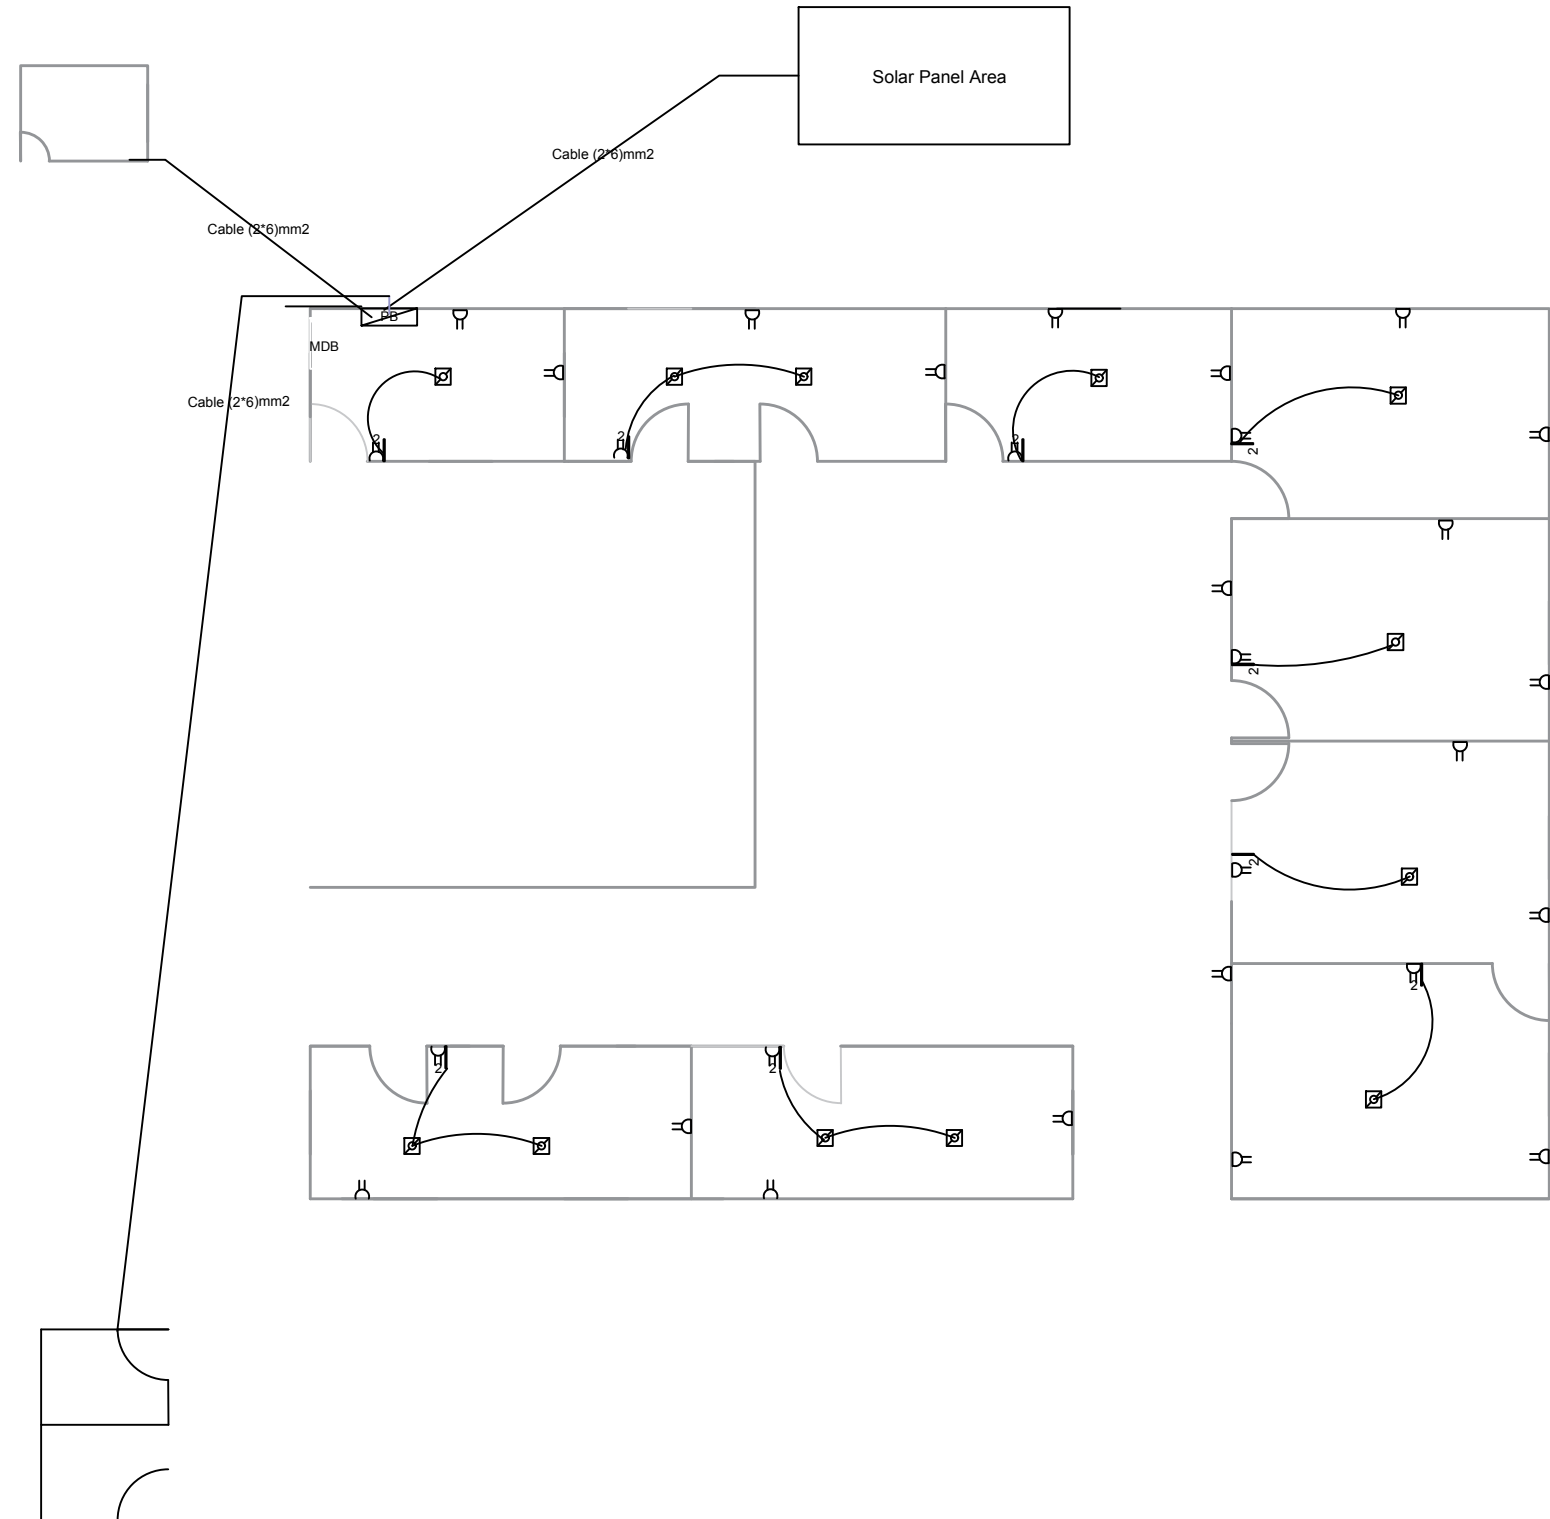

 POWER PLAN

  MEDECINS DU MONDE MDM	SURVEYED BY	MDM ENGINEER	CHECKED BY	MDM TEAM	SCALE		SHEET NO. 	PROVINCE	NIMROZ	PROJECT NAME: MAJOR REHABILITATION OF HEALTH CENTER	
	DESIGNED BY	MDM ENGINEER	REVIEWED BY	MDM TEAM	DATE	26-04-2026		DISTRICT	DALARAM	DRAWING TITLE: C-08	
	DRAWN BY	MDM ENGINEER	APPROVED BY	MDM TEAM	DRAWING NO.			VILLAGE	JILRAGI		

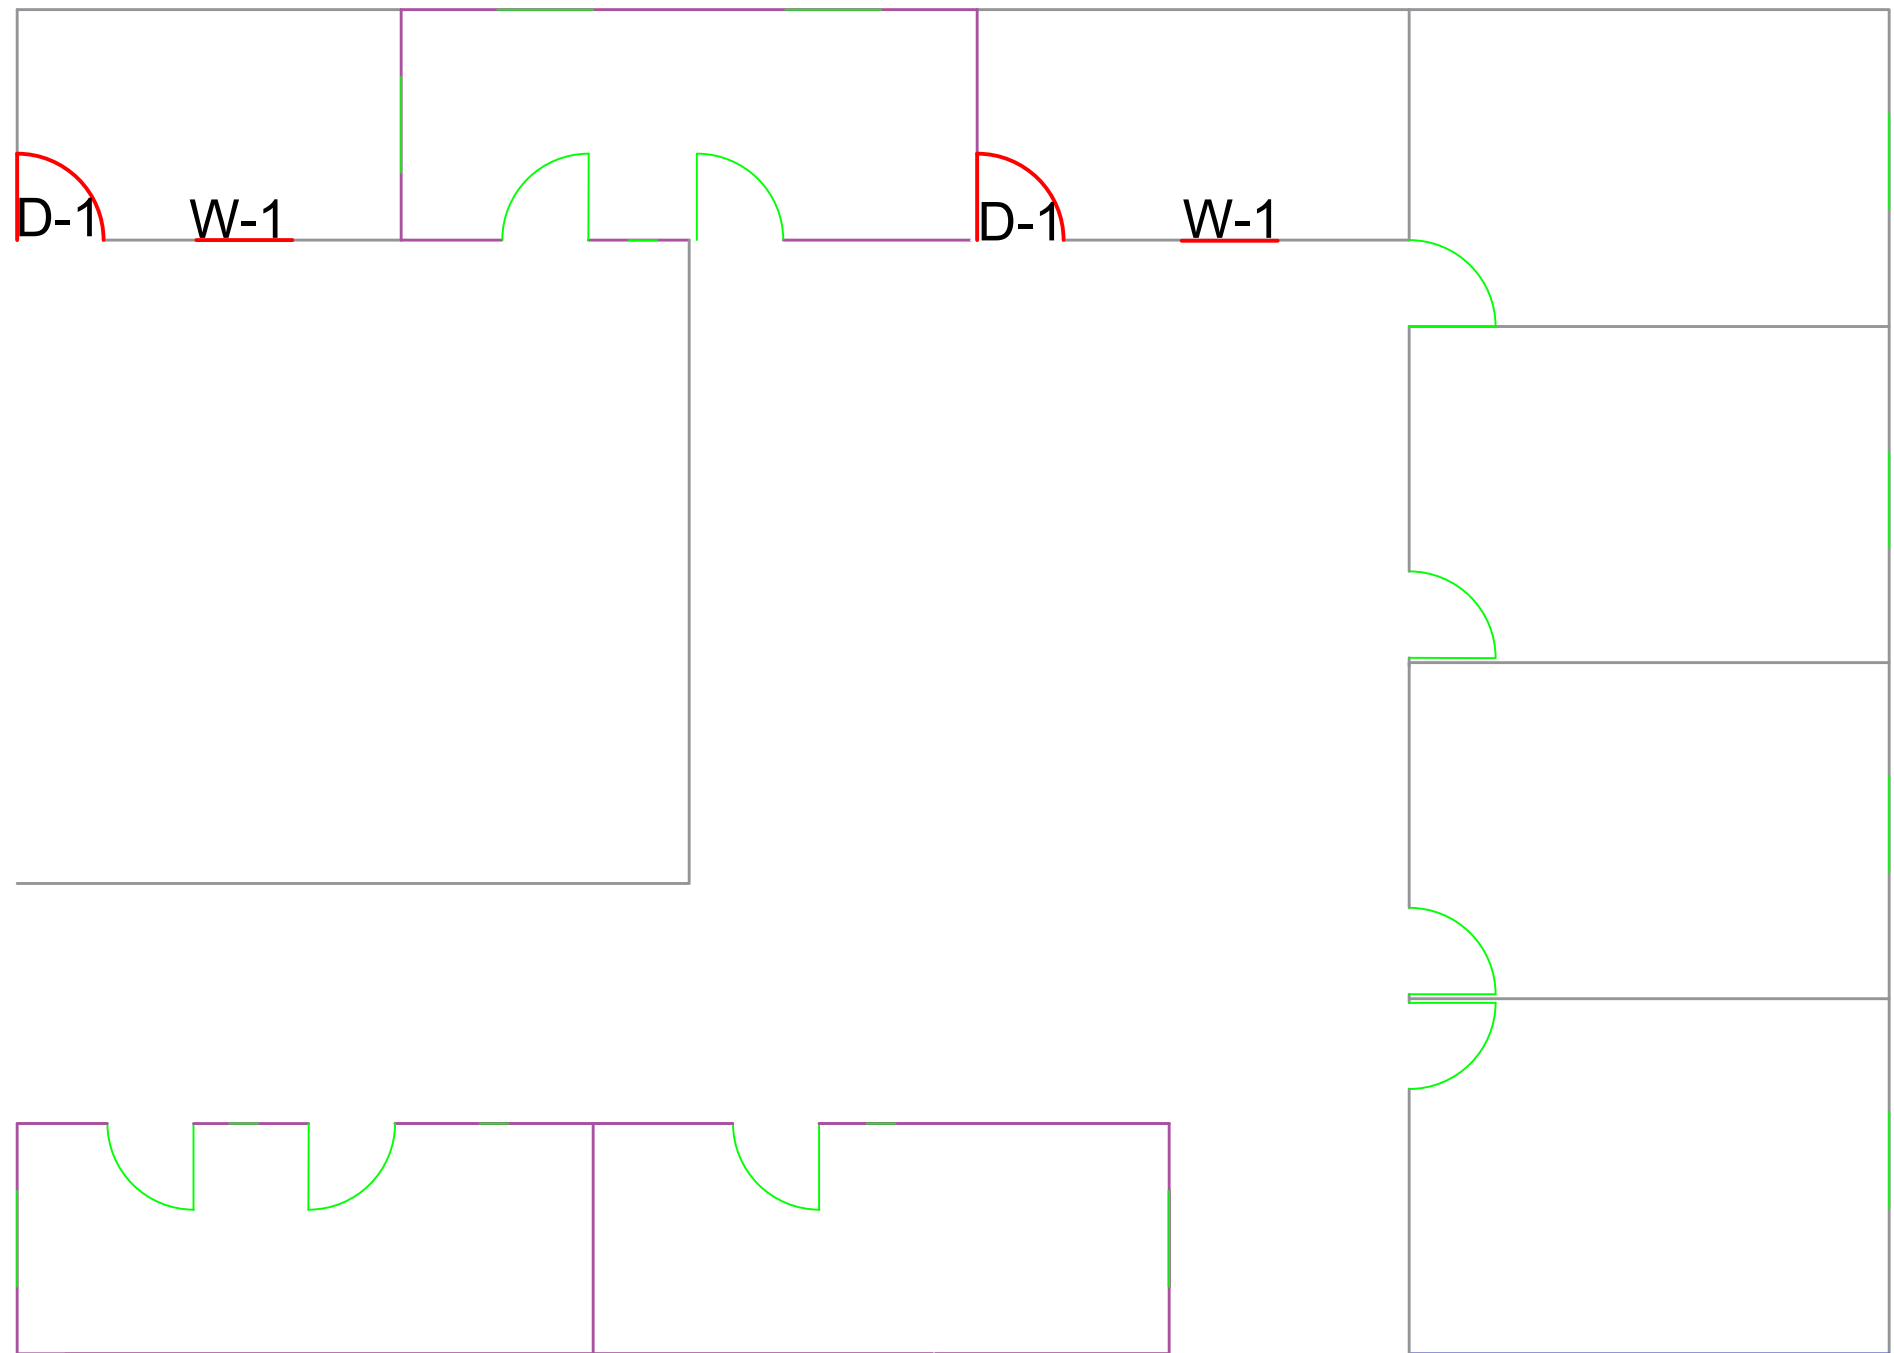



Door and Window Table		
No	Items	Symbol
1	Existing D&W	—
2	Proposed new D&W	—

1

C-9

DOORS &WINDOWS PLAN


 MEDECINS DU MONDE MDM	SURVEYED BY	MDM ENGINEER	CHECKED BY	MDM TEAM	SCALE		SHEET NO. 9/13	PROVINCE	NIMROZ	PROJECT NAME: MAJOR REHABILITATION OF HEALTH CENTER	
	DESIGNED BY	MDM ENGINEER	REVIEWED BY	MDM TEAM	DATE	26-04-2026		DISTRICT	DALARAM	DRAWING TITLE:	
	DRAWN BY	MDM ENGINEER	APPROVED BY	MDM TEAM	DRAWING NO.			VILLAGE	JILARGI	C-09	

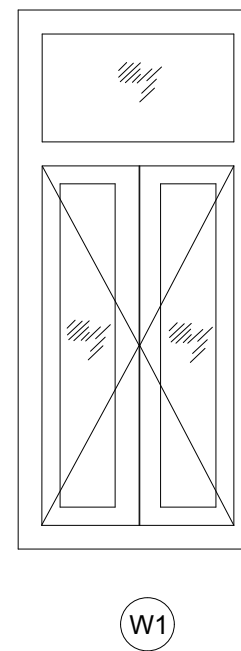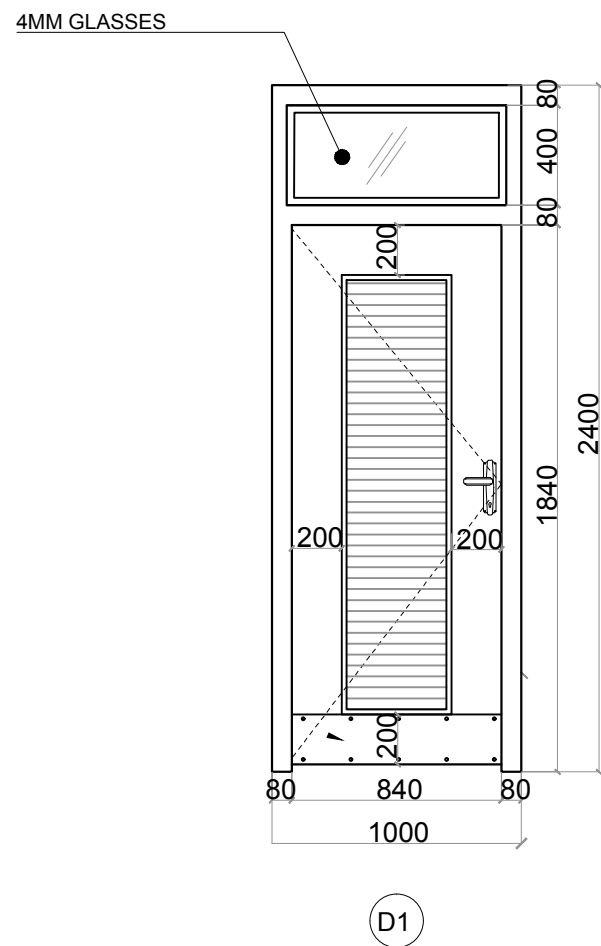


DOORS & WINDOWS SCHEDULE


TYPE	MATERIAL	NO.	HEIGHT (mm)	WIDTH (mm)	REMARKS
D1	METALLIC	2	2400	1000	4MM GLASSES
w1	METALLIC	2	1500	1000	4MM GLASSES

 DOORS & WINDOWS DETAILS



 MEDECINS DU MONDE MDM	SURVEYED BY	MDM ENGINEER	CHECKED BY	MDM TEAM	SCALE		SHEET NO. 	PROVINCE	NIMROZ	PROJECT NAME: MAJOR REHABILITATION OF HEALTH CENTER
	DESIGNED BY	MDM ENGINEER	REVIEWED BY	MDM TEAM	DATE	26-04-2026		DISTRICT	DALARAM	
	DRAWN BY	MDM ENGINEER	APPROVED BY	MDM TEAM	DRAWING NO.			VILLAGE	JILARGI	DRAWING TITLE: C-10

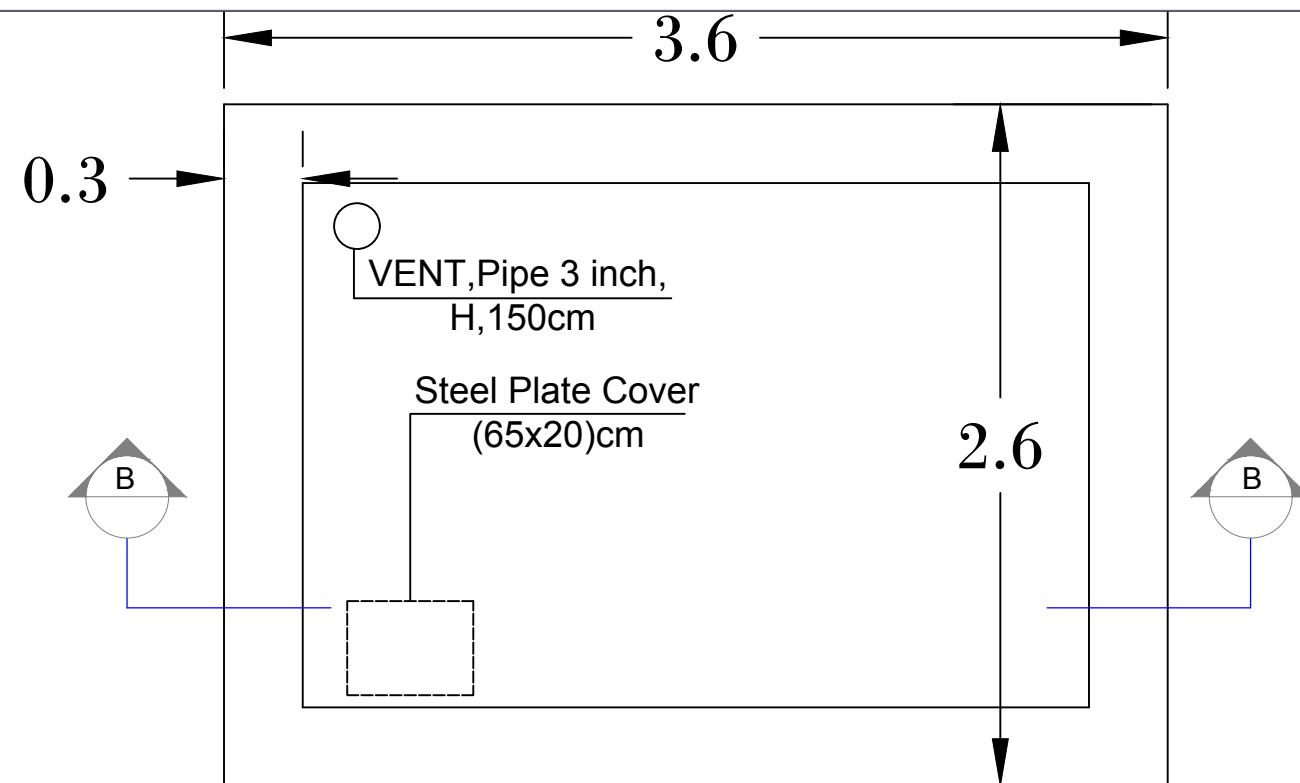



1 SEPTIC TANK PLAN

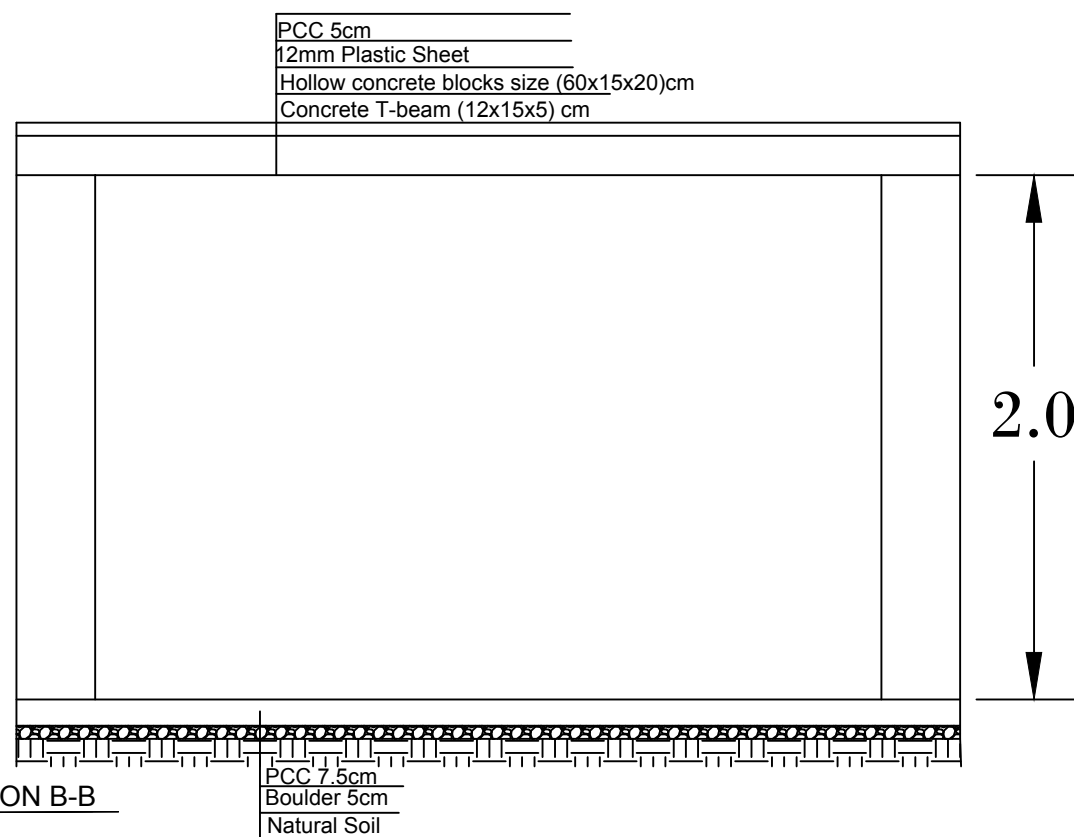


2 SECTION B-B

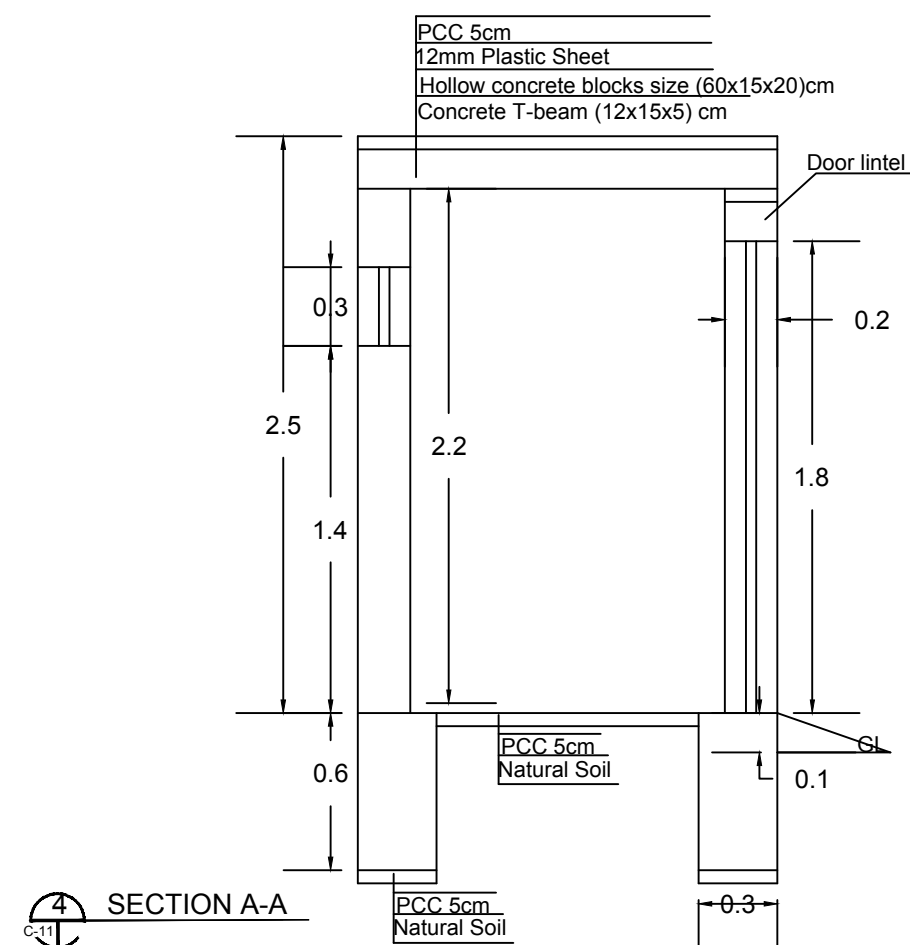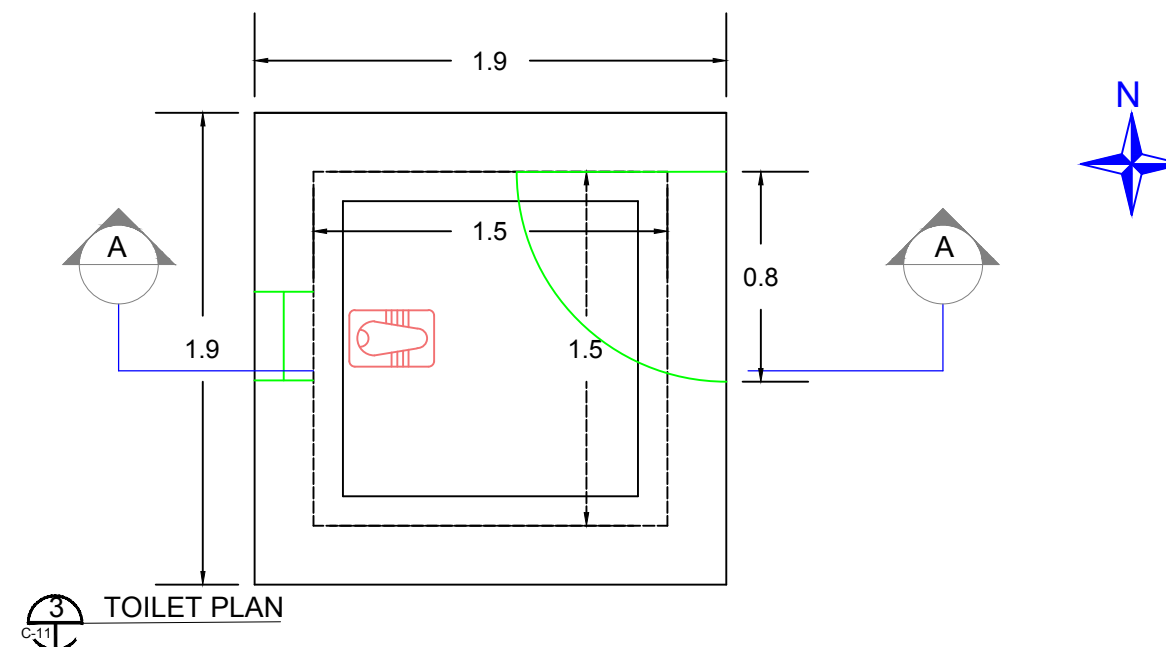


	SURVEYED BY	MDM ENGINEER	CHECKED BY	MDM TEAM	SCALE		SHEET NO. 11/13	PROVINCE	NIMROZ	PROJECT NAME: MAJOR REHABILITATION OF HEALTH CENTER
	DESIGNED BY	MDM ENGINEER	REVIEWED BY	MDM TEAM	DATE	26-04-2026		DISTRICT	DALARAM	
	DRAWN BY	MDM ENGINEER	APPROVED BY	MDM TEAM	DRAWING NO.			VILLAGE	JILARGI	DRAWING TITLE: C-11

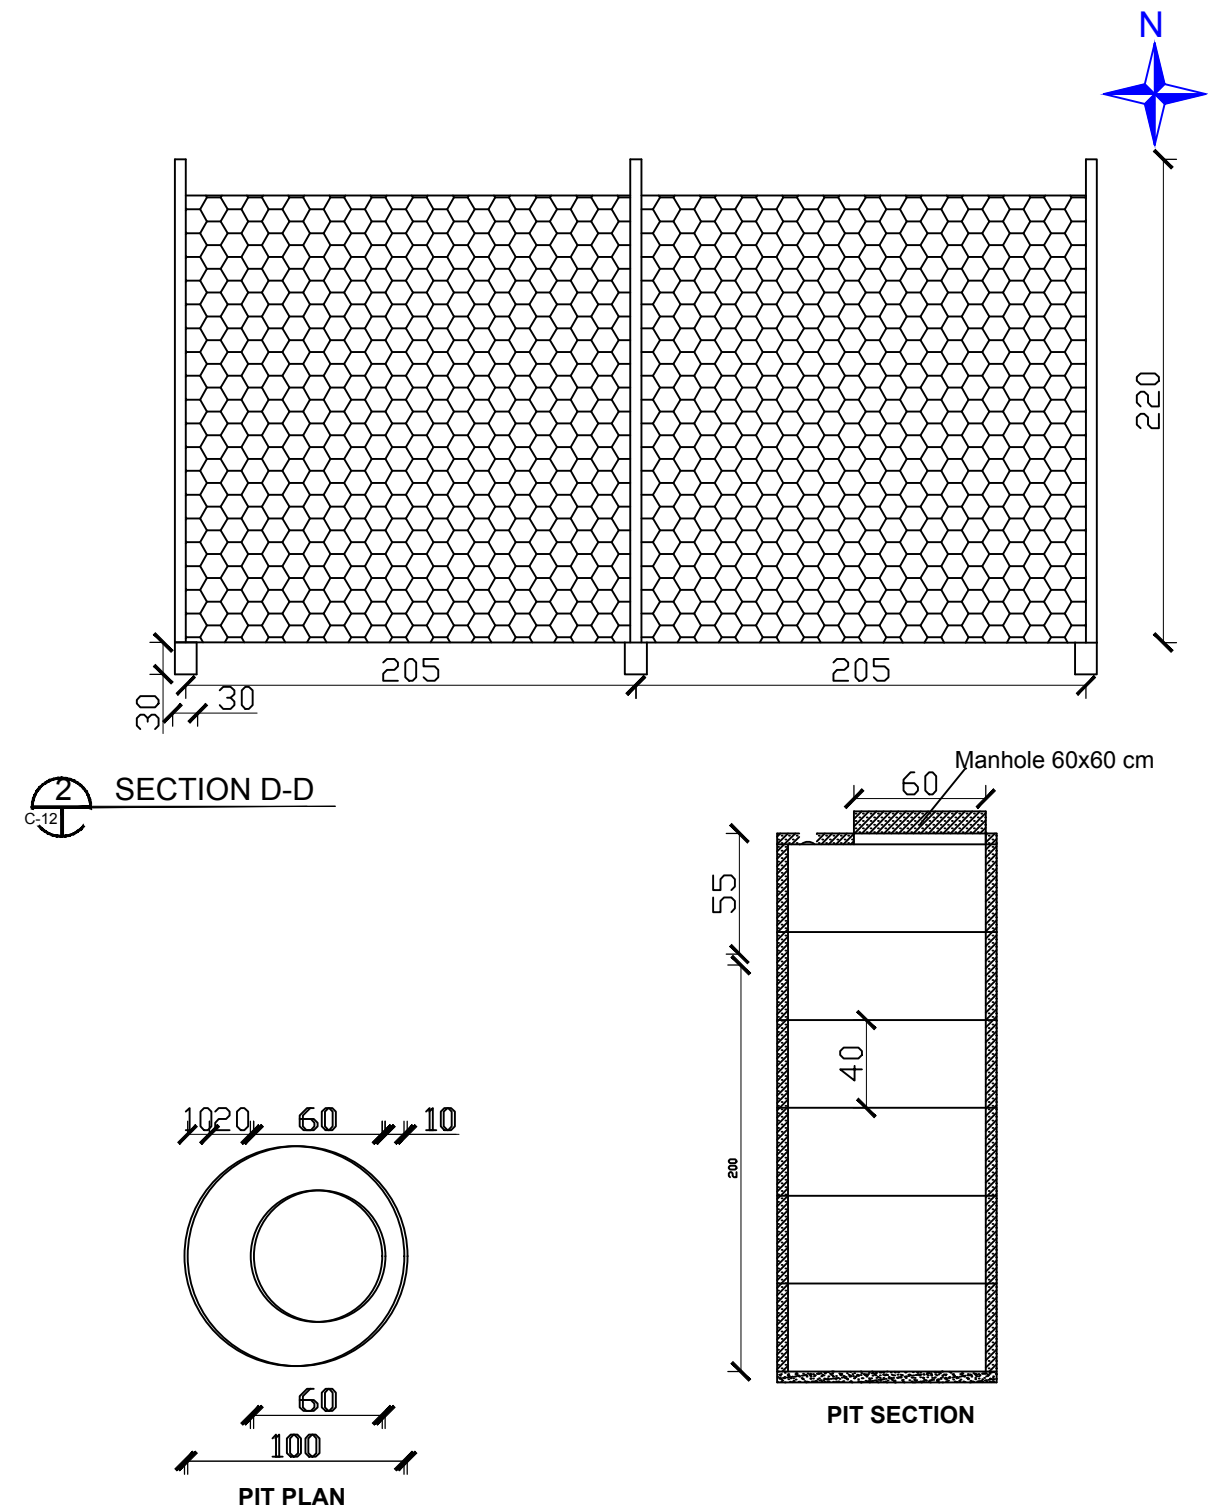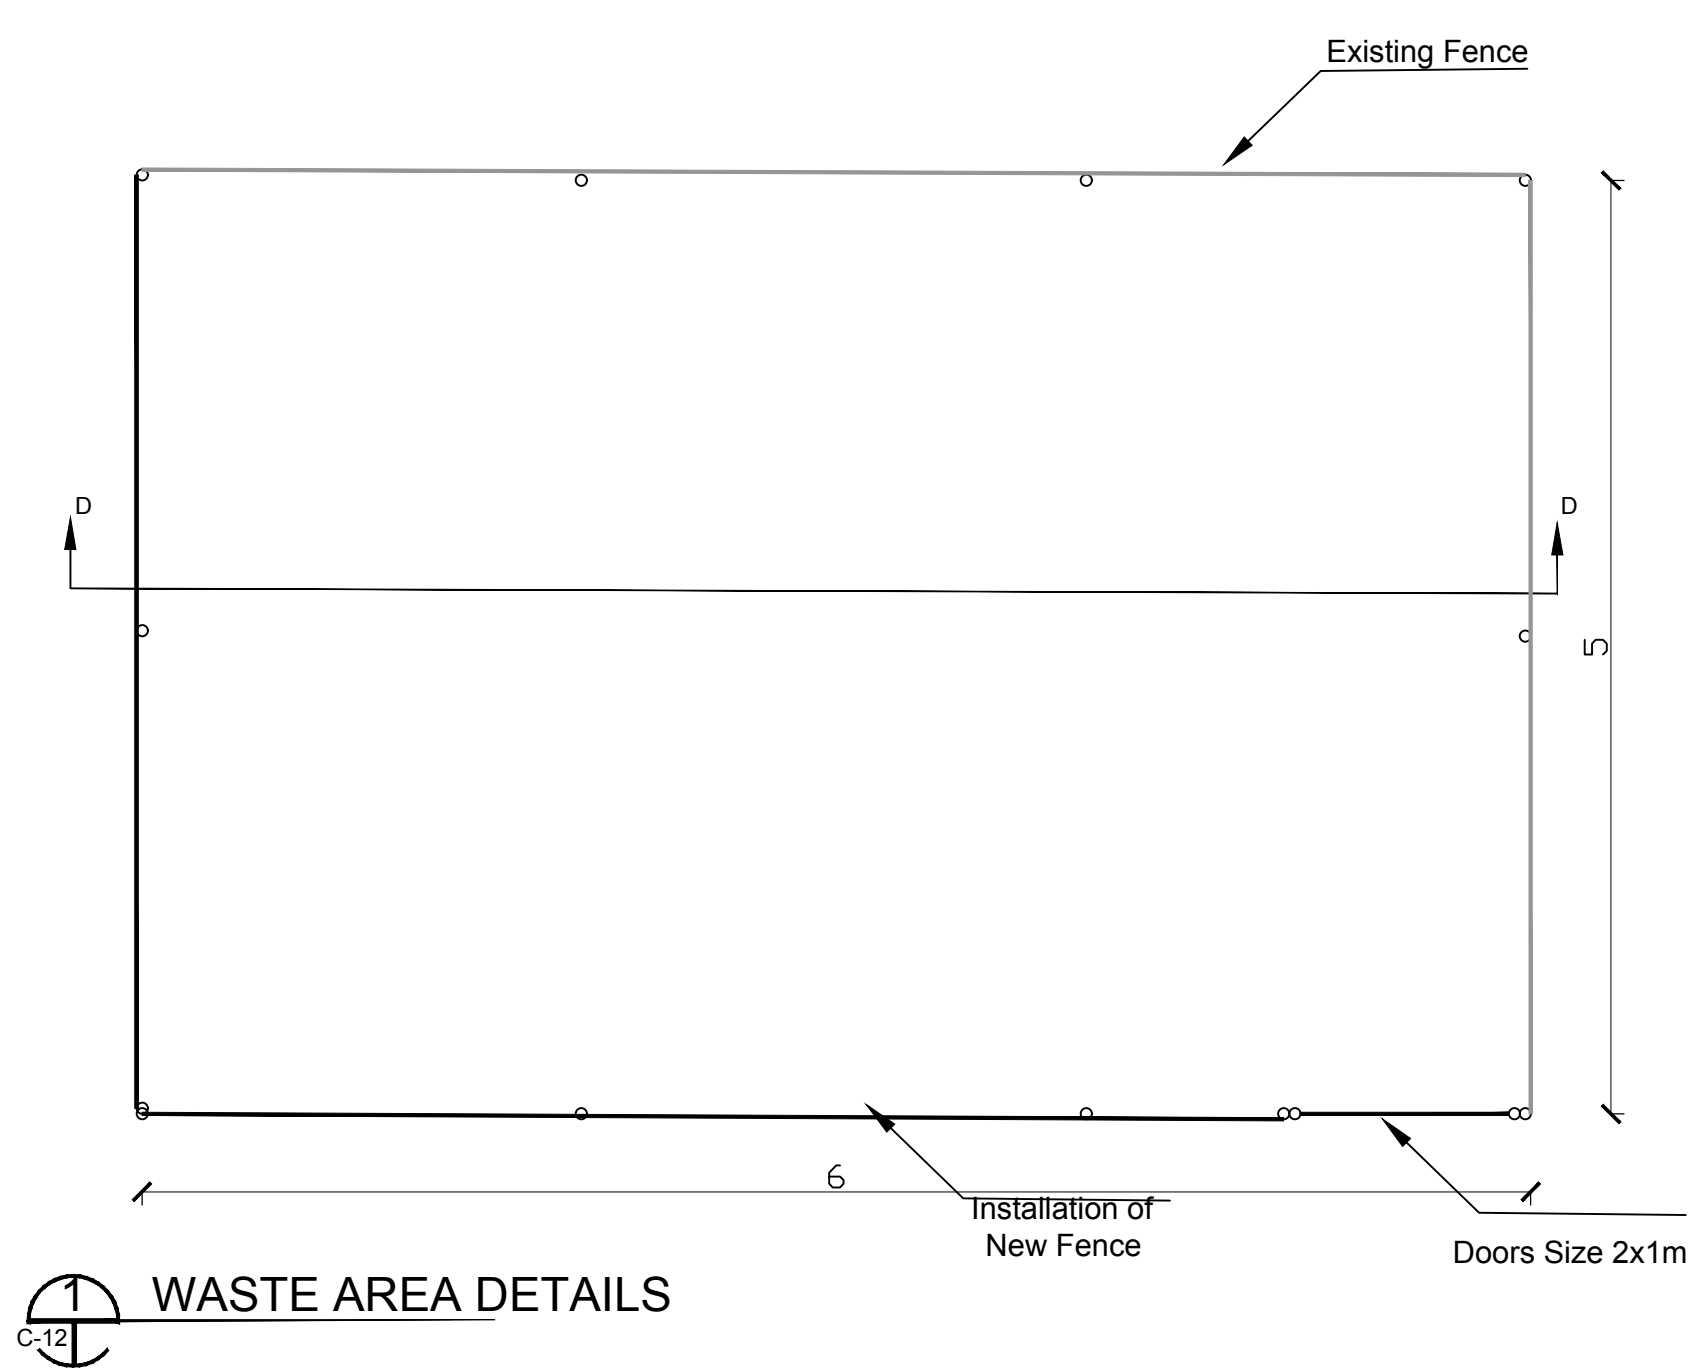


	SURVEYED BY	MDM ENGINEER	CHECKED BY	MDM TEAM	SCALE		SHEET NO. 	PROVINCE	NIMROZ	PROJECT NAME: MAJOR REHABILITATION OF HEALTH CENTER
	DESIGNED BY	MDM ENGINEER	REVIEWED BY	MDM TEAM	DATE	26-04-2026		DISTRICT	DALARAM	
	DRAWN BY	MDM ENGINEER	APPROVED BY	MDM TEAM	DRAWING NO.			VILLAGE	JILARGI	DRAWING TITLE: C-12

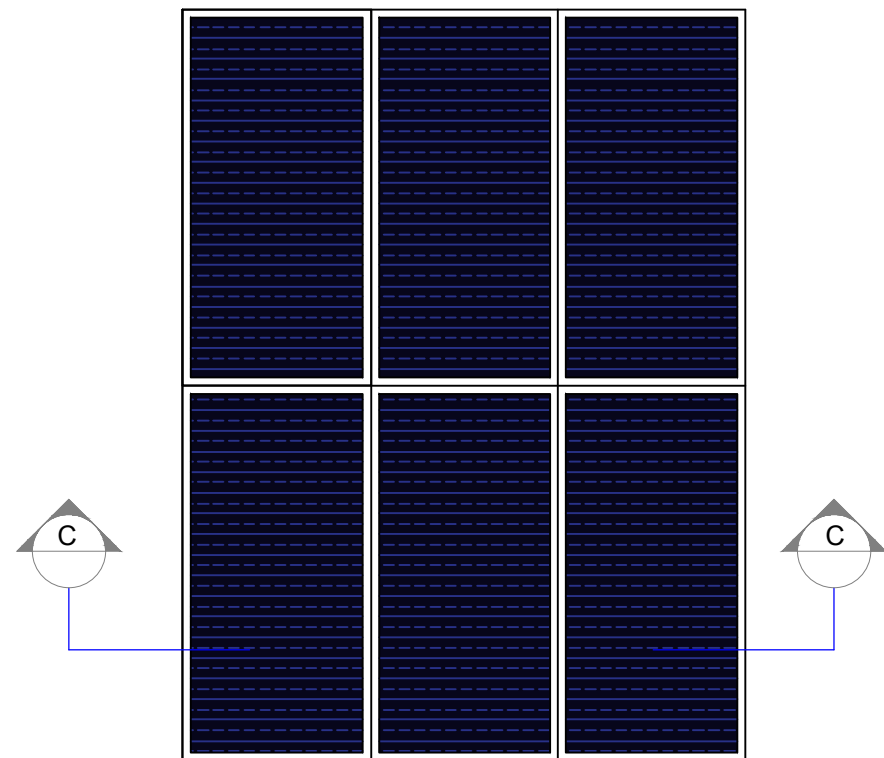

1 SOLAR PANEL

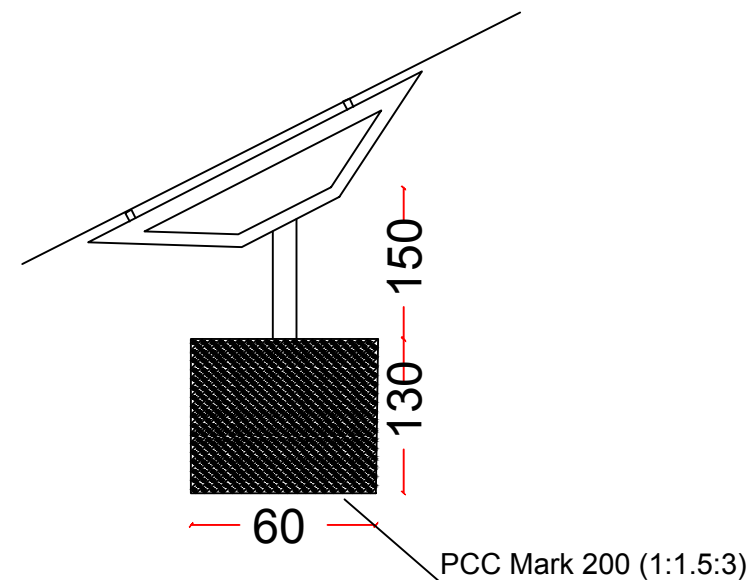

2 SECTION C-C

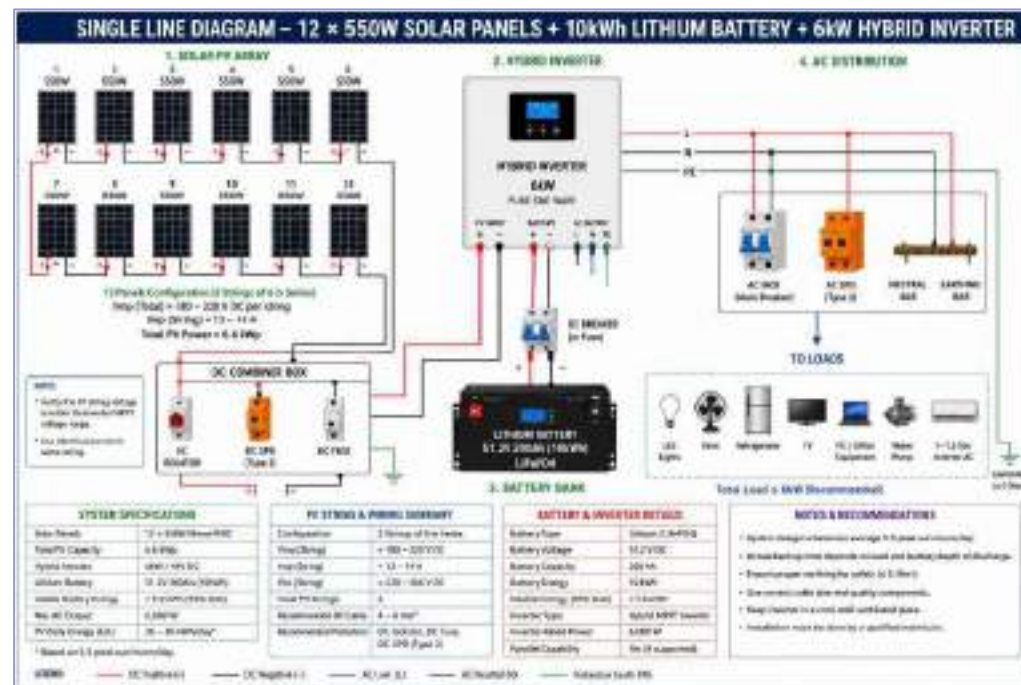

3 SOLAR PANEL INSTALLATION

 MEDECINS DU MONDE MDM	SURVEYED BY	MDM ENGINEER	CHECKED BY	MDM TEAM	SCALE		SHEET NO. 13/13	PROVINCE	NIMROZ	PROJECT NAME: MAJOR REHABILITATION OF HEALTH CENTER
	DESIGNED BY	MDM ENGINEER	REVIEWED BY	MDM TEAM	DATE	26-04-2026		DISTRICT	DALARAM	
	DRAWN BY	MDM ENGINEER	APPROVED BY	MDM TEAM	DRAWING NO.			VILLAGE	JILARGI	DRAWING TITLE: C-13