




**MEDECINS DU MONDE
MDM**

DESIGN DRAWINGS

REHABILITATION OF HEALTH FACILITIES PROJECTS IN AFGHANISTAN

Rehabilitation/Improvement of Health Facilities Infrastructure for Health Sub Center Project at Mazad (SHC) Village, Khash Rod District, Nimruz Province

PLAN AND SECTION

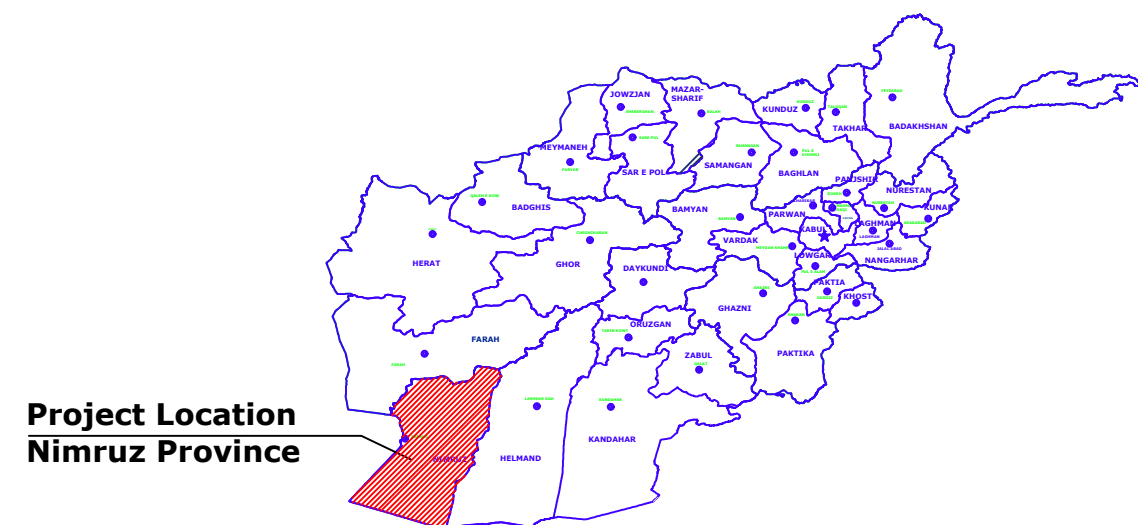

SUBMISSION DATE : - APR- 2026

Mazad (SHC)-Khash Rud District-Nimruz Province-GIS Plan



Legends

- Existing Boundary Wall
- Existing Rooms
- Existing Water Well
- Main Gate

Mazad SHC

Coordinate Details						
No	Location			N	E	Remark
1	Province	District	Village	3489524	474529	HSC
	Nimruz	Khash Rud	Mazad			




Rehabilitation of HSC Building in Mazad, Khash Rud District, Nimruz, Afghanistan

Index Sheet

SHEET REF. #	SHEET TITLE	DATE
	GENERAL	
	COVER SHEET	APR-26
C-01	PROJECT VICINITY AERIAL MAP & LOCATION MAP	APR-26
C-02	INDEX SHEET	APR-26
C-03	EXISTING SITE PLAN	APR-26
C-04	DETAIL UPGRADE PLAN	APR-26
C-05	SIDE WALK PLAN	APR-26
C-06	WATER SUPPLY PLAN	APR-26
C-07	SEWER PLAN	APR-26
C-08	POWER PLAN	APR-26
C-09	DOORS AND WINDOWS PLAN	APR-26
C-10	DOORS AND WINDOWS DETAILS	APR-26
C-11	SEPTIC TANK AND TOILET DETAILS	APR-26
C-12	WASTE AREA DETAILS	APR-26
C-13	SOLAR PANELS INSTALLATION DETAILS	APR-26



 MEDECINS DU MONDE MDM	SURVEYED BY	MDM ENGINEER	CHECKED BY	MDM TEAM	SCALE		SHEET NO. 	PROVINCE	NIMROZ	PROJECT NAME: MAJOR REHABILITATION OF HEALTH CENTER
	DESIGNED BY	MDM ENGINEER	REVIEWED BY	MDM TEAM	DATE	01-06-2026		DISTRICT	KHASH ROD	
	DRAWN BY	MDM ENGINEER	APPROVED BY	MDM TEAM	DRAWING NO.			VILLAGE	MAZAD	DRAWING TITLE: C-02

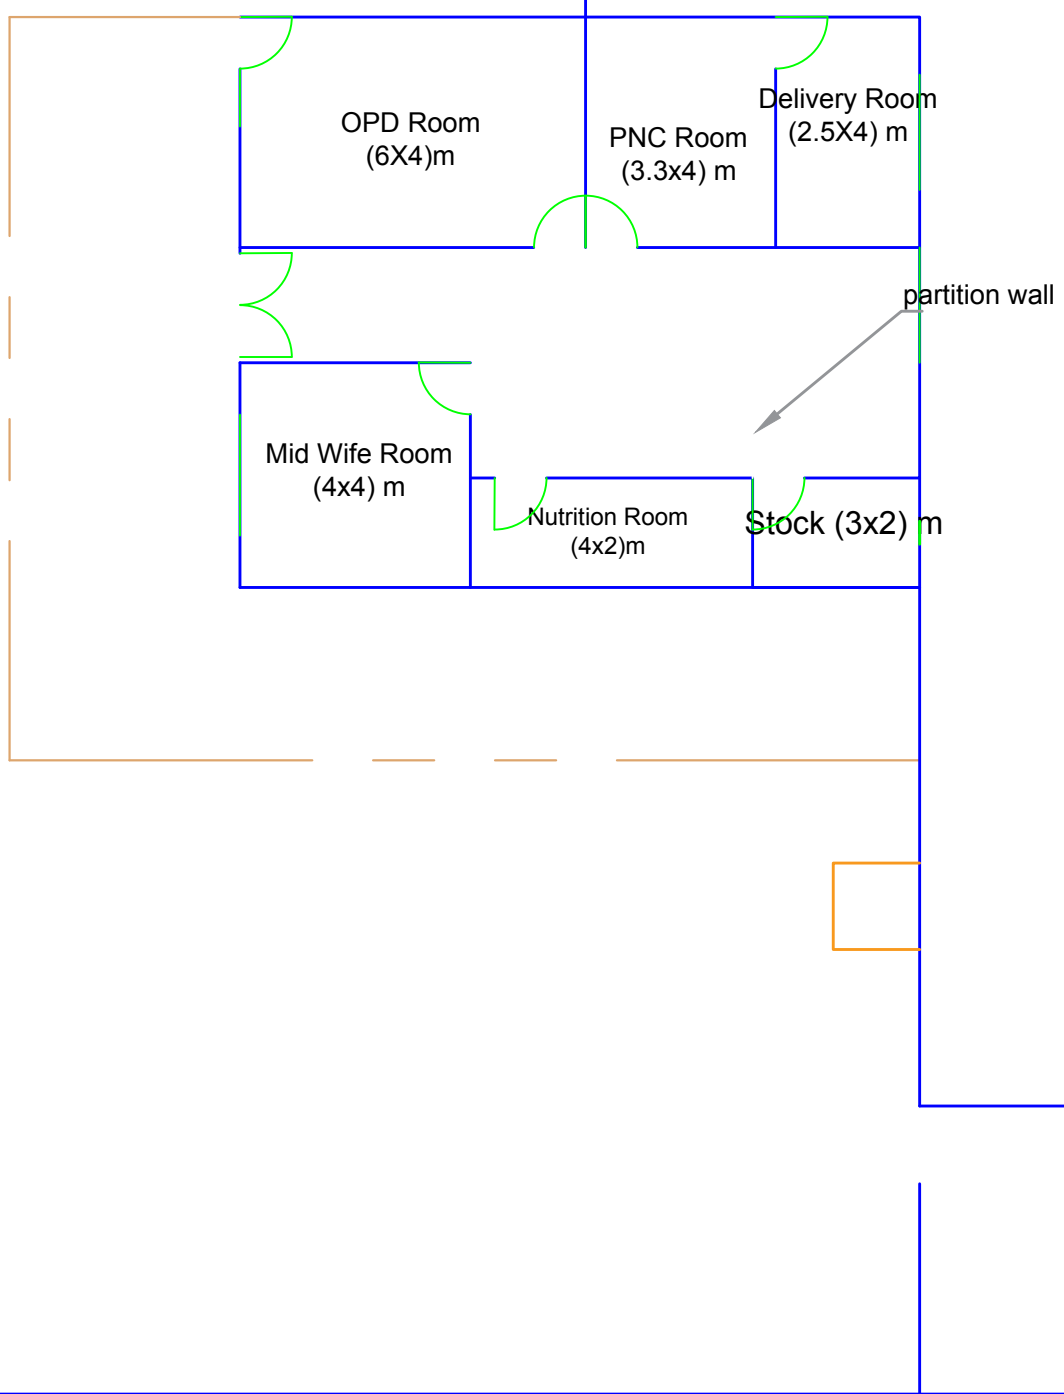

Legends

- Existing Boundary Wall
- Existing Rooms
- Existing Water Point
- Main Gate
- Existing Toilet


 EXISTING SITE PLAN

 MEDECINS DU MONDE MDM	SURVEYED BY	MDM ENGINEER	CHECKED BY	MDM TEAM	SCALE		SHEET NO. 03/13	PROVINCE	NIMROZ	PROJECT NAME: MAJOR REHABILITATION OF HEALTH CENTER	
	DESIGNED BY	MDM ENGINEER	REVIEWED BY	MDM TEAM	DATE	01-06-2026		DISTRICT	KHASH ROD	DRAWING TITLE:	
	DRAWN BY	MDM ENGINEER	APPROVED BY	MDM TEAM	DRAWING NO.			VILLAGE	MAZAD	C-03	





Legends

- Existing Boundary Wall
- Existing Water Well
- Main Gate
- Proposed Waste Area
- Proposed M-Toilet
- Proposed F-Toilet
- Proposed Septic Tank

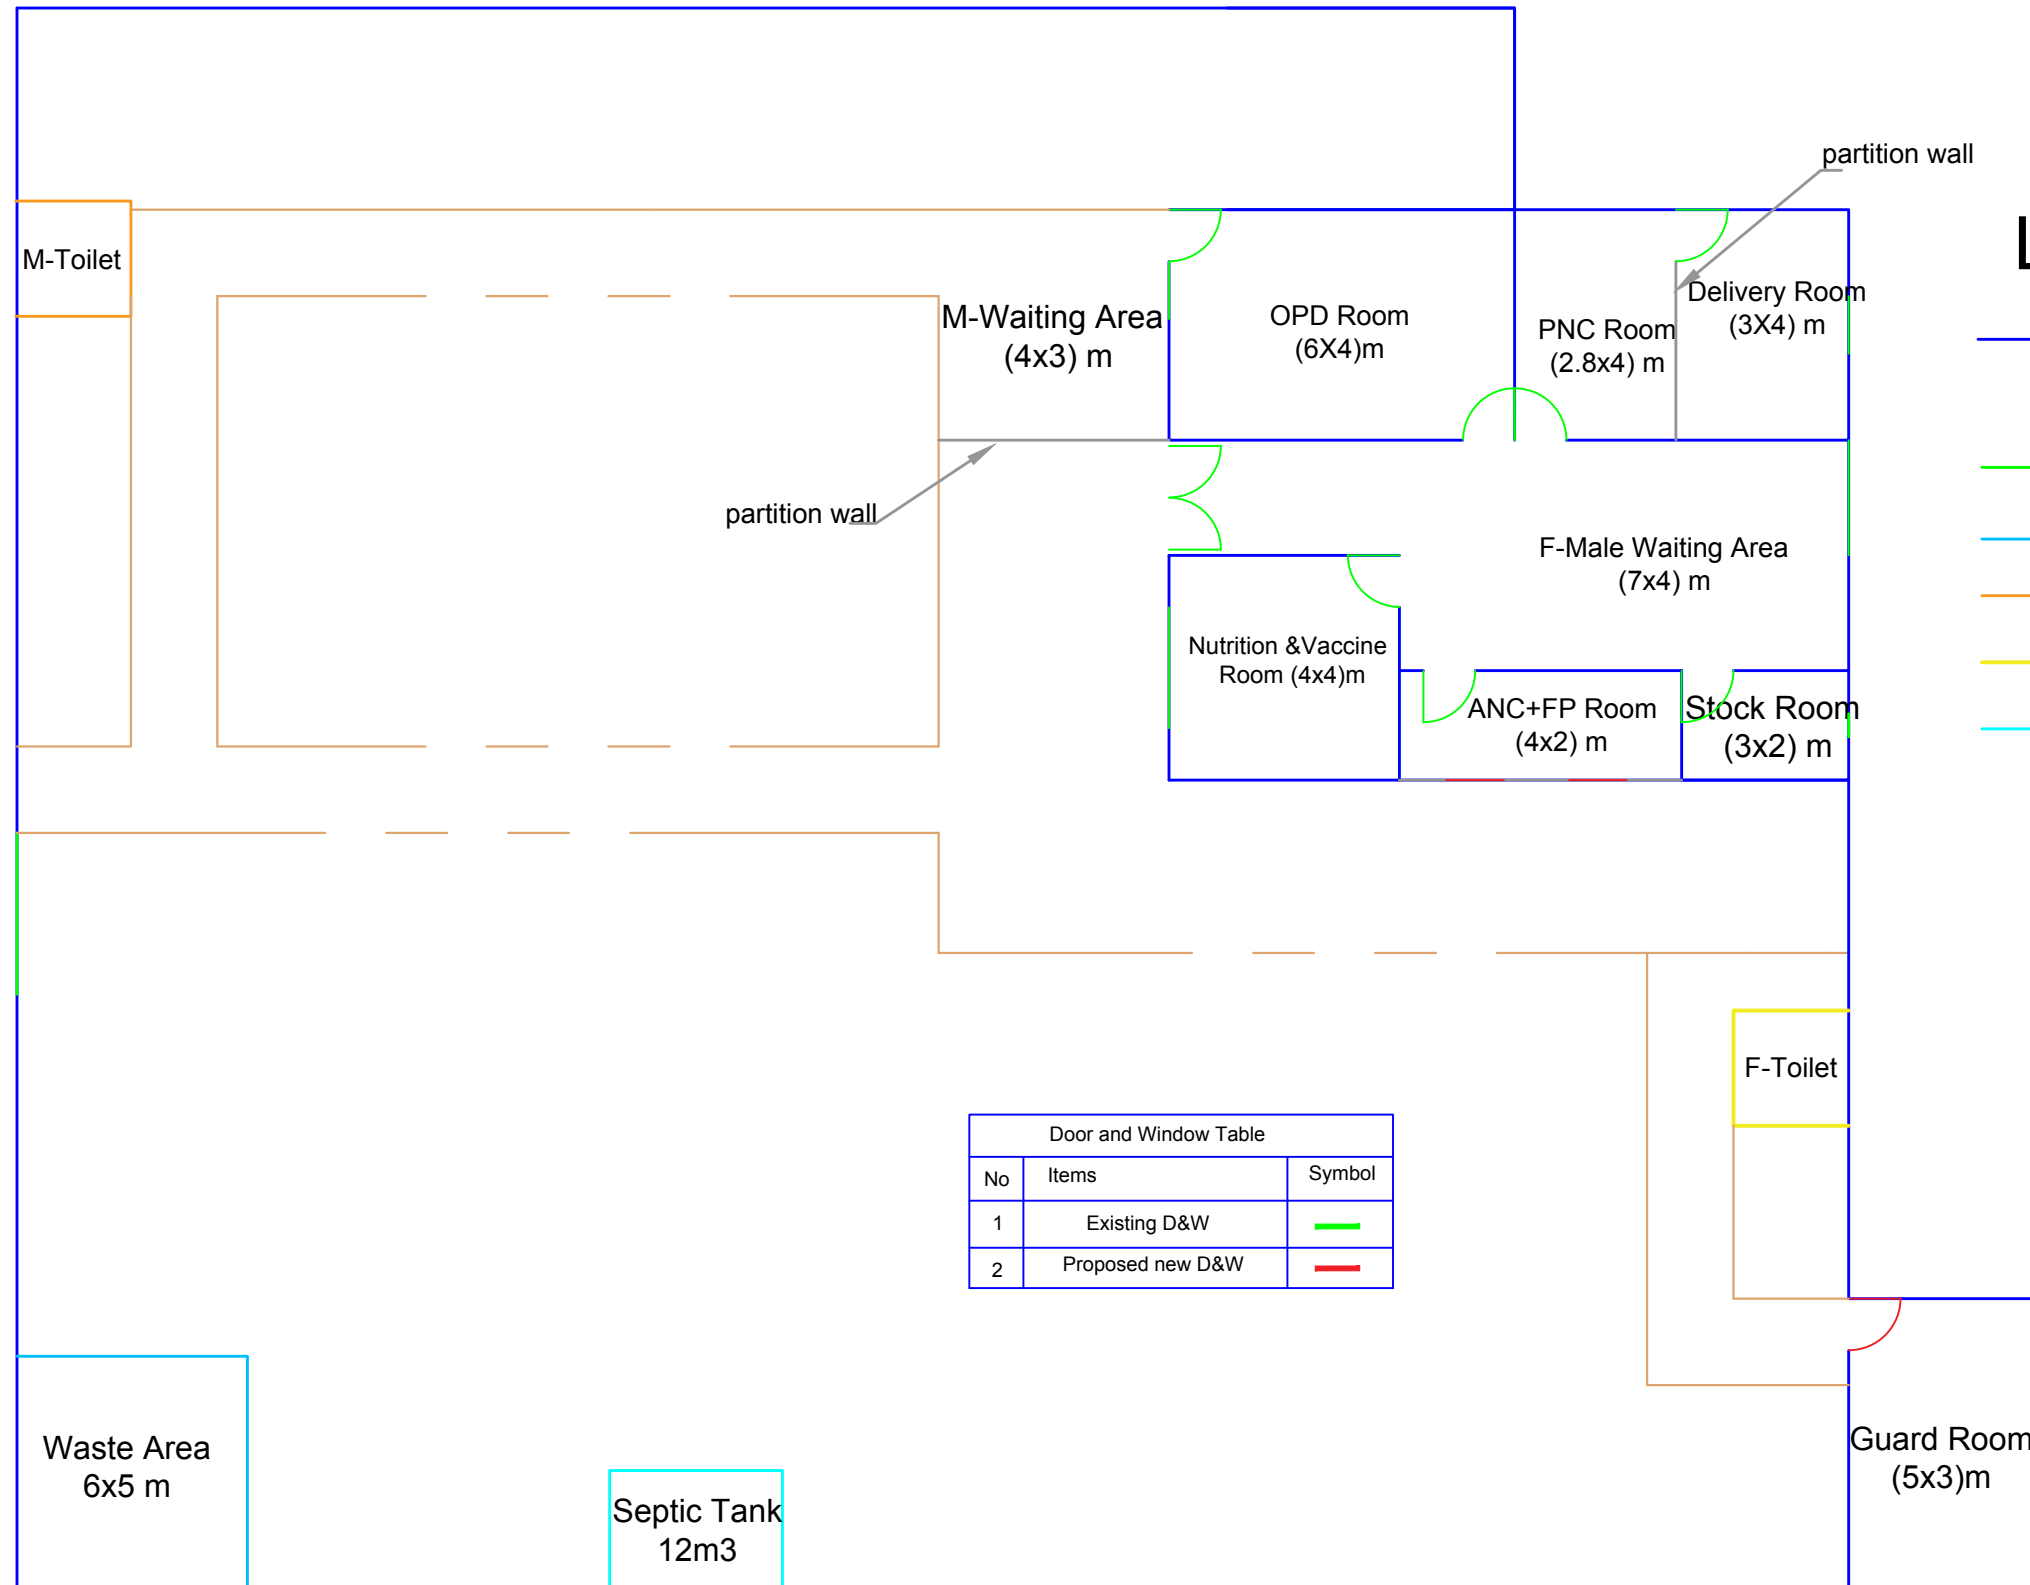



UPGRADE SITE PLAN
C-04

  MEDECINS DU MONDE MDM	SURVEYED BY	MDM ENGINEER	CHECKED BY	MDM TEAM	SCALE		SHEET NO. 	PROVINCE	NIMROZ	PROJECT NAME: MAJOR REHABILITATION OF HEALTH CENTER
	DESIGNED BY	MDM ENGINEER	REVIEWED BY	MDM TEAM	DATE	01-06-2026		DISTRICT	KHASH ROD	
	DRAWN BY	MDM ENGINEER	APPROVED BY	MDM TEAM	DRAWING NO.			VILLAGE	MAZAD	DRAWING TITLE: C-04

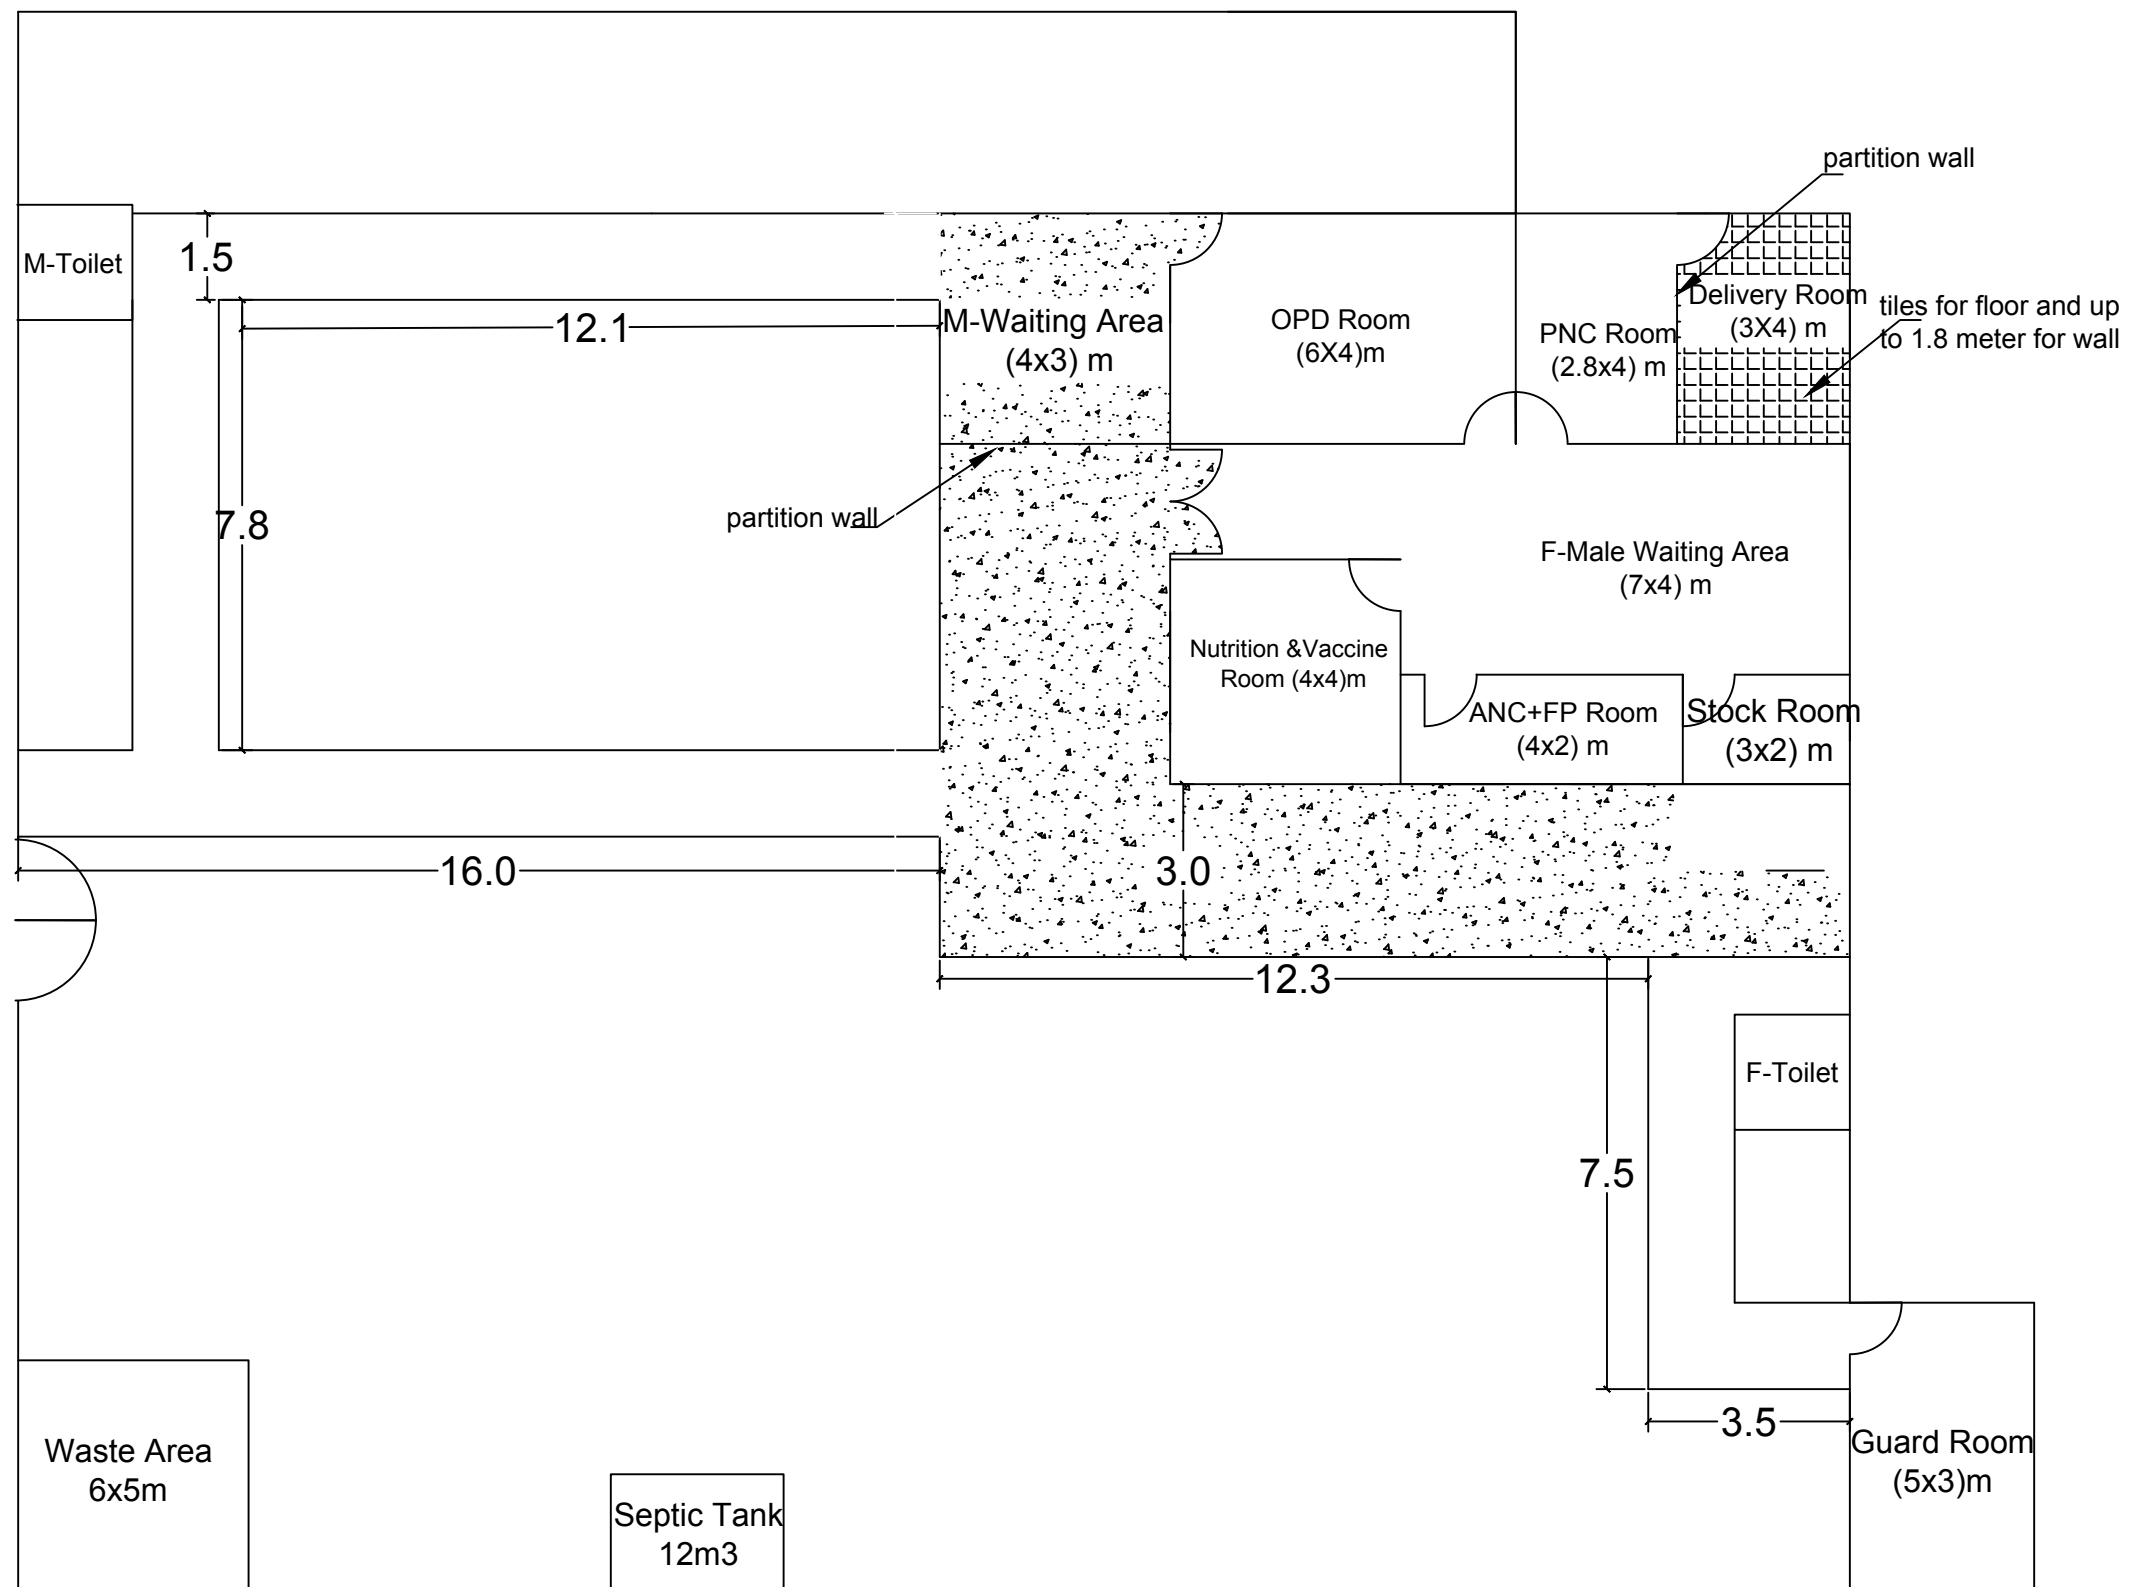


1 SIDE WALK PLAN
C-05

  MEDECINS DU MONDE MDM	SURVEYED BY	MDM ENGINEER	CHECKED BY	MDM TEAM	SCALE		SHEET NO. 	PROVINCE	NIMROZ	PROJECT NAME: MAJOR REHABILITATION OF HEALTH CENTER
	DESIGNED BY	MDM ENGINEER	REVIEWED BY	MDM TEAM	DATE	01-06-2026		DISTRICT	KHASH ROD	
	DRAWN BY	MDM ENGINEER	APPROVED BY	MDM TEAM	DRAWING NO.			VILLAGE	MAZAD	DRAWING TITLE: C-05

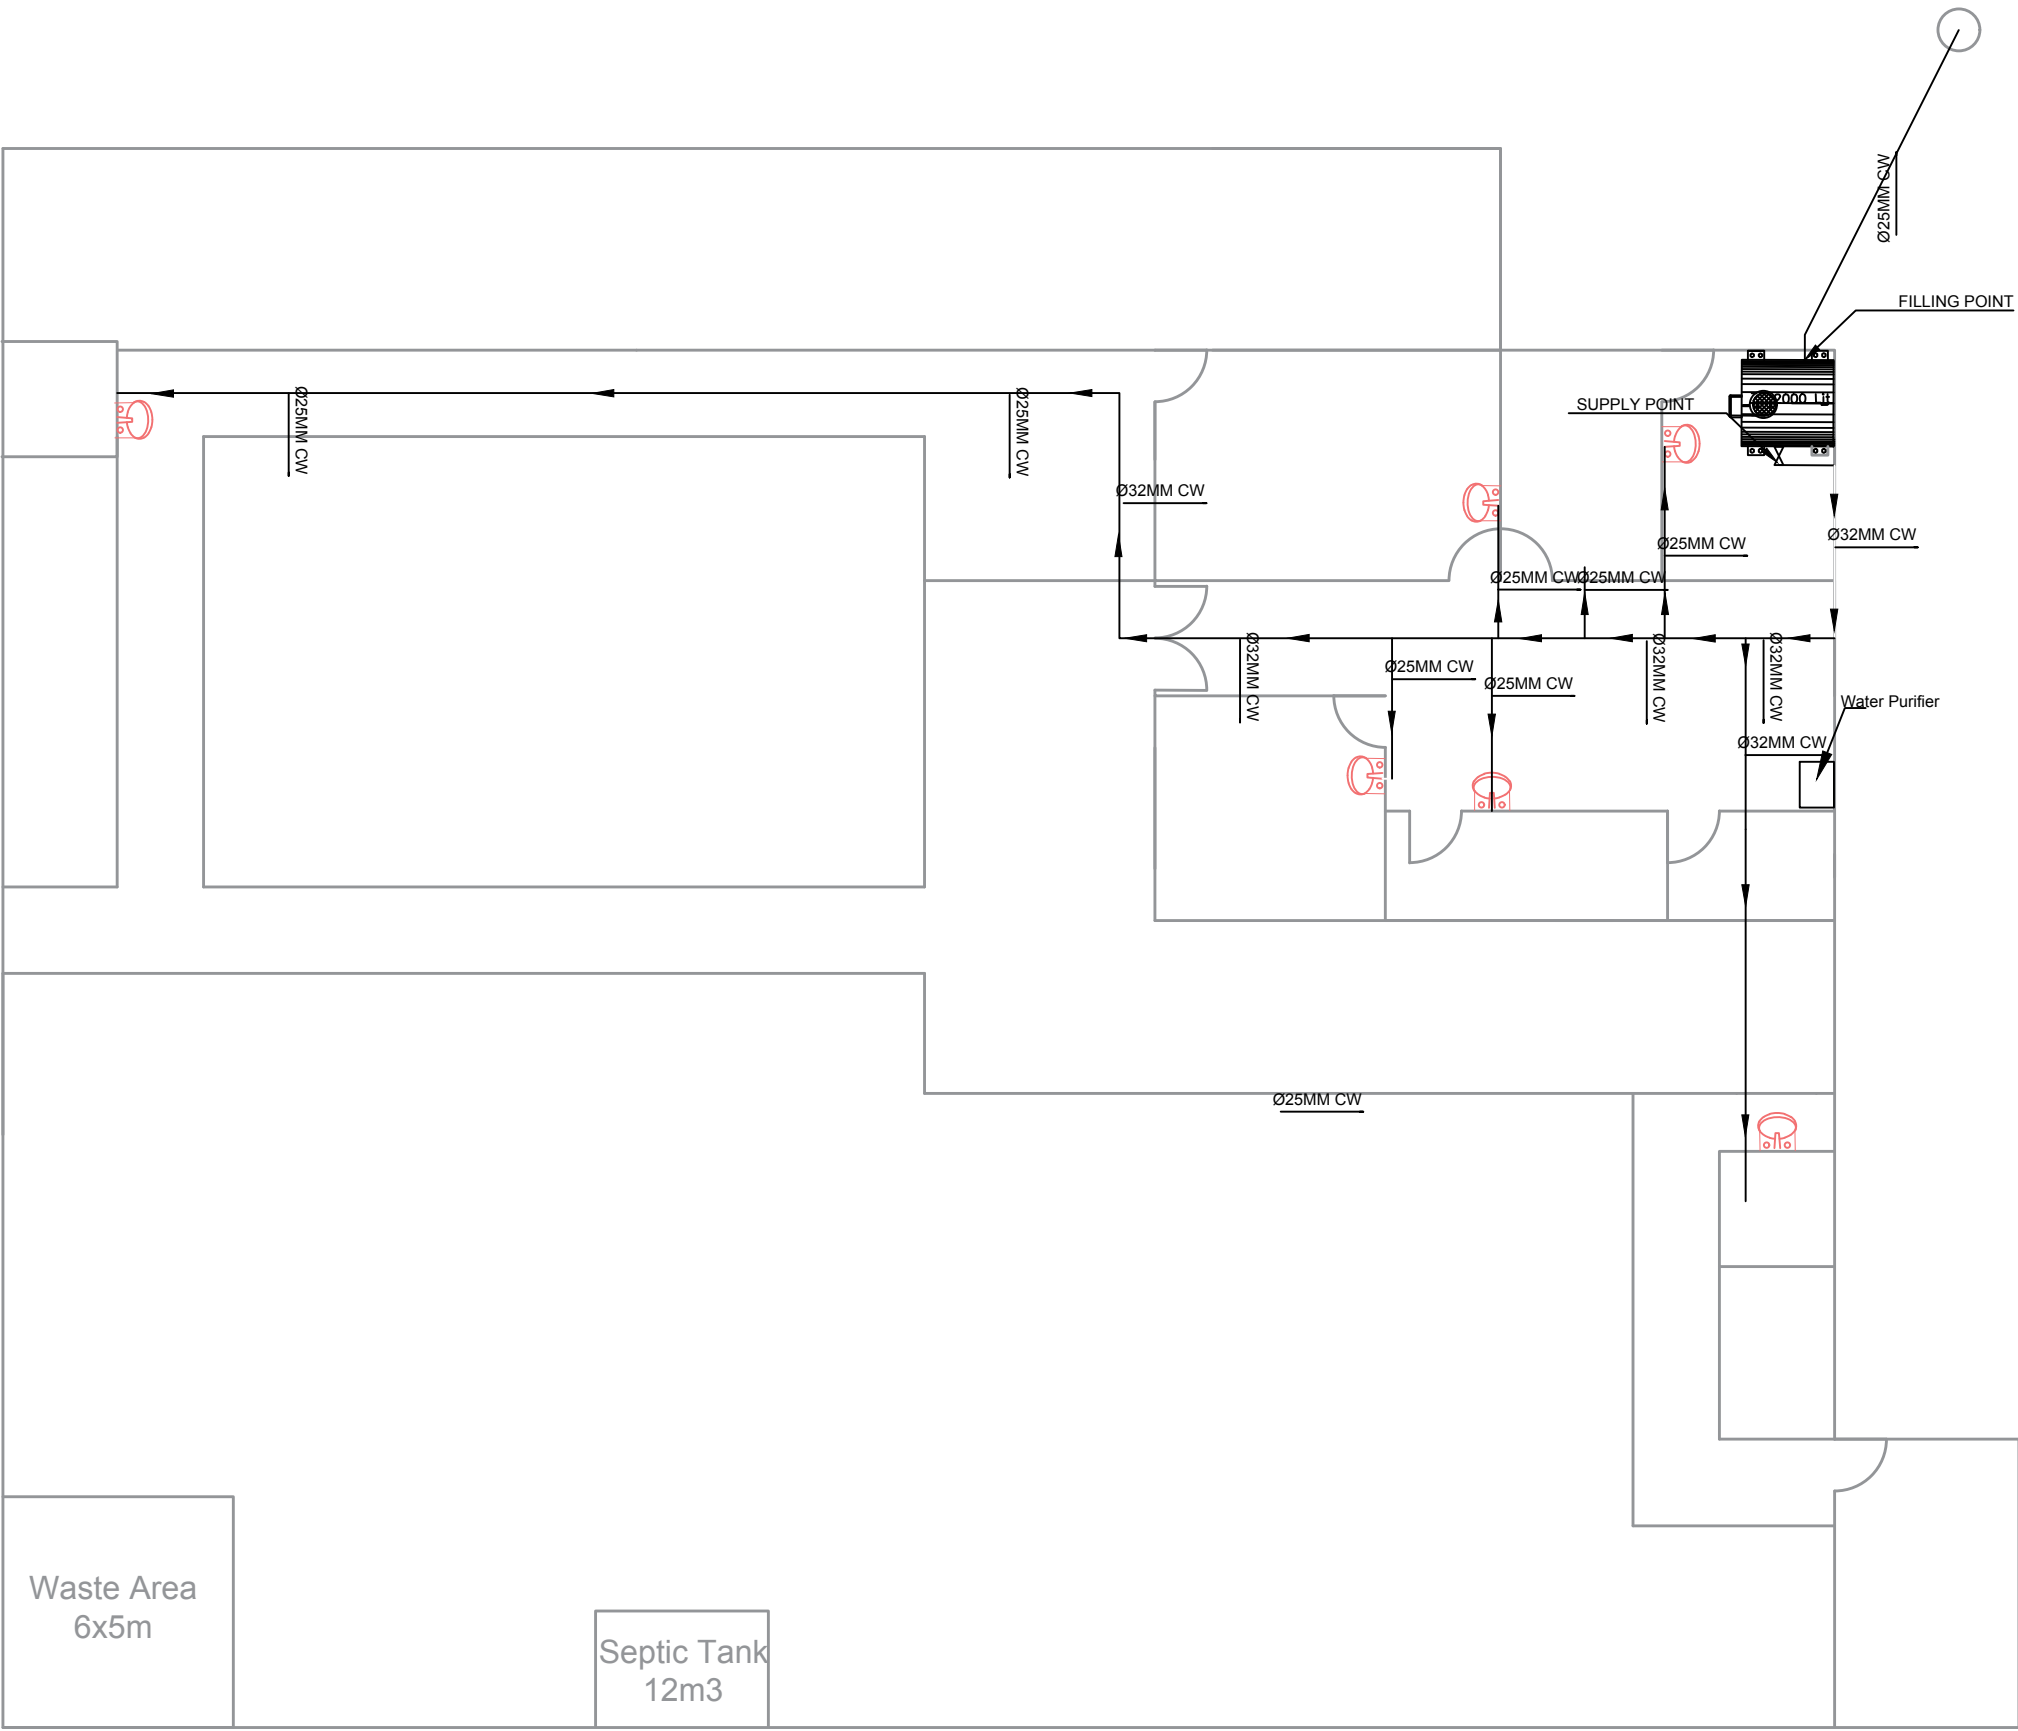

1 WATER SUPPLY PLAN
C-06


 MEDECINS DU MONDE MDM	SURVEYED BY	MDM ENGINEER	CHECKED BY	MDM TEAM	SCALE		SHEET NO. 06/13	PROVINCE	NIMROZ	PROJECT NAME: MAJOR REHABILITATION OF HEALTH CENTER
	DESIGNED BY	MDM ENGINEER	REVIEWED BY	MDM TEAM	DATE	01-06-2026		DISTRICT	KHASH ROD	
	DRAWN BY	MDM ENGINEER	APPROVED BY	MDM TEAM	DRAWING NO.			VILLAGE	MAZAD	DRAWING TITLE: C-06

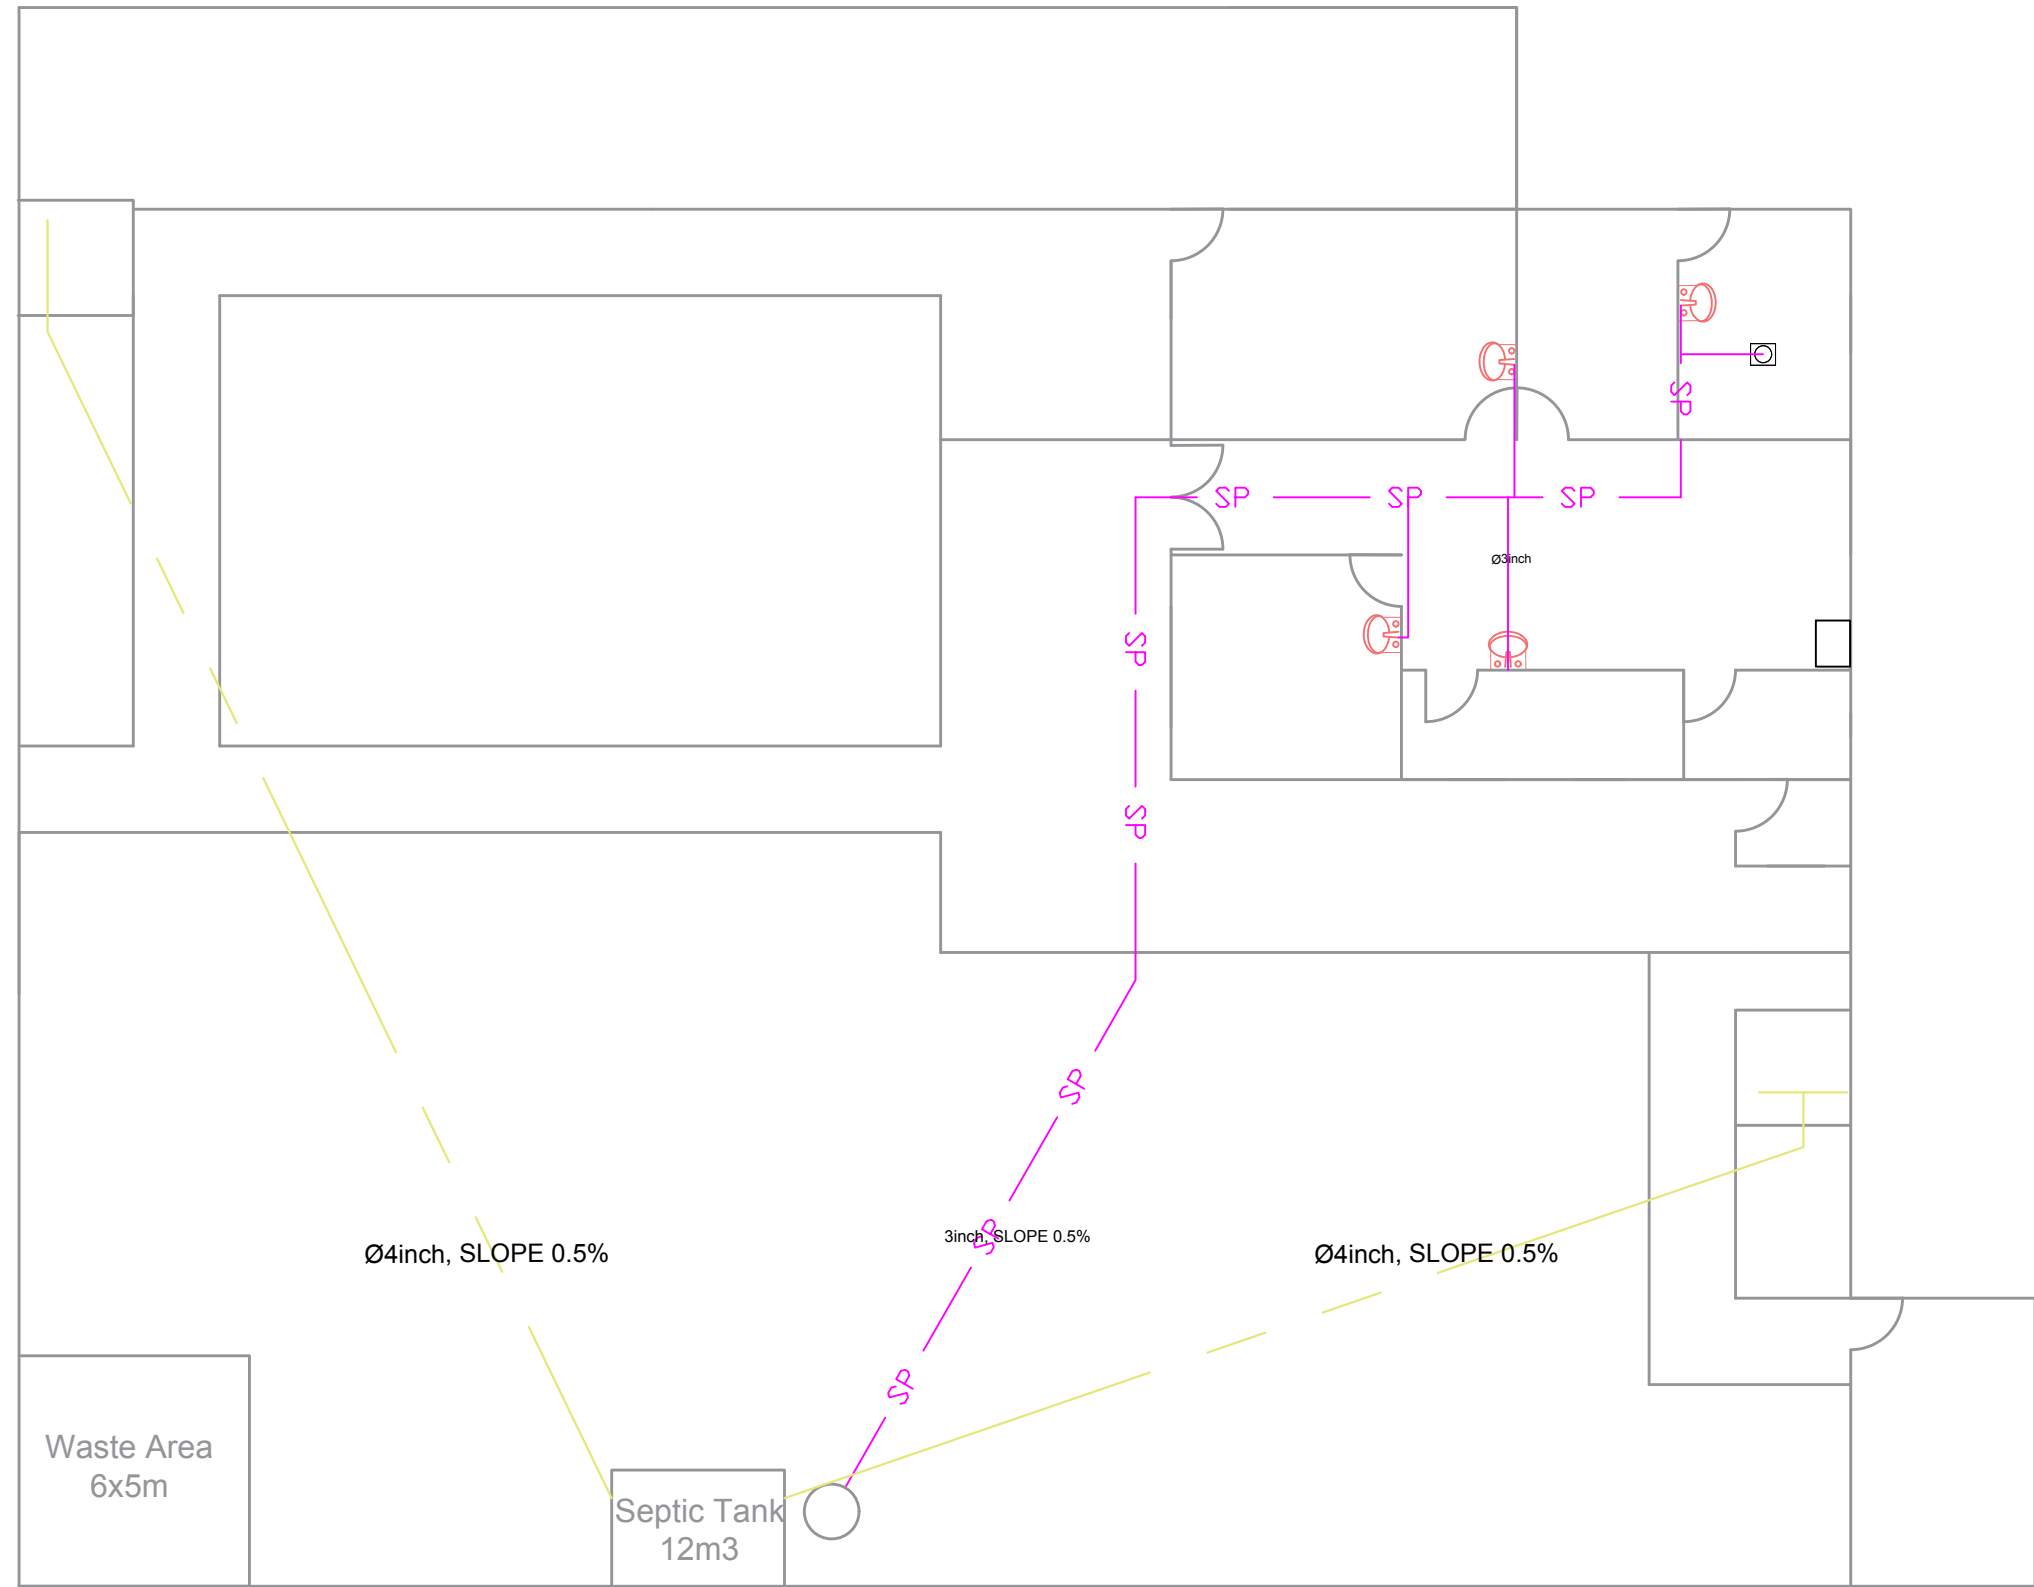


1
C-07


SEWER PLAN

 MEDECINS DU MONDE MDM	SURVEYED BY	MDM ENGINEER	CHECKED BY	MDM TEAM	SCALE		SHEET NO. 07 13	PROVINCE	NIMROZ	PROJECT NAME: MAJOR REHABILITATION OF HEALTH CENTER	
	DESIGNED BY	MDM ENGINEER	REVIEWED BY	MDM TEAM	DATE	01-06-2026		DISTRICT	KHASH ROD	DRAWING TITLE:	
	DRAWN BY	MDM ENGINEER	APPROVED BY	MDM TEAM	DRAWING NO.			VILLAGE	MAZAD	C-07	

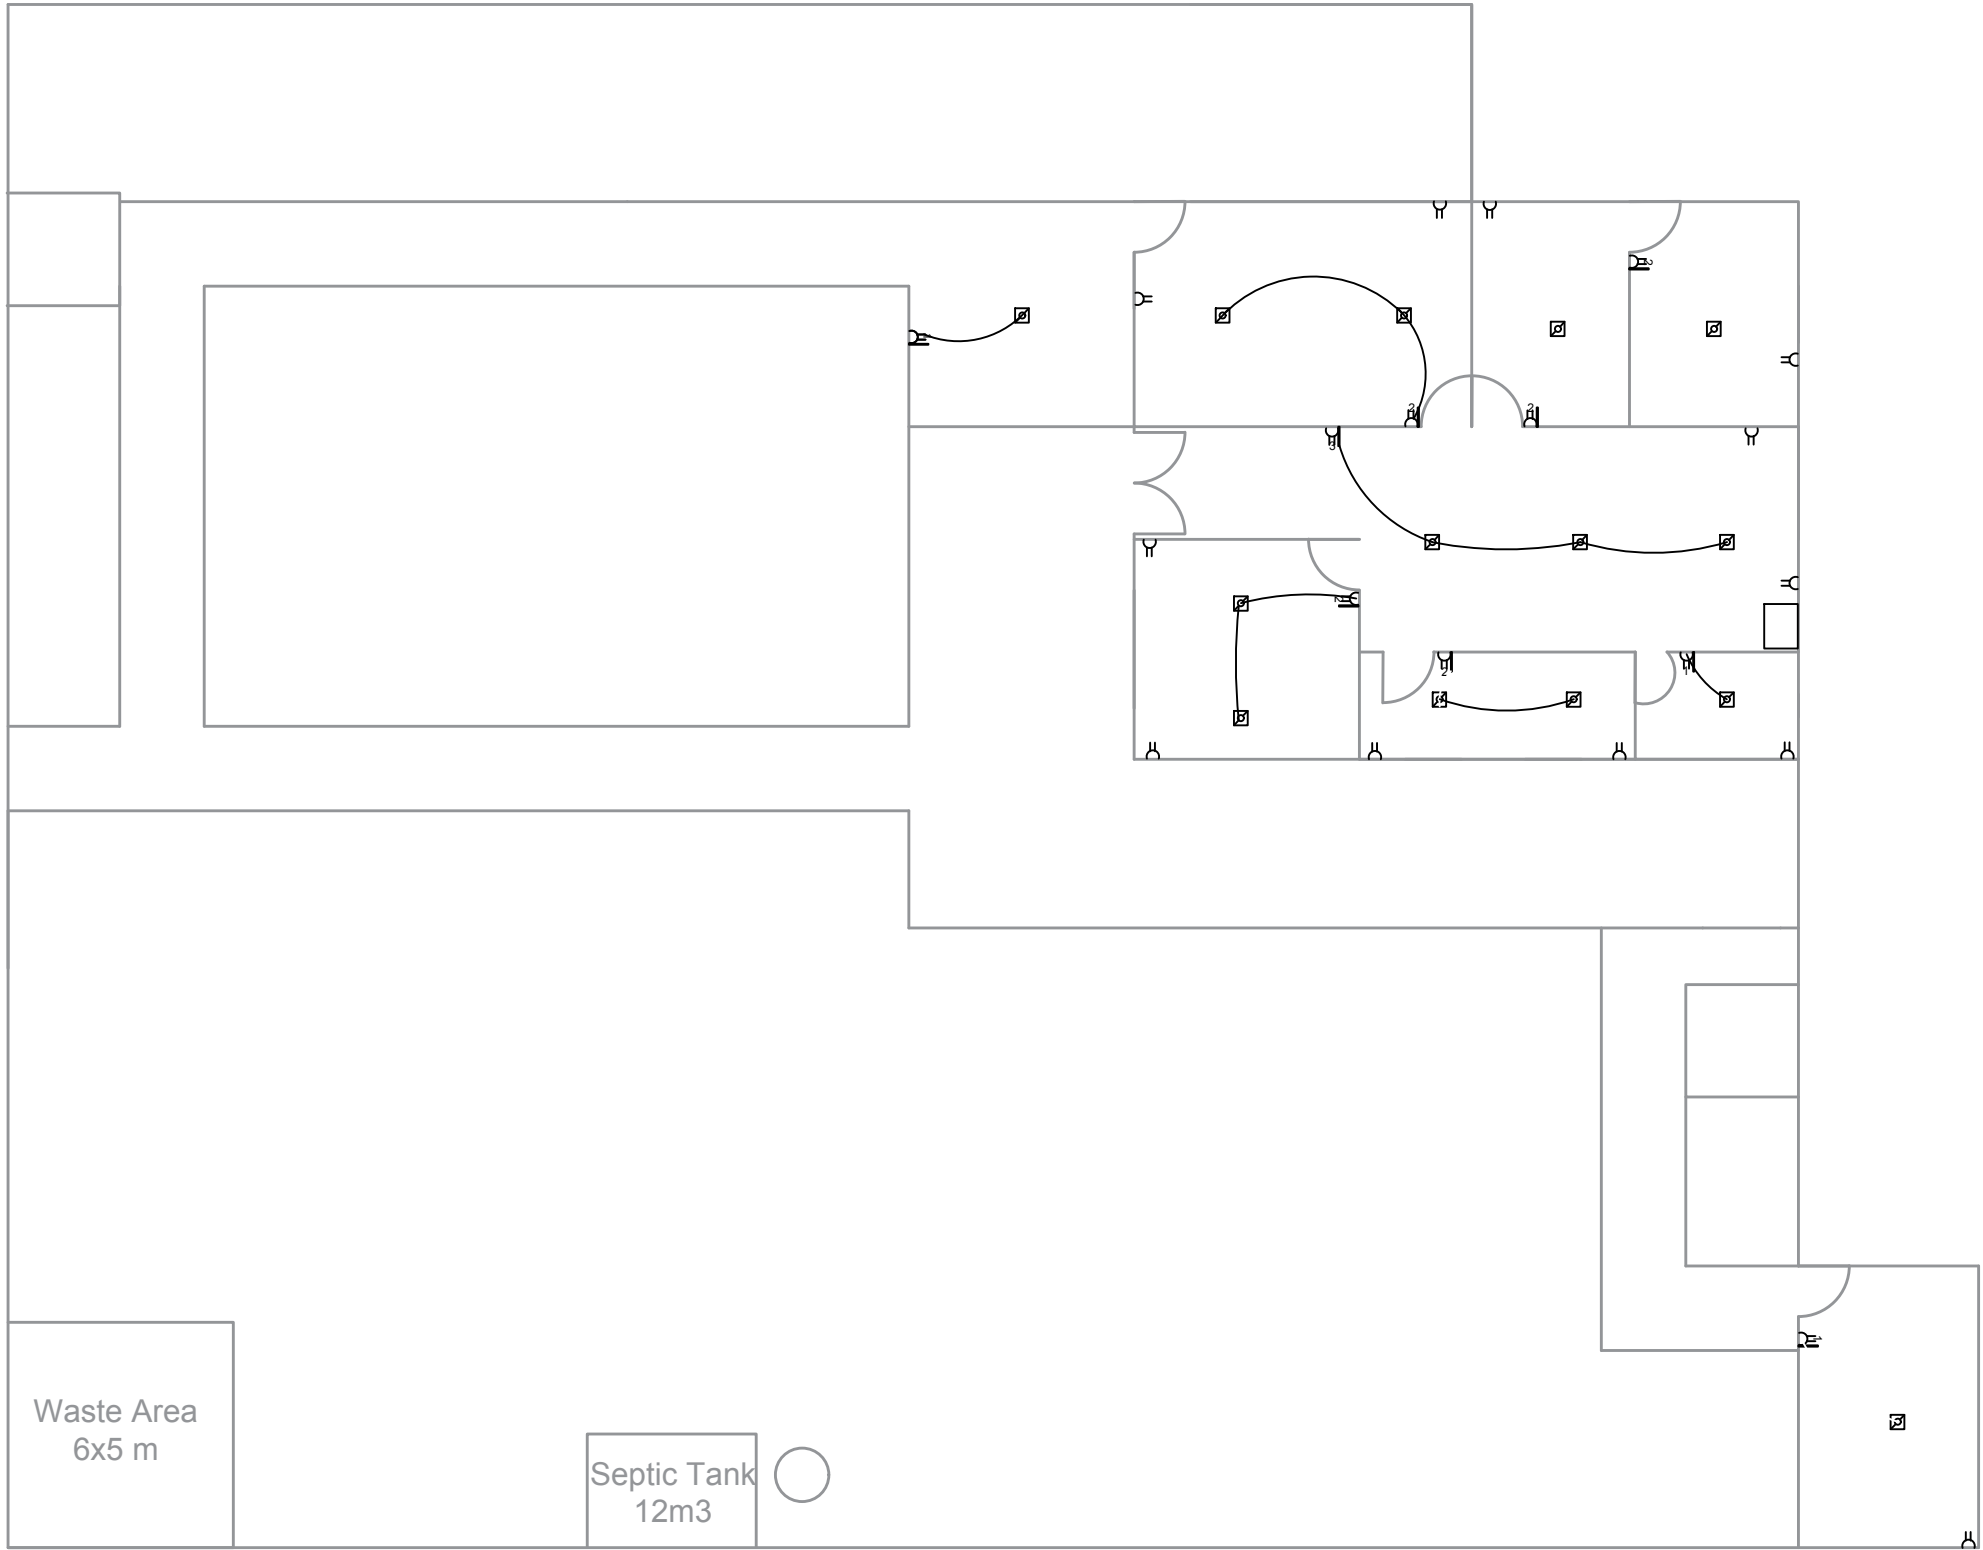


1 POWER PLAN
C-08

 
 MEDECINS DU MONDE MDM	SURVEYED BY	MDM ENGINEER	CHECKED BY	MDM TEAM	SCALE		SHEET NO. 	PROVINCE	NIMROZ	PROJECT NAME: MAJOR REHABILITATION OF HEALTH CENTER	
	DESIGNED BY	MDM ENGINEER	REVIEWED BY	MDM TEAM	DATE	01-06-2026		DISTRICT	KHASH ROD	DRAWING TITLE:	
	DRAWN BY	MDM ENGINEER	APPROVED BY	MDM TEAM	DRAWING NO.			VILLAGE	MAZAD	C-08	

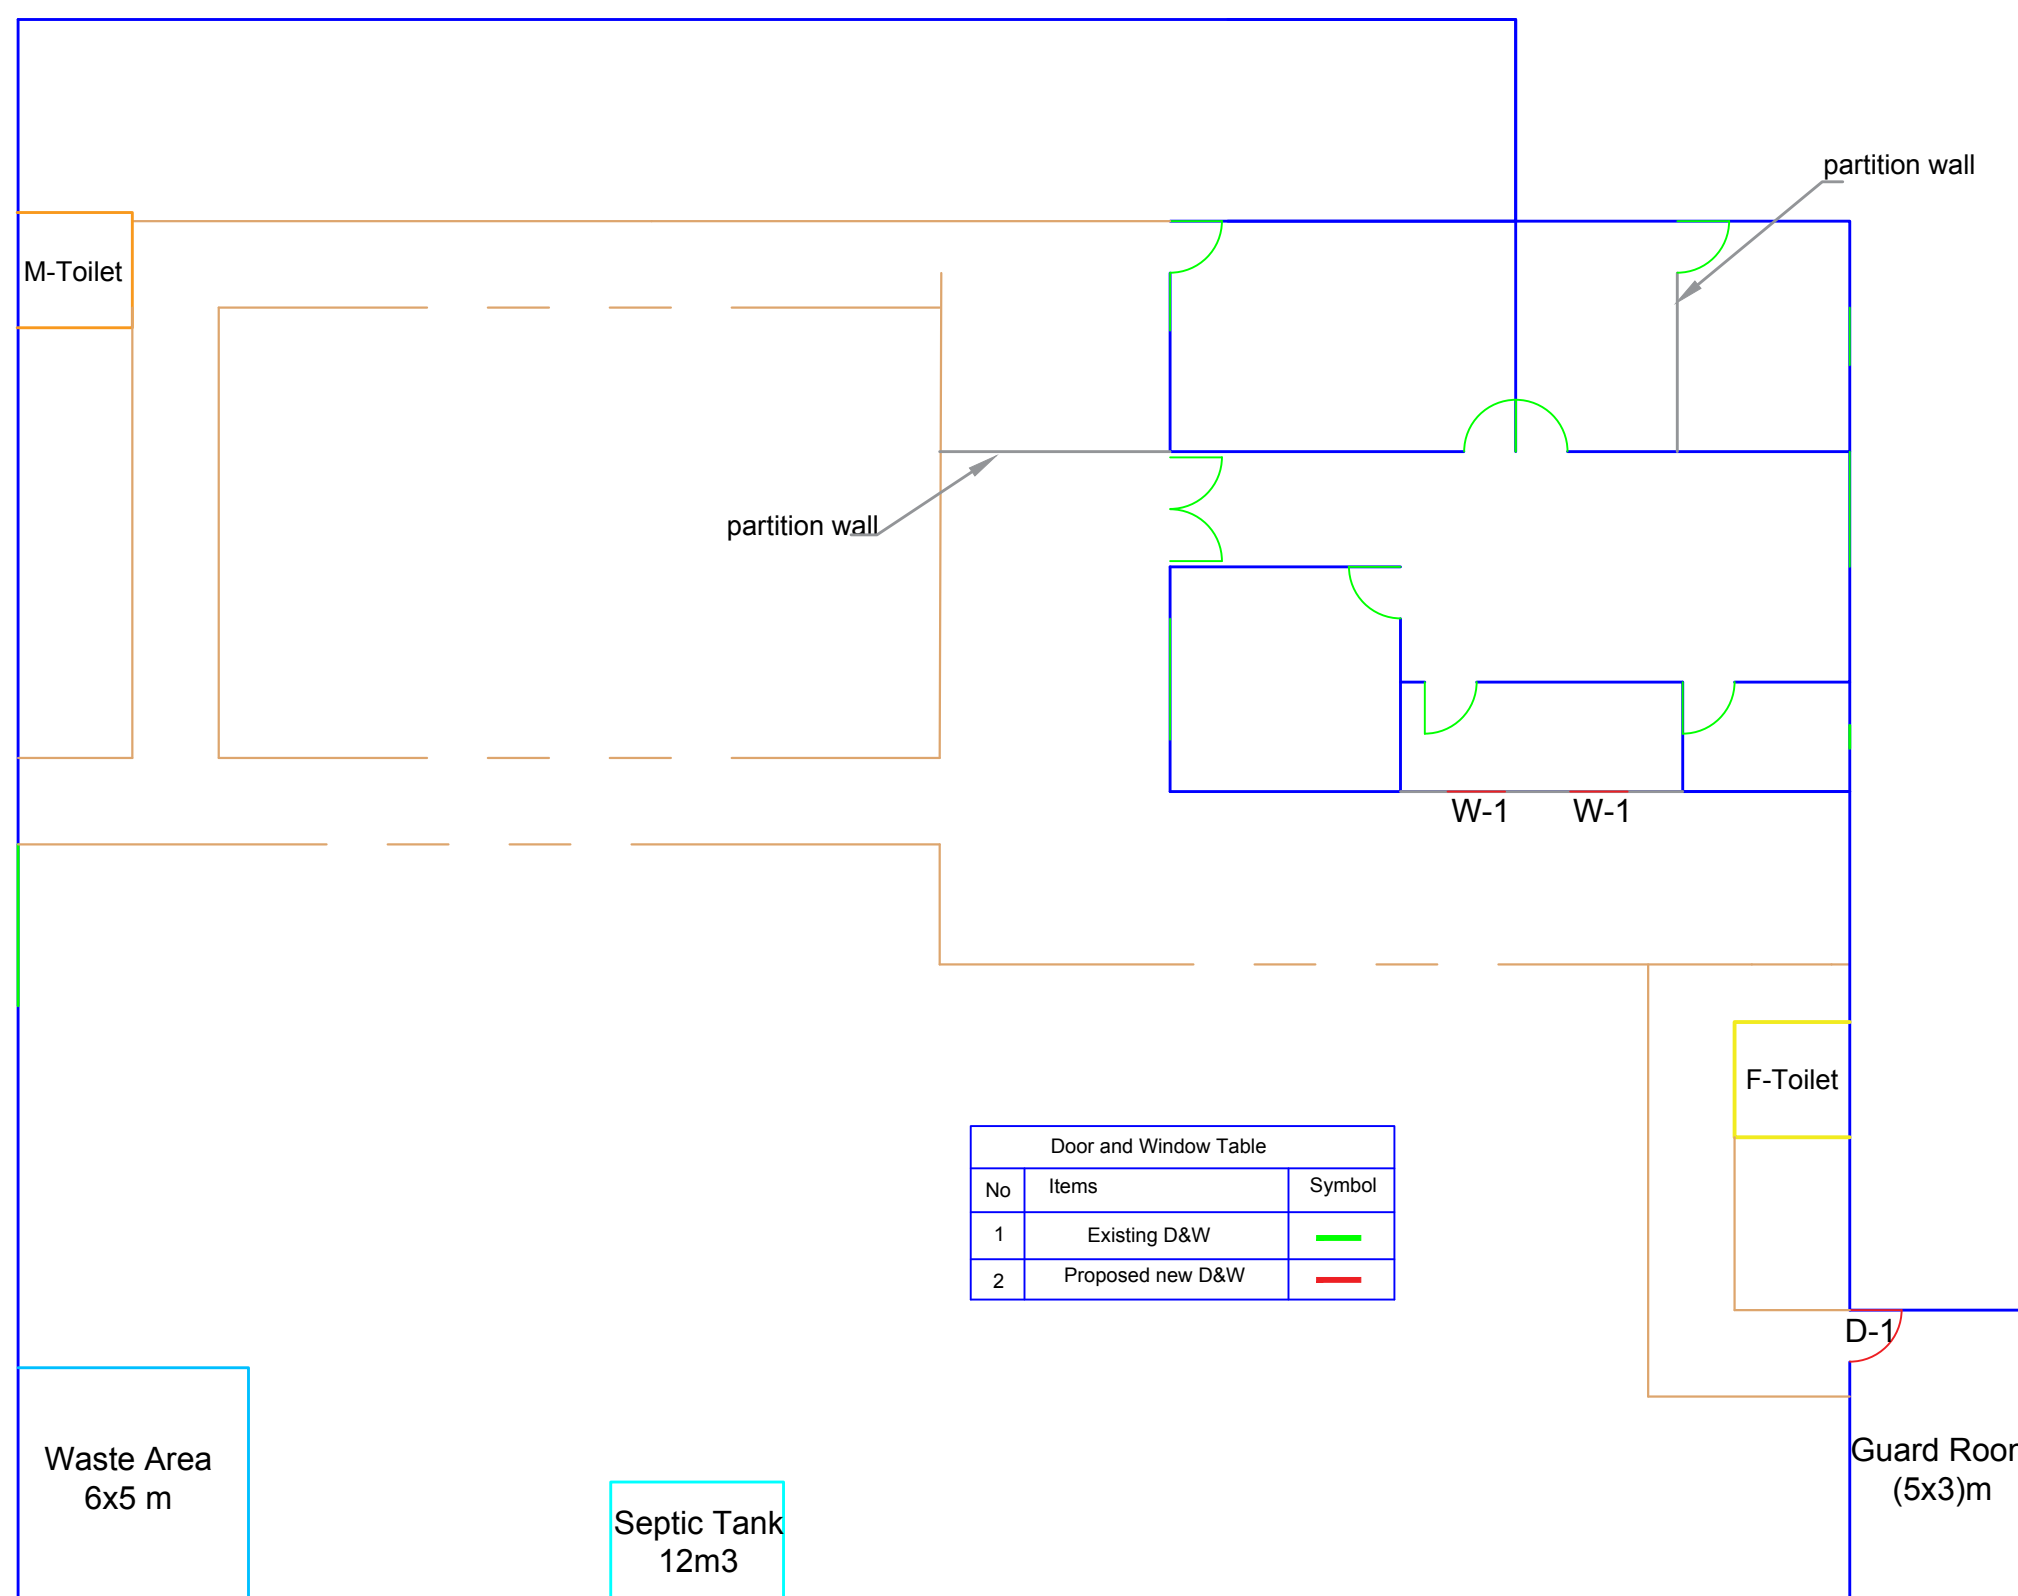

Door and Window Table		
No	Items	Symbol
1	Existing D&W	—
2	Proposed new D&W	—

 
 DOORS PLAN





 MEDECINS DU MONDE MDM	SURVEYED BY	MDM ENGINEER	CHECKED BY	MDM TEAM	SCALE		SHEET NO. 	PROVINCE	NIMROZ	PROJECT NAME: MAJOR REHABILITATION OF HEALTH CENTER
	DESIGNED BY	MDM ENGINEER	REVIEWED BY	MDM TEAM	DATE	01-06-2026		DISTRICT	KHASH ROD	
	DRAWN BY	MDM ENGINEER	APPROVED BY	MDM TEAM	DRAWING NO.			VILLAGE	MAZAD	DRAWING TITLE: C-09

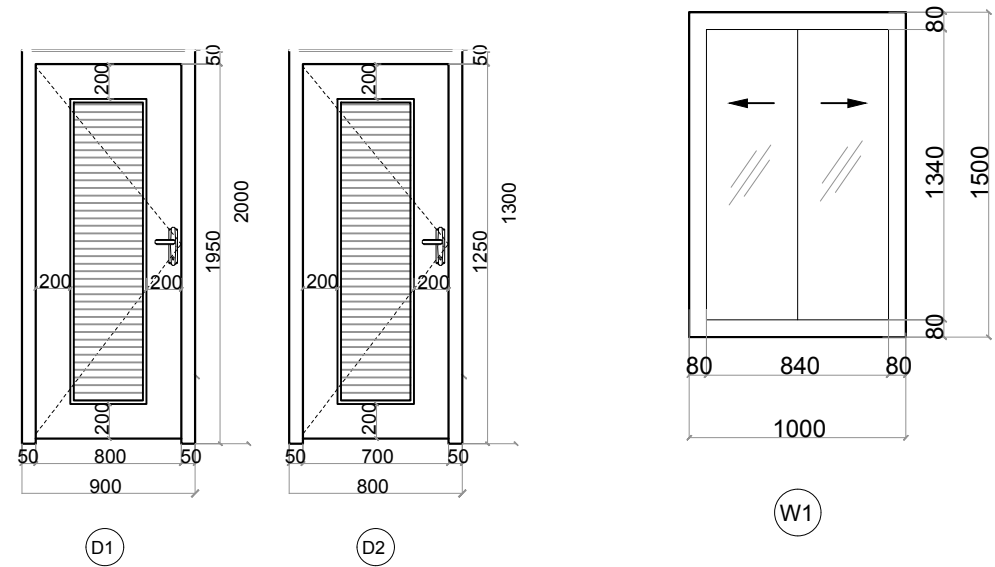



DOORS & WINDOW SCHEDULE					
TYPE	MATERIAL	NO.	HEIGHT (mm)	WIDTH (mm)	REMARKS
D1	METALLIC	2	2000	900	4MM GLASSES
D2	METALLIC	1	1300	800	4MM GLASSES
W1	METALLIC	1	1500	1000	4MM GLASSES

  DOORS & WINDOW DETAILS



 MEDECINS DU MONDE MDM	SURVEYED BY	MDM ENGINEER	CHECKED BY	MDM TEAM	SCALE		 SHEET NO.	PROVINCE	NIMROZ	PROJECT NAME: MAJOR REHABILITATION OF HEALTH CENTER	
	DESIGNED BY	MDM ENGINEER	REVIEWED BY	MDM TEAM	DATE	01-06-2026		DISTRICT	KHASH ROD	DRAWING TITLE:	
	DRAWN BY	MDM ENGINEER	APPROVED BY	MDM TEAM	DRAWING NO.			VILLAGE	MAZAD	C-10	

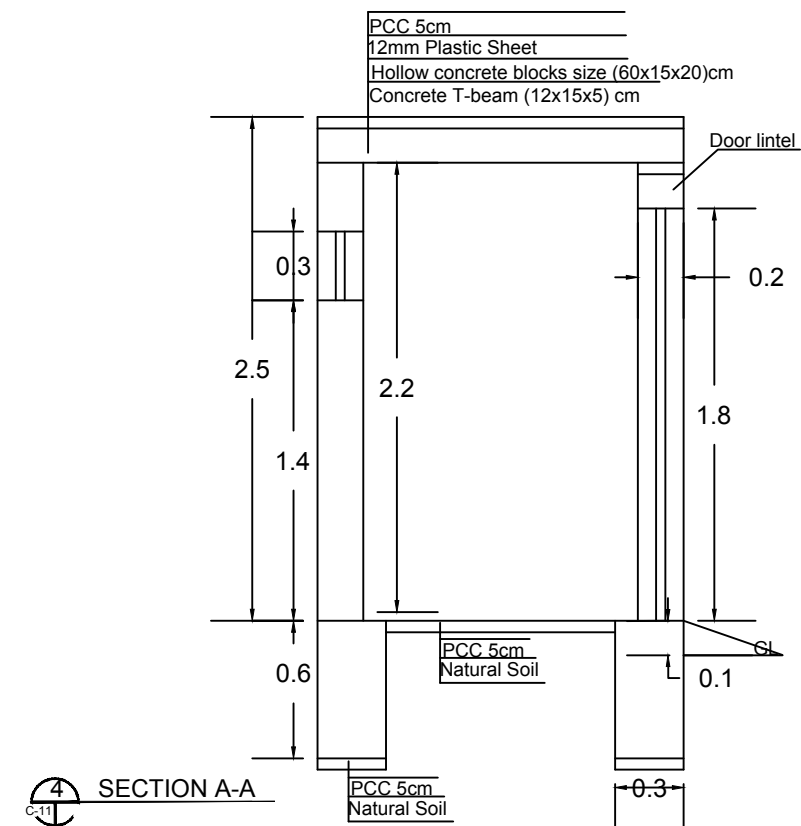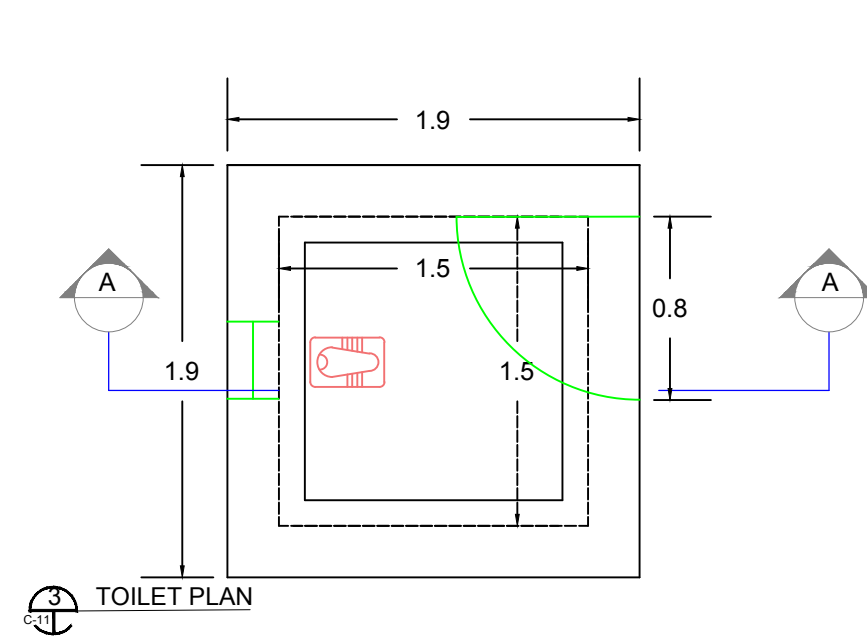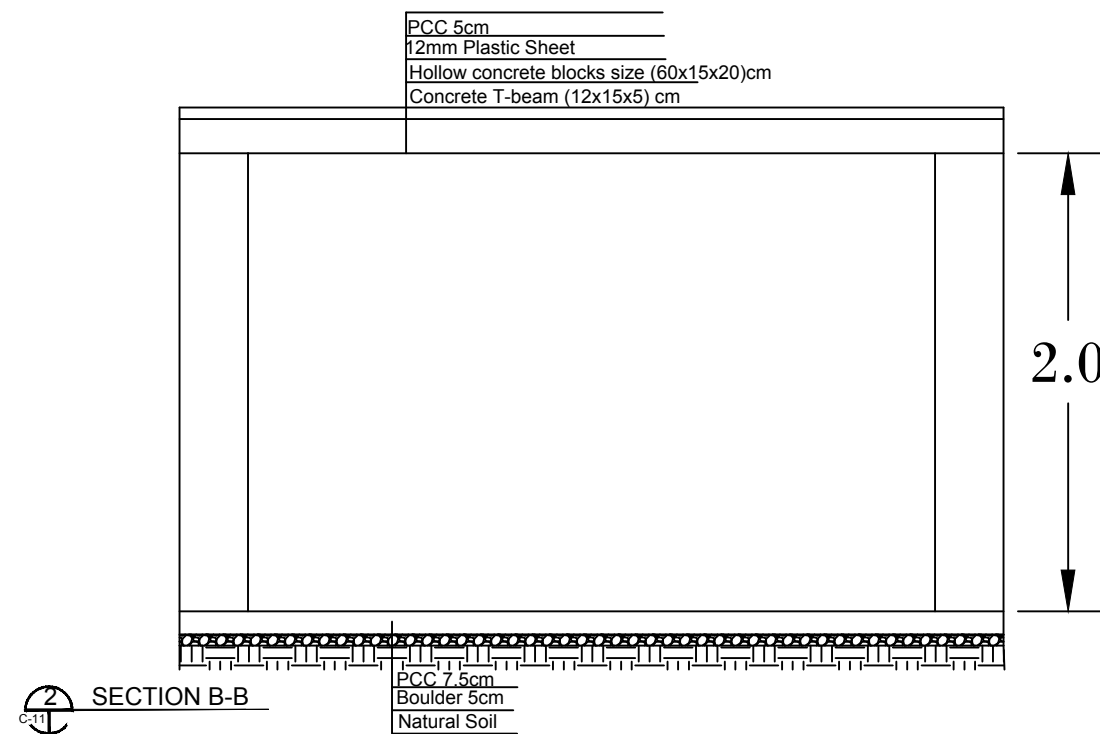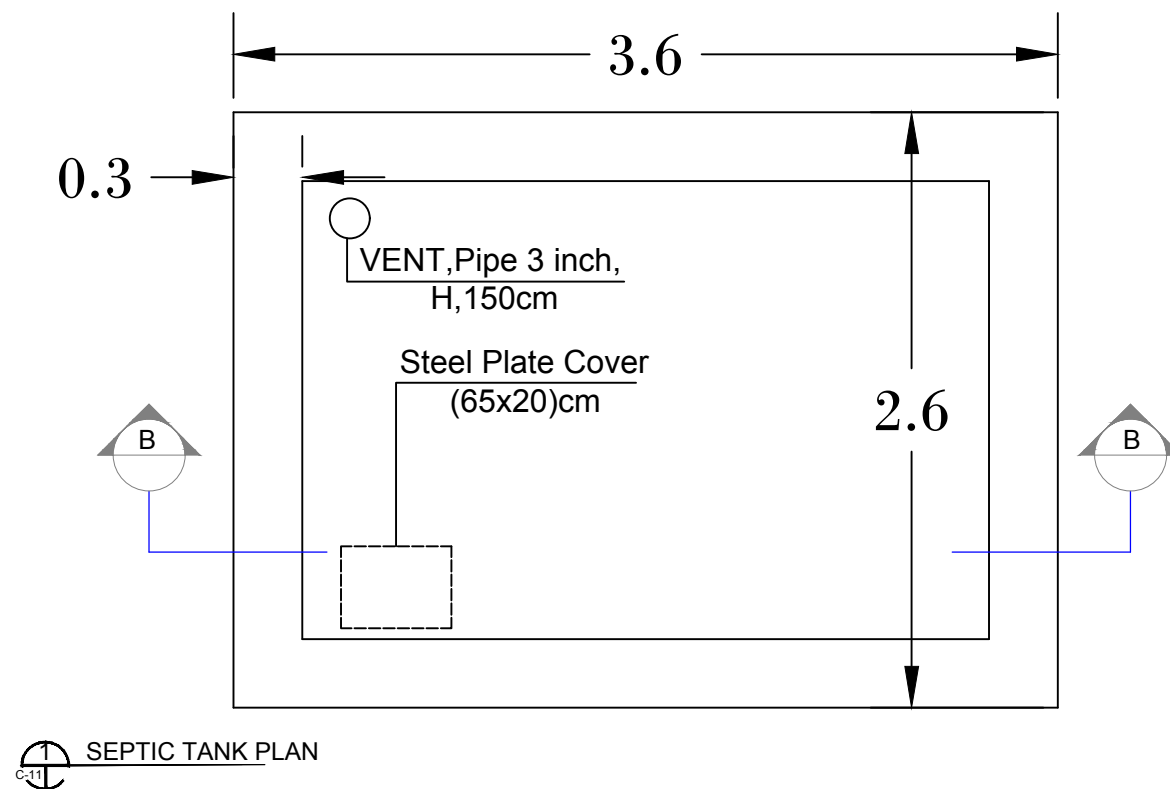



	SURVEYED BY	MDM ENGINEER	CHECKED BY	MDM TEAM	SCALE		SHEET NO. 11/13	PROVINCE	NIMROZ	PROJECT NAME: MAJOR REHABILITATION OF HEALTH CENTER
	DESIGNED BY	MDM ENGINEER	REVIEWED BY	MDM TEAM	DATE	01-06-2026		DISTRICT	KHASH ROD	
	DRAWN BY	MDM ENGINEER	APPROVED BY	MDM TEAM	DRAWING NO.			VILLAGE	MAZAD	DRAWING TITLE: C-11

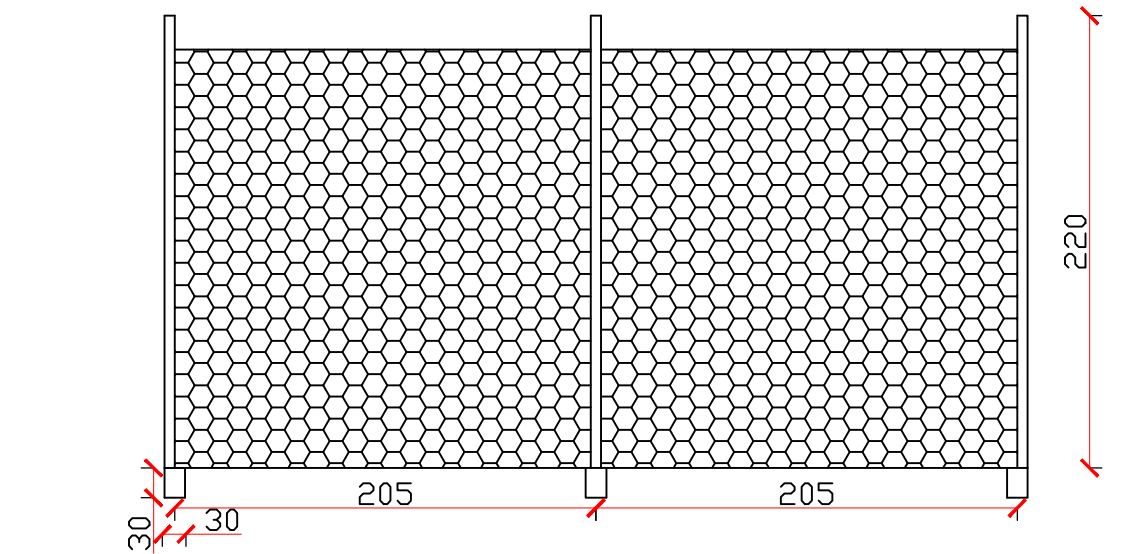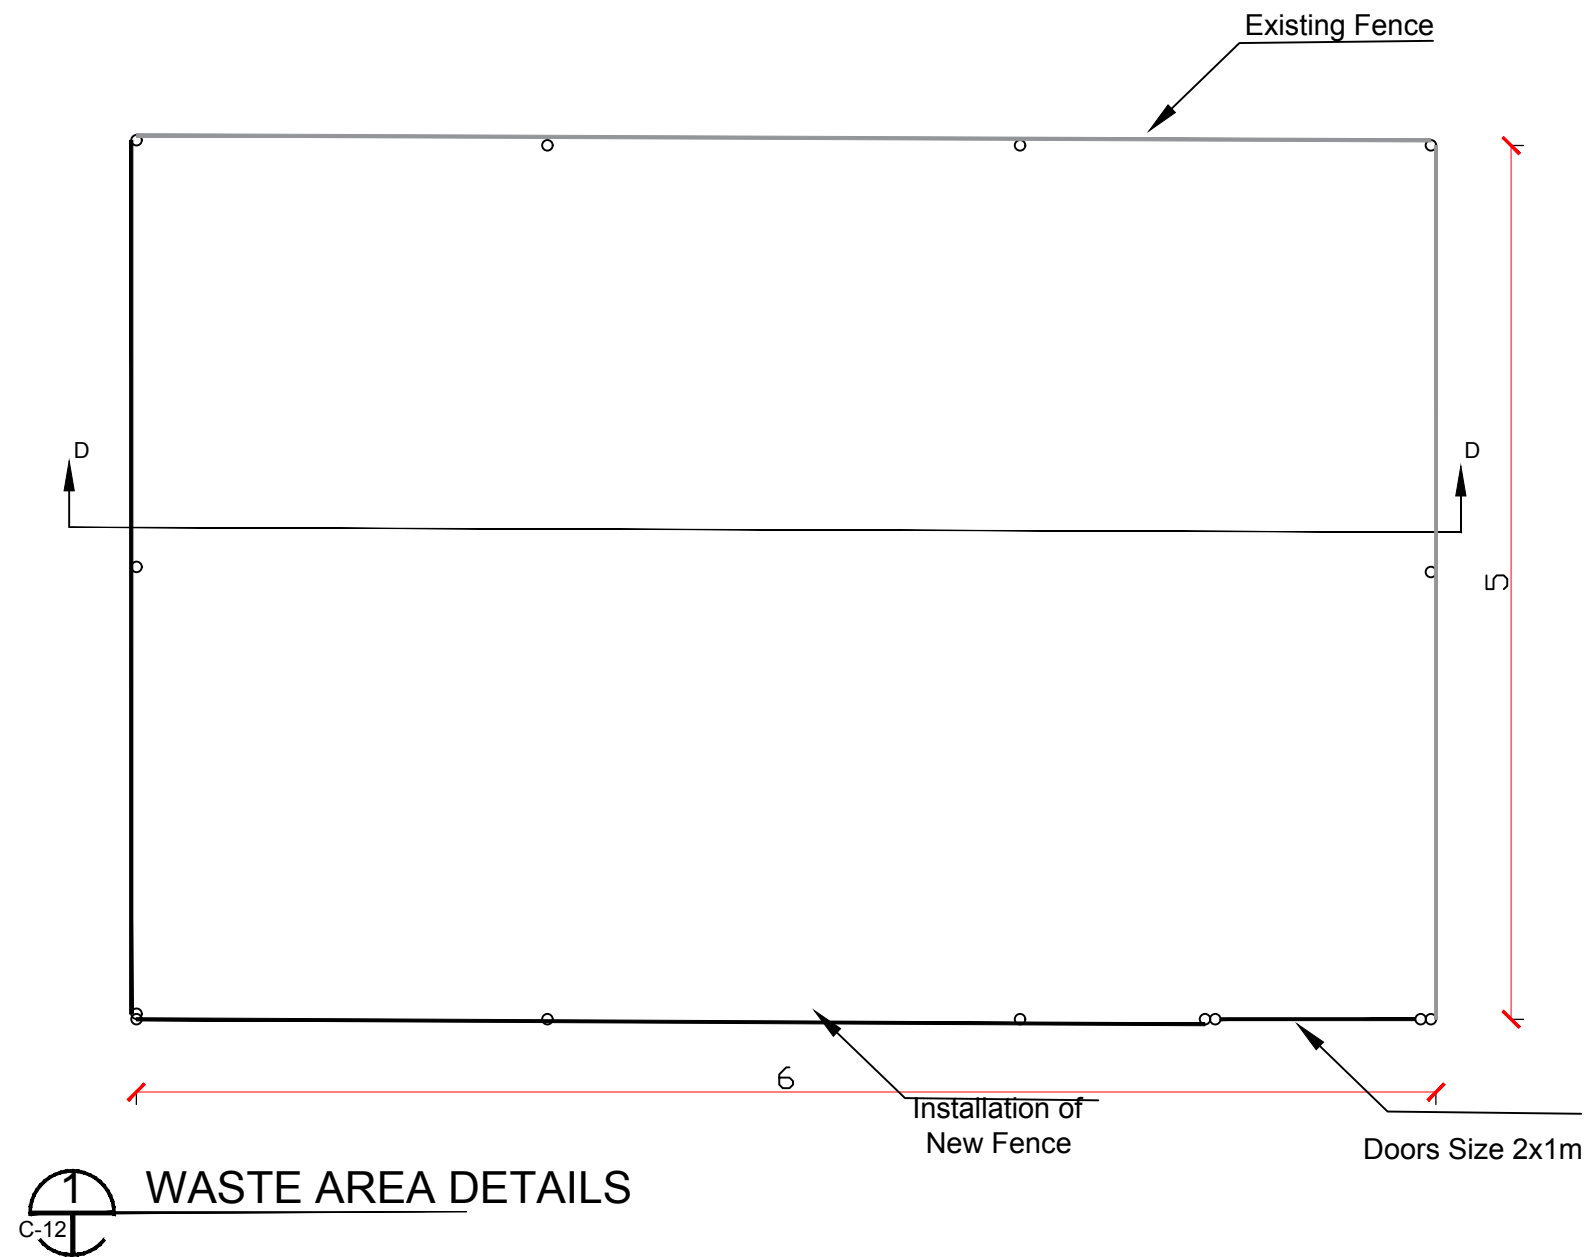


SECTION D-D

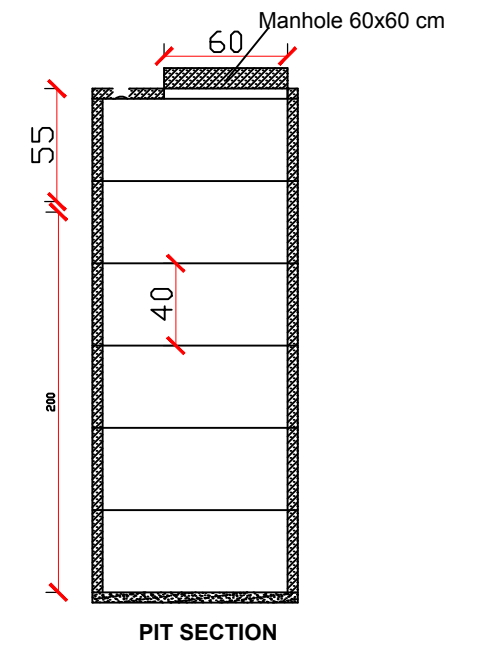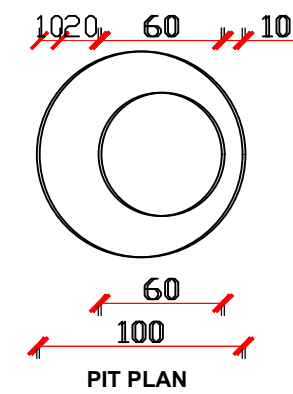

 
 MEDECINS DU MONDE MDM	SURVEYED BY	MDM ENGINEER	CHECKED BY	MDM TEAM	SCALE		SHEET NO. 	PROVINCE	NIMROZ	PROJECT NAME: MAJOR REHABILITATION OF HEALTH CENTER
	DESIGNED BY	MDM ENGINEER	REVIEWED BY	MDM TEAM	DATE	01-06-2026		DISTRICT	KHASH ROD	
	DRAWN BY	MDM ENGINEER	APPROVED BY	MDM TEAM	DRAWING NO.			VILLAGE	MAZAD	DRAWING TITLE: C-12

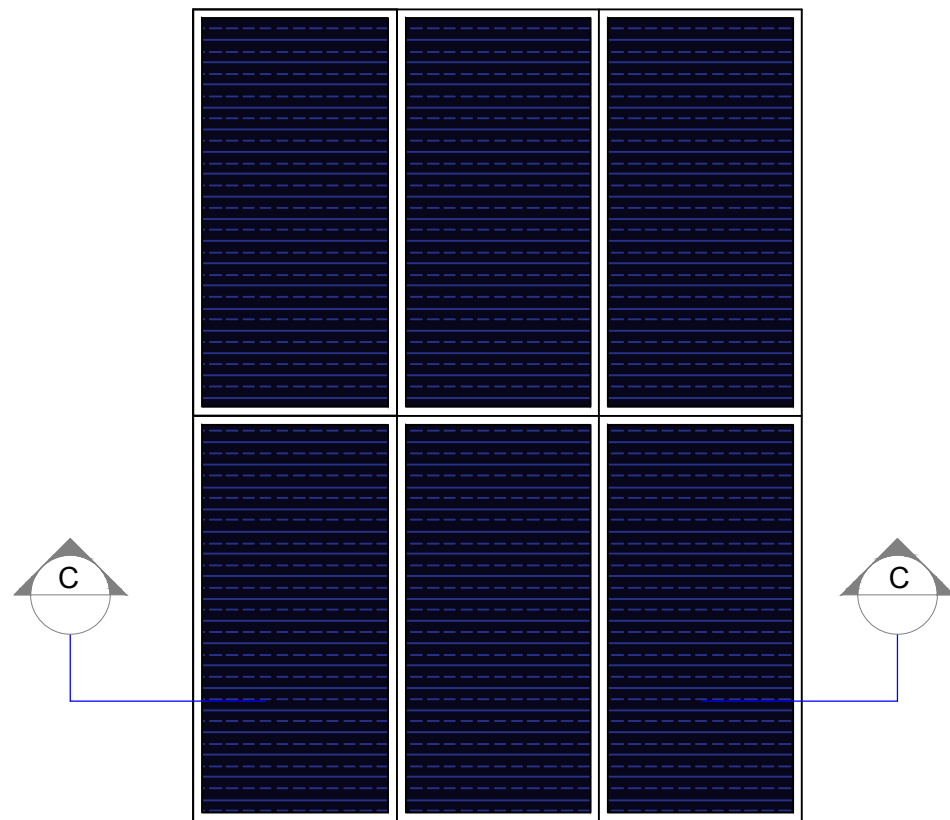

1 SOLAR PANEL
C-13

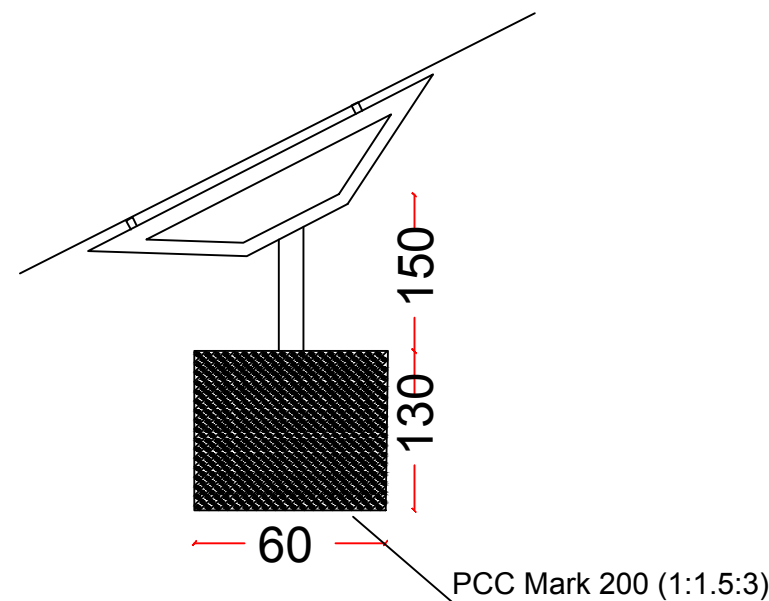

2 SECTION C-C
C-13

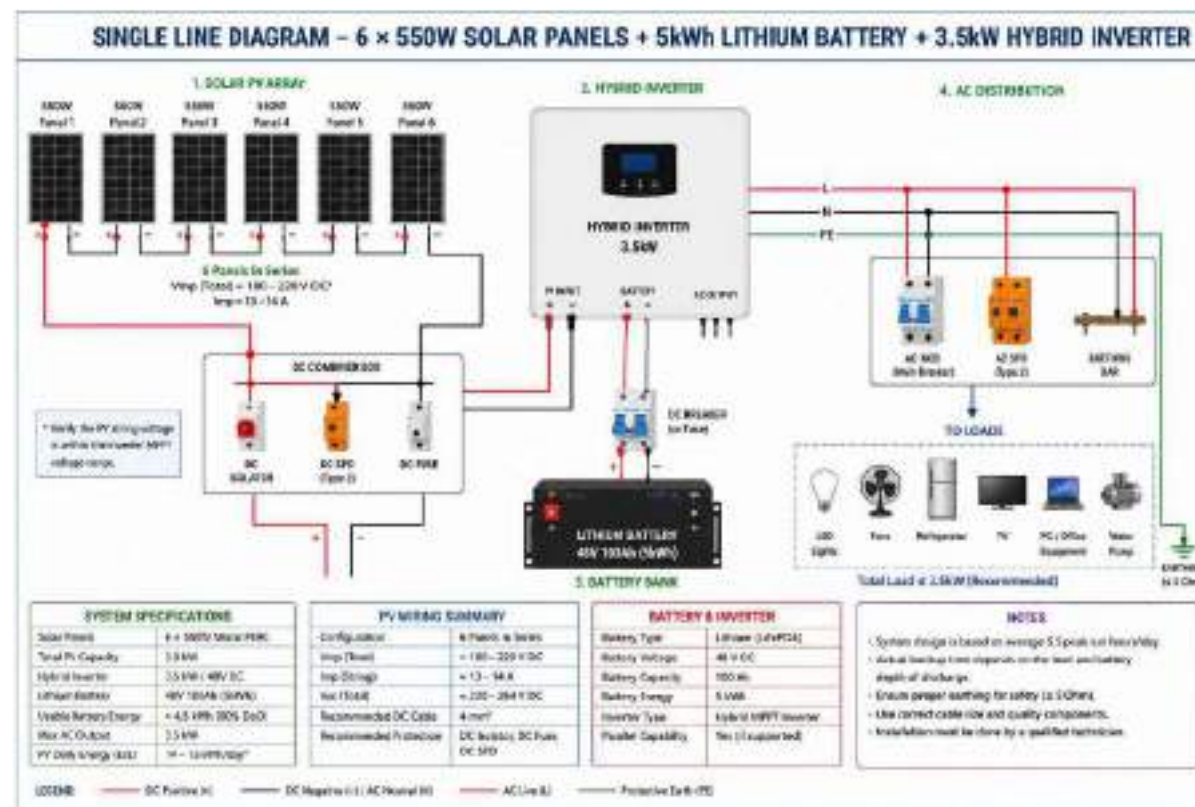

SOLAR PANEL INSTALLATION

 MEDECINS DU MONDE MDM	SURVEYED BY	MDM ENGINEER	CHECKED BY	MDM TEAM	SCALE		SHEET NO. 13/13	PROVINCE	NIMROZ	PROJECT NAME: MAJOR REHABILITATION OF HEALTH CENTER
	DESIGNED BY	MDM ENGINEER	REVIEWED BY	MDM TEAM	DATE	01-06-2026		DISTRICT	KHASH ROD	
	DRAWN BY	MDM ENGINEER	APPROVED BY	MDM TEAM	DRAWING NO.			VILLAGE	MAZAD	DRAWING TITLE: C-13