



**MEDECINS DU MONDE
MDM**


DESIGN DRAWINGS

REHABILITATION OF HEALTH FACILITIES PROJECTS IN AFGHANISTAN

Rehabilitation/Improvement of Health Facilities Infrastructure for Project at
Qala-e-Fath (FHH) Village, Dalaram District, Nimruz Province

PLAN AND SECTION

**Project Location
Nimruz Province**

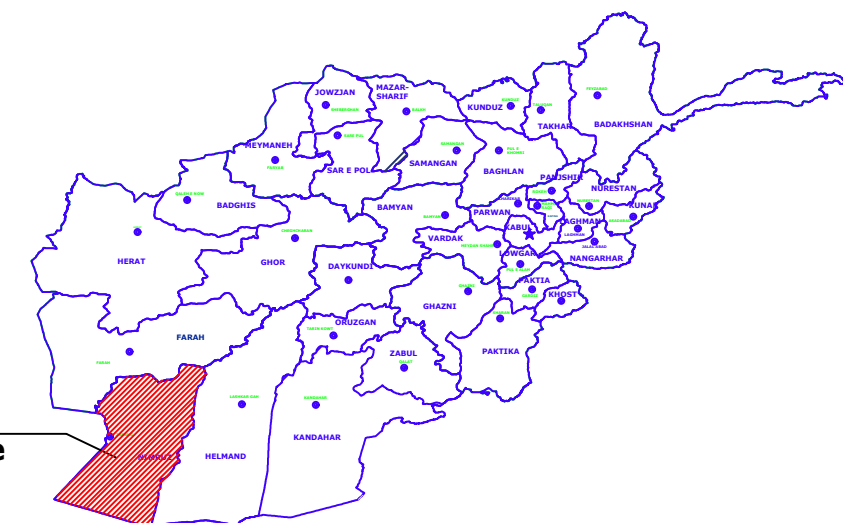

SUBMISSION DATE : - APR- 2026

Qala-e-Fath (FHH)-Dalaram District-Nimruz Province-GIS Plan



Legends

- Existing Boundary Wall
- Existing Rooms
- Existing Water Well
- Main Gate



Coordinate Details						
No	Location			N	E	Remark
1	Province	District	Village	3558436	525232	FHH
	Nimruz	Dalaram	Qala-e-Fath			


Rehabilitation of HSC Building in Qala-E-Fath, Dalaram District, Nimruz, Afghanistan		
Index Sheet		
SHEET REF. #	SHEET TITLE	DATE
	GENERAL	
	COVER SHEET	APR-26
C-01	PROJECT VICINITY AERIAL MAP & LOCATION MAP	APR-26
C-02	INDEX SHEET	APR-26
C-03	EXISTING SITE PLAN	APR-26
C-04	DETAIL UPGRADE PLAN	APR-26
C-05	SIDE WALK PLAN	APR-26
C-06	WATER SUPPLY PLAN	APR-26
C-07	SEWER PLAN	APR-26
C-08	POWER PLAN	APR-26
C-09	SEPTIC TANK AND TOILET DETAILS	APR-26
C-10	SOLAR PANELS INSTALLATION DETAILS	APR-26
C-11	MID WIFE ROOM DETAILS	APR-26
C-12	WAITING AREA	
C-13	WASTE AREA DETAILS	APR-26

1

C-02

INDEX SHEET

 MEDECINS DU MONDE MDM	SURVEYED BY	MDM ENGINEER	CHECKED BY	MDM TEAM	SCALE		SHEET NO. 02 13	PROVINCE	NIMROZ	PROJECT NAME: MAJOR REHABILITATION OF HEALTH CENTER
	DESIGNED BY	MDM ENGINEER	REVIEWED BY	MDM TEAM	DATE	01-06-2026		DISTRICT	DALARAM	
	DRAWN BY	MDM ENGINEER	APPROVED BY	MDM TEAM	DRAWING NO.			VILLAGE	QALA-E-FATH	DRAWING TITLE: C-02

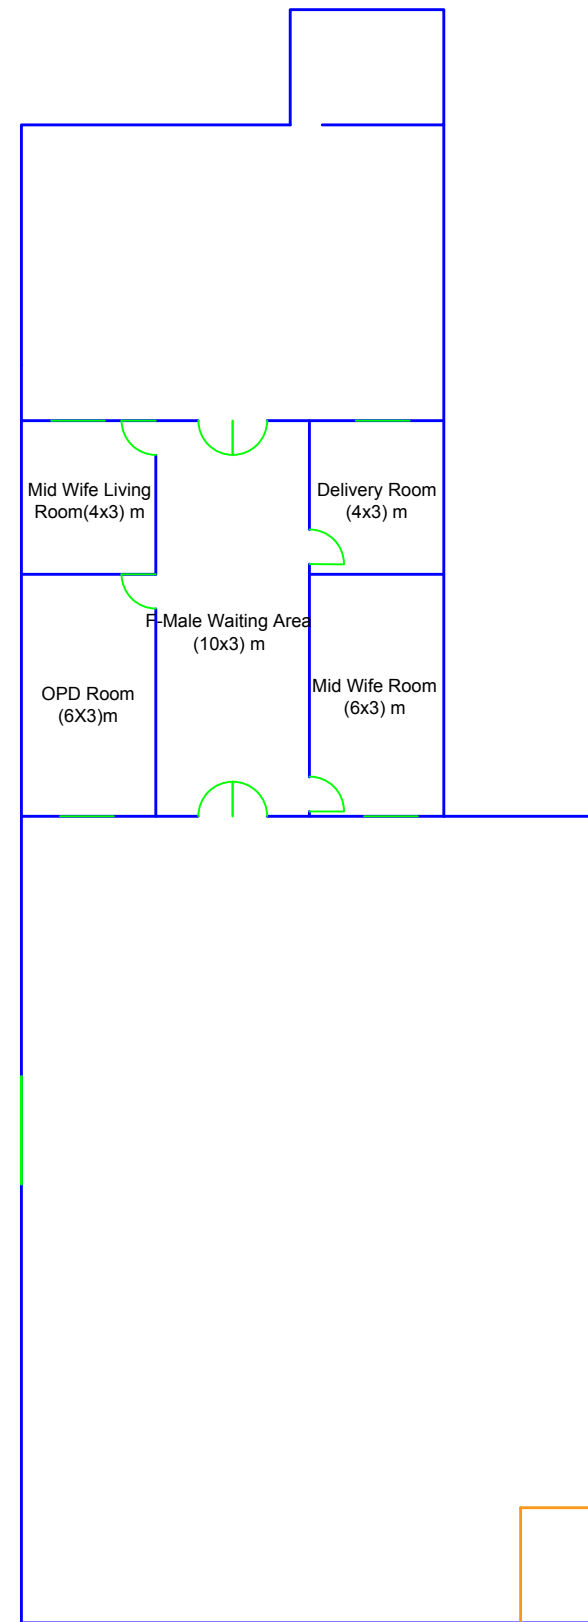


Legends

- Existing Boundary Wall
- Existing Rooms
- Existing Water Point
- Main Gate
- Existing M-Toilet

1 EXISTING SITE PLAN
C-03

 MEDECINS DU MONDE MDM	SURVEYED BY	MDM ENGINEER	CHECKED BY	MDM TEAM	SCALE		SHEET NO. 	PROVINCE	NIMROZ	PROJECT NAME: MAJOR REHABILITATION OF HEALTH CENTER	
	DESIGNED BY	MDM ENGINEER	REVIEWED BY	MDM TEAM	DATE	01-06-2026		DISTRICT	DALARAM	DRAWING TITLE:	
	DRAWN BY	MDM ENGINEER	APPROVED BY	MDM TEAM	DRAWING NO.			VILLAGE	QALA-E-FATH	C-03	

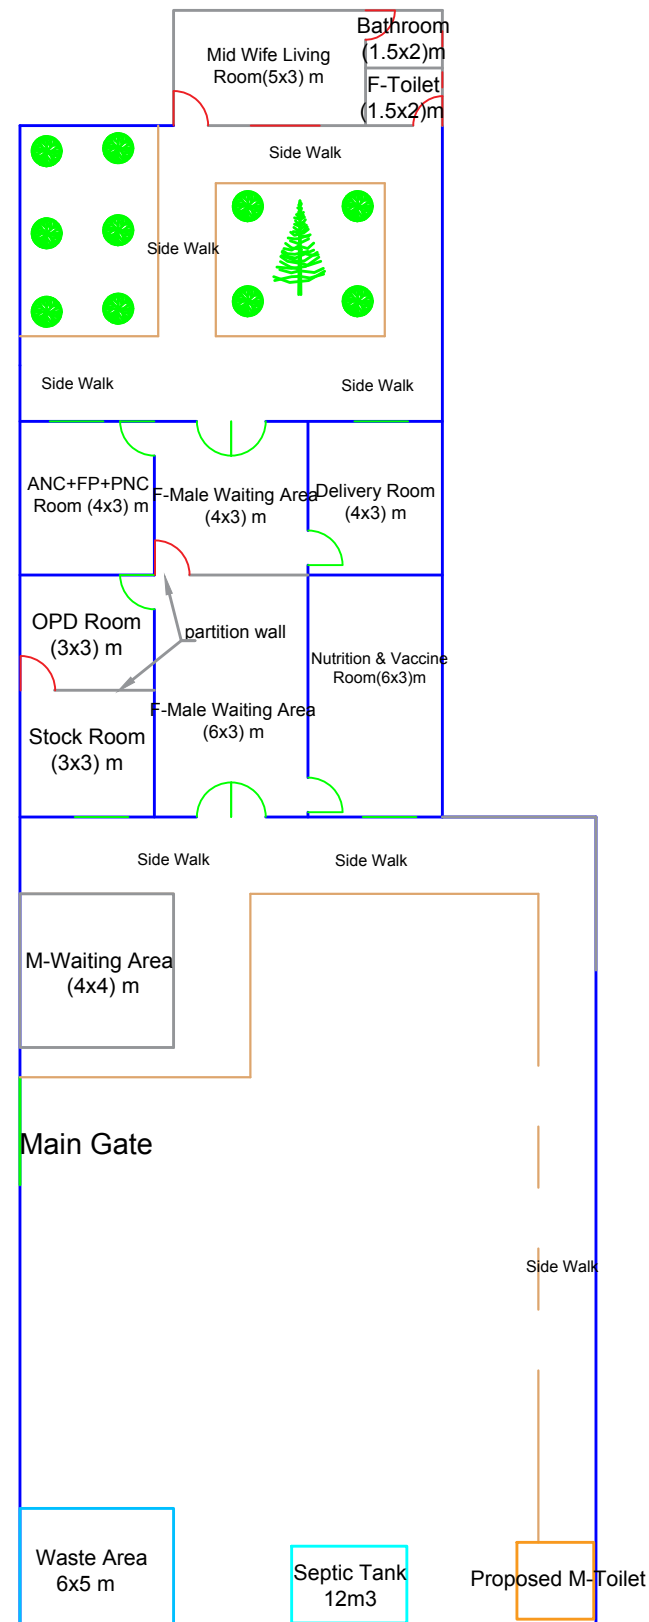



Legends

- Existing Boundary Wall
- Existing Water Well
- Main Gate
- Proposed Waste Area
- Proposed New Rooms
- Proposed M-Toilet
- Proposed F-Toilet
- Proposed Septic Tank

Door and Window Table		
No	Items	Symbol
1	Existing D&W	
2	Proposed new D&W	

 
UPGRADE SITE PLAN


 MEDECINS DU MONDE MDM	SURVEYED BY	MDM ENGINEER	CHECKED BY	MDM TEAM	SCALE		SHEET NO. 	PROVINCE	NIMROZ	PROJECT NAME: MAJOR REHABILITATION OF HEALTH CENTER	
	DESIGNED BY	MDM ENGINEER	REVIEWED BY	MDM TEAM	DATE	01-06-2026		DISTRICT	DALARAM	DRAWING TITLE: C-04	
	DRAWN BY	MDM ENGINEER	APPROVED BY	MDM TEAM	DRAWING NO.			VILLAGE	QALA-E-FATH		

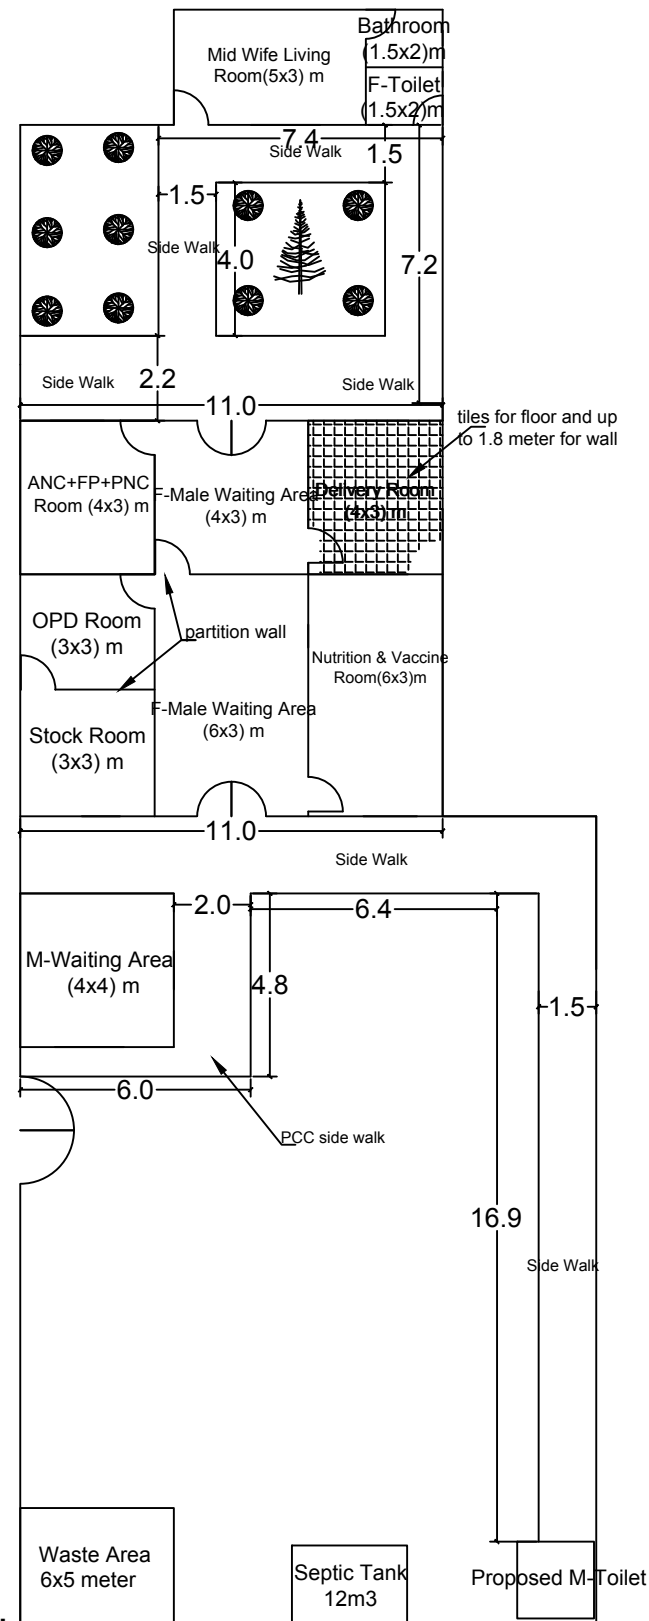

1
C-05

 
SIDE WALK PLAN

 MEDECINS DU MONDE MDM	SURVEYED BY	MDM ENGINEER	CHECKED BY	MDM TEAM	SCALE		SHEET NO. 	PROVINCE	NIMROZ	PROJECT NAME: MAJOR REHABILITATION OF HEALTH CENTER
	DESIGNED BY	MDM ENGINEER	REVIEWED BY	MDM TEAM	DATE	01-06-2026		DISTRICT	DALARAM	
	DRAWN BY	MDM ENGINEER	APPROVED BY	MDM TEAM	DRAWING NO.			VILLAGE	QALA-E-FATH	DRAWING TITLE: C-05

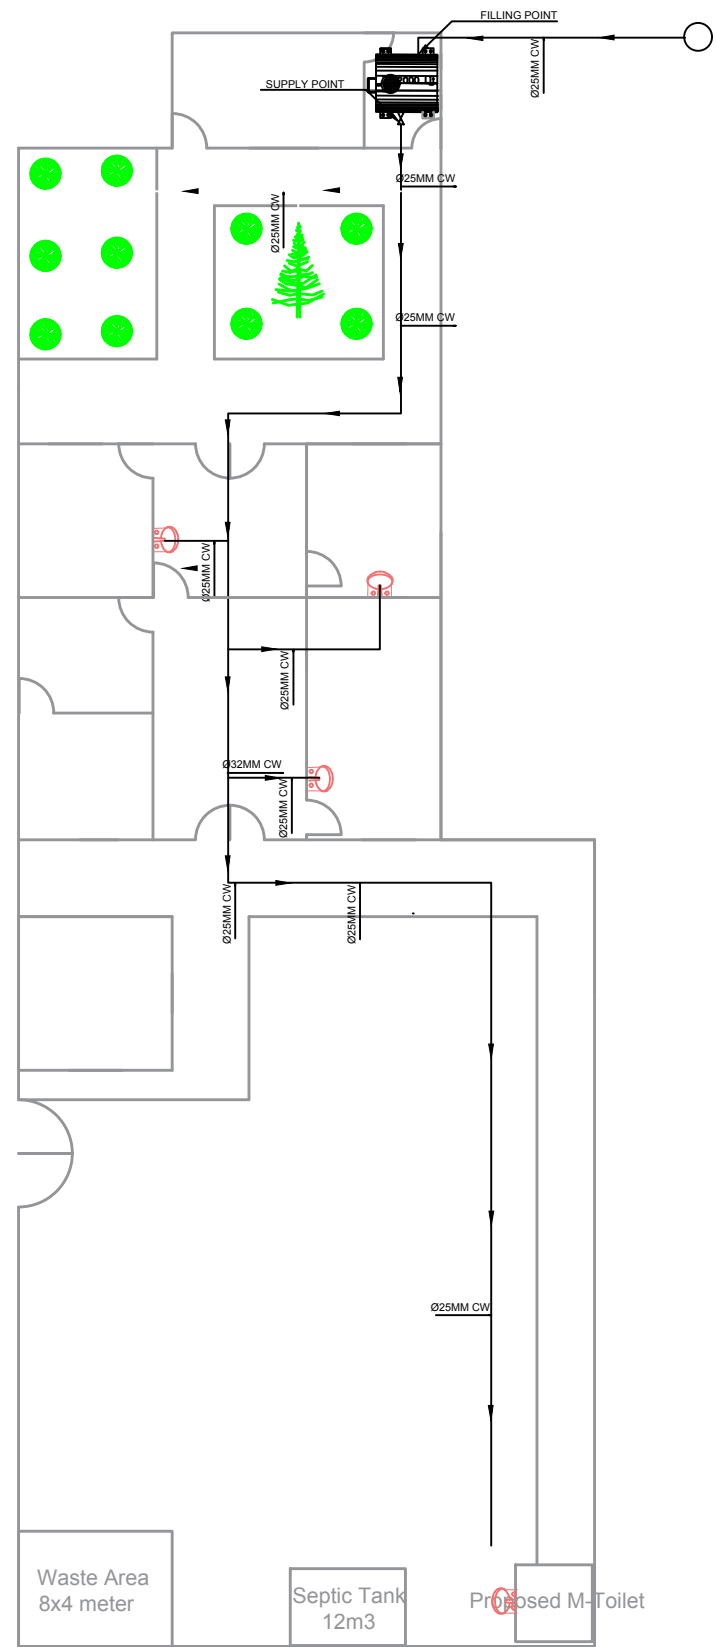

 WATER SUPPLY PLAN


 MEDECINS DU MONDE MDM	SURVEYED BY	MDM ENGINEER	CHECKED BY	MDM TEAM	SCALE		SHEET NO. 06/13	PROVINCE	NIMROZ	PROJECT NAME: MAJOR REHABILITATION OF HEALTH CENTER
	DESIGNED BY	MDM ENGINEER	REVIEWED BY	MDM TEAM	DATE	01-06-2026		DISTRICT	DALARAM	
	DRAWN BY	MDM ENGINEER	APPROVED BY	MDM TEAM	DRAWING NO.			VILLAGE	QALA-E-FATH	DRAWING TITLE: C-06

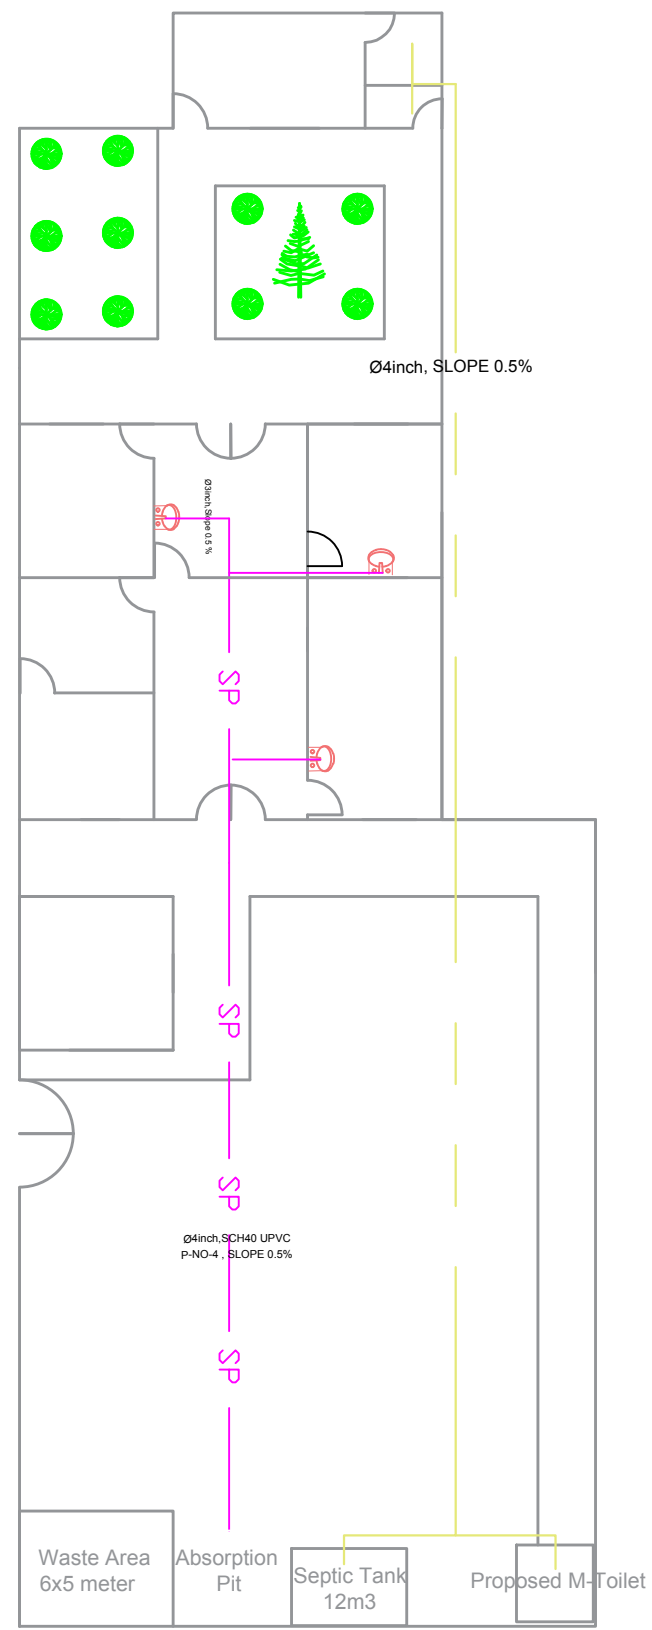

1
C-07


SEWER PLAN

 MEDECINS DU MONDE MDM	SURVEYED BY	MDM ENGINEER	CHECKED BY	MDM TEAM	SCALE		SHEET NO. 07 13	PROVINCE	NIMROZ	PROJECT NAME: MAJOR REHABILITATION OF HEALTH CENTER	
	DESIGNED BY	MDM ENGINEER	REVIEWED BY	MDM TEAM	DATE	01-06-2026		DISTRICT	DALARAM	DRAWING TITLE:	
	DRAWN BY	MDM ENGINEER	APPROVED BY	MDM TEAM	DRAWING NO.			VILLAGE	QALA-E-FATH	C-07	

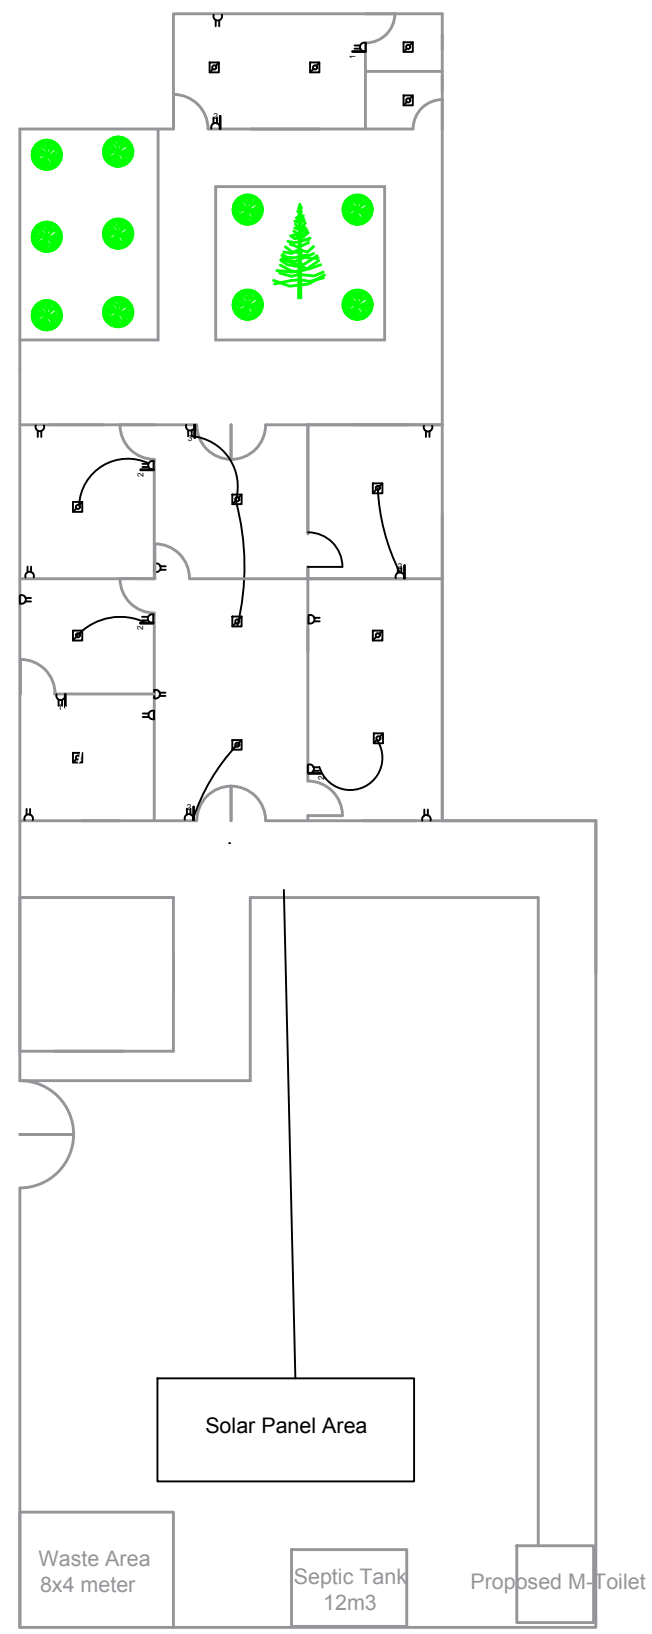


1 POWER PLAN
C-08


 MEDECINS DU MONDE MDM	SURVEYED BY	MDM ENGINEER	CHECKED BY	MDM TEAM	SCALE		SHEET NO. 08/13	PROVINCE	NIMROZ	PROJECT NAME: MAJOR REHABILITATION OF HEALTH CENTER	
	DESIGNED BY	MDM ENGINEER	REVIEWED BY	MDM TEAM	DATE	01-06-2026		DISTRICT	DALARAM	DRAWING TITLE:	
	DRAWN BY	MDM ENGINEER	APPROVED BY	MDM TEAM	DRAWING NO.			VILLAGE	QALA-E-FATH	C-08	

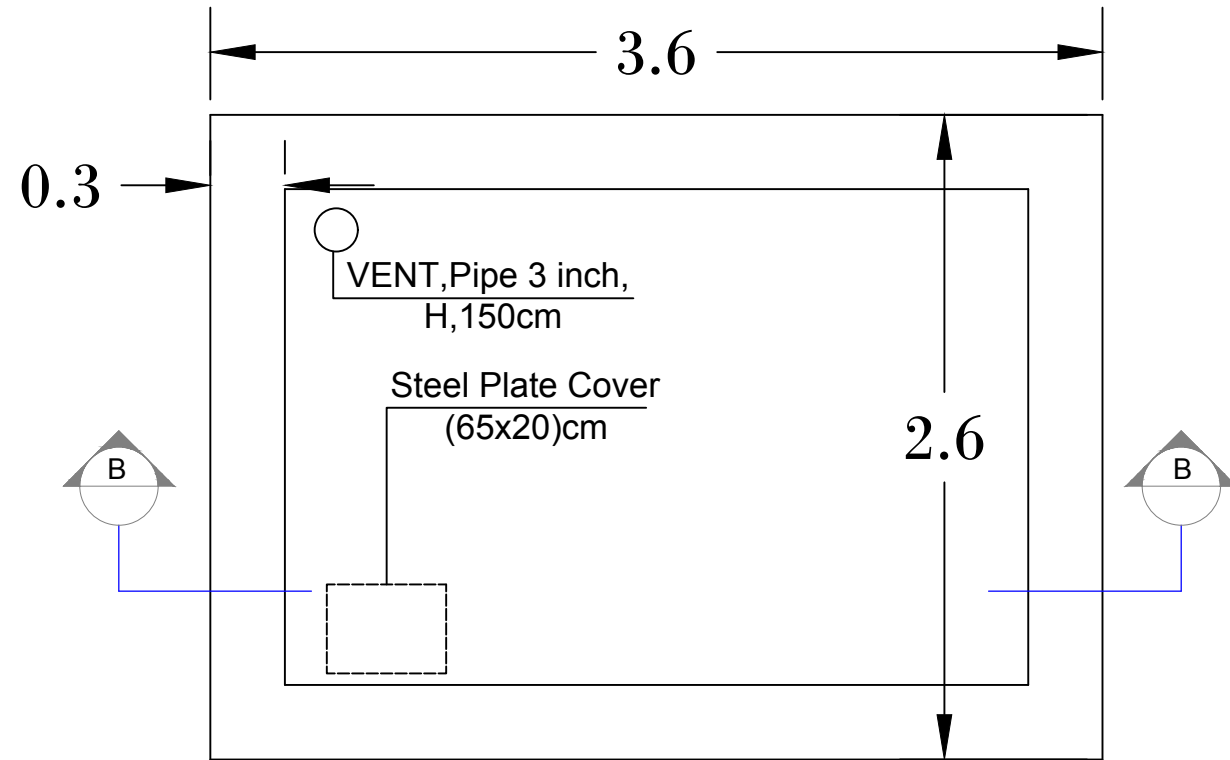


1 SEPTIC TANK PLAN

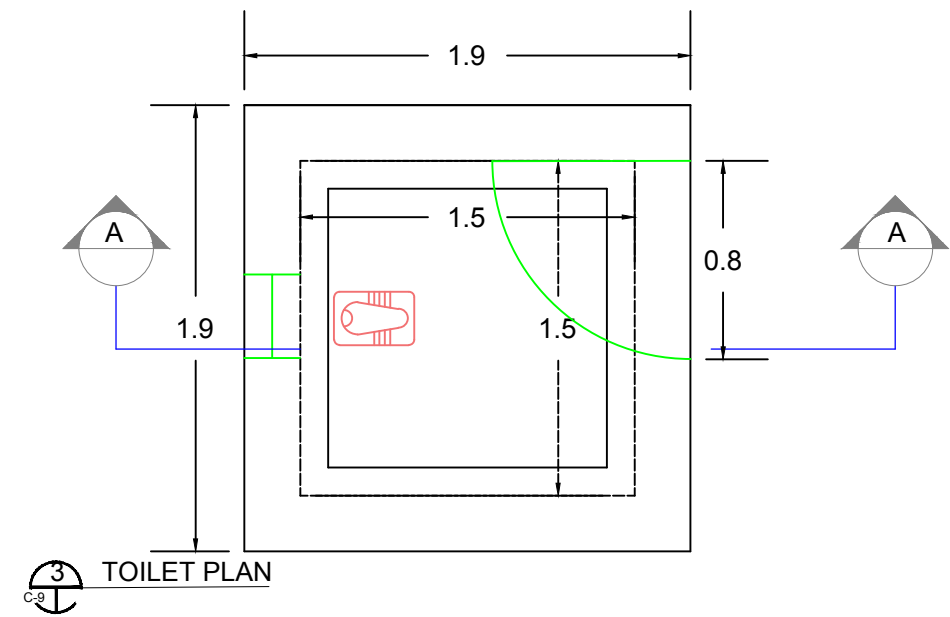

3 TOILET PLAN

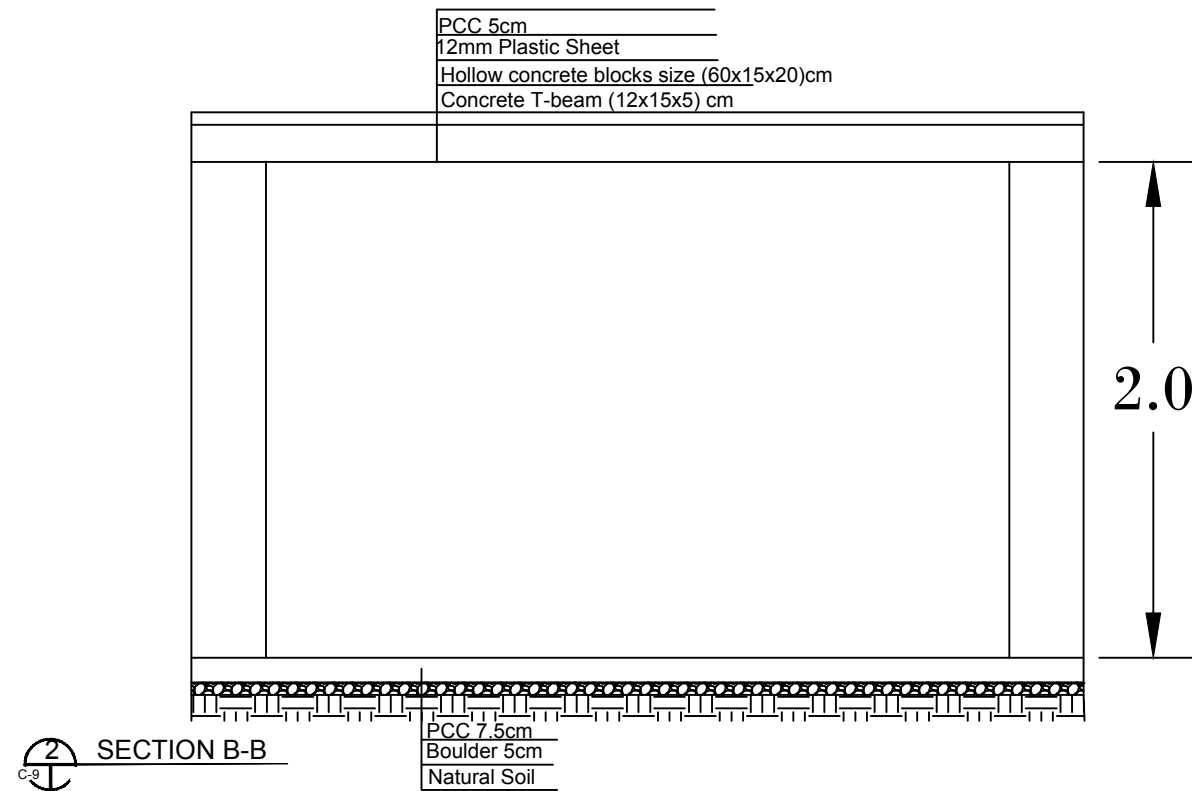


2 SECTION B-B

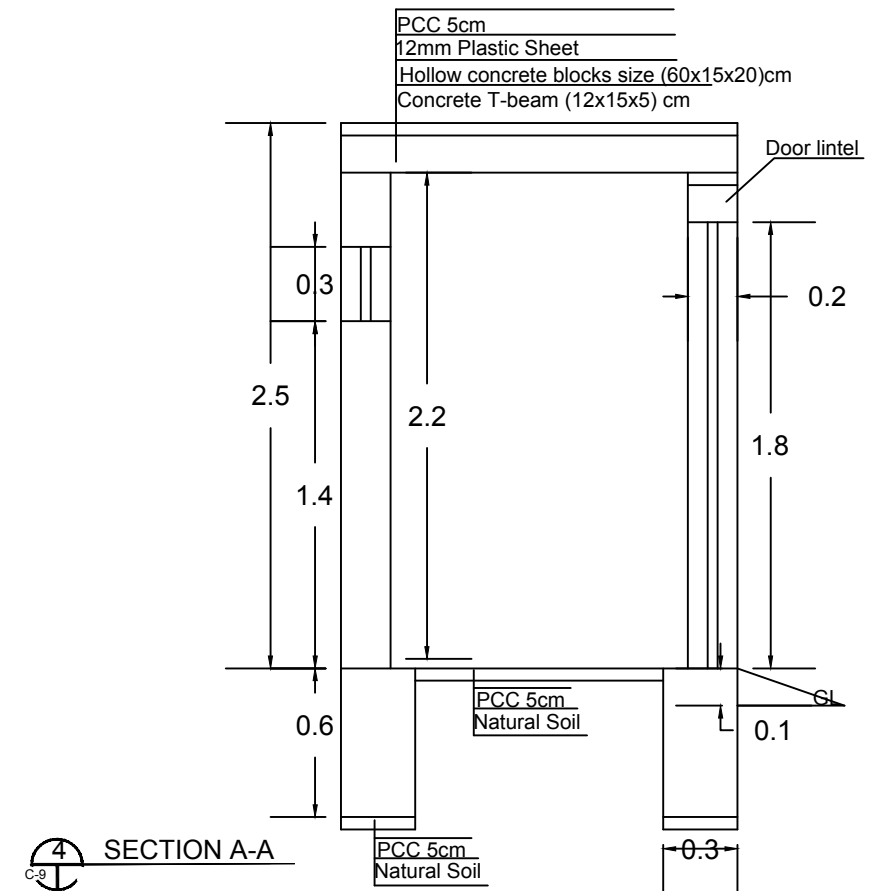



4 SECTION A-A

 MEDECINS DU MONDE MDM	SURVEYED BY	MDM ENGINEER	CHECKED BY	MDM TEAM	SCALE		SHEET NO. 09/13	PROVINCE	NIMROZ	PROJECT NAME: MAJOR REHABILITATION OF HEALTH CENTER
	DESIGNED BY	MDM ENGINEER	REVIEWED BY	MDM TEAM	DATE	01-06-2026		DISTRICT	DALARAM	
	DRAWN BY	MDM ENGINEER	APPROVED BY	MDM TEAM	DRAWING NO.			VILLAGE	QALA-E-FATH	DRAWING TITLE: C-09

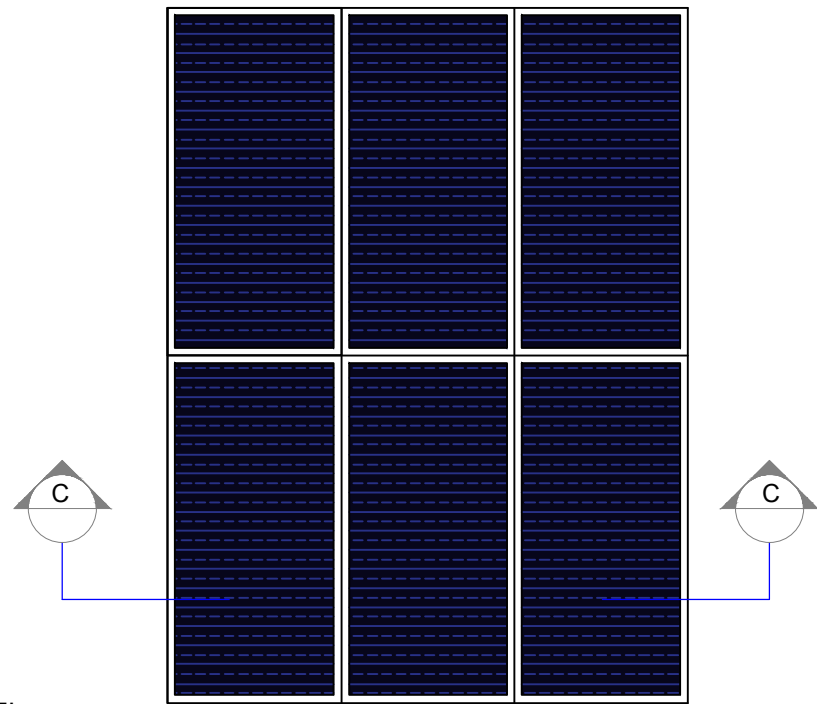


1 SOLAR PANEL
C-10

2 SECTION C-C
C-10

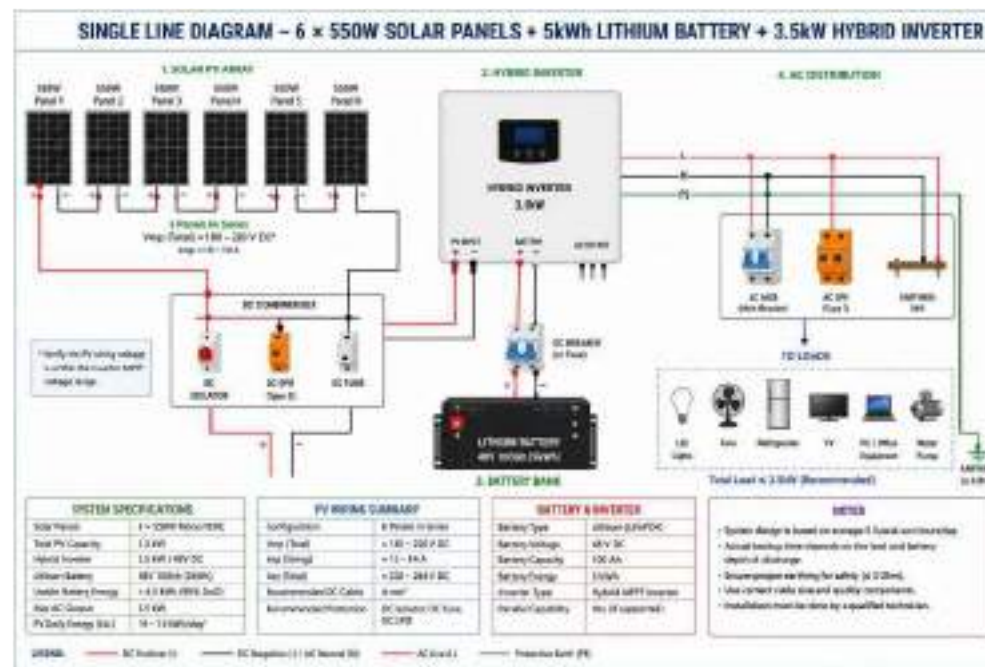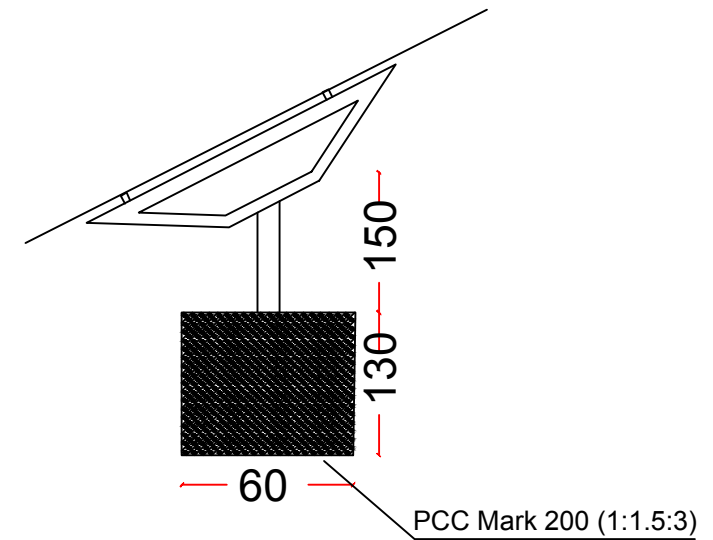


3 SOLAR PANEL INSTALLATION


 MEDECINS DU MONDE MDM	SURVEYED BY	MDM ENGINEER	CHECKED BY	MDM TEAM	SCALE		SHEET NO. 10/13	PROVINCE	NIMROZ	PROJECT NAME: MAJOR REHABILITATION OF HEALTH CENTER
	DESIGNED BY	MDM ENGINEER	REVIEWED BY	MDM TEAM	DATE	01-06-2026		DISTRICT	DALARAM	
	DRAWN BY	MDM ENGINEER	APPROVED BY	MDM TEAM	DRAWING NO.			VILLAGE	QALA-E-FATH	DRAWING TITLE: C-10

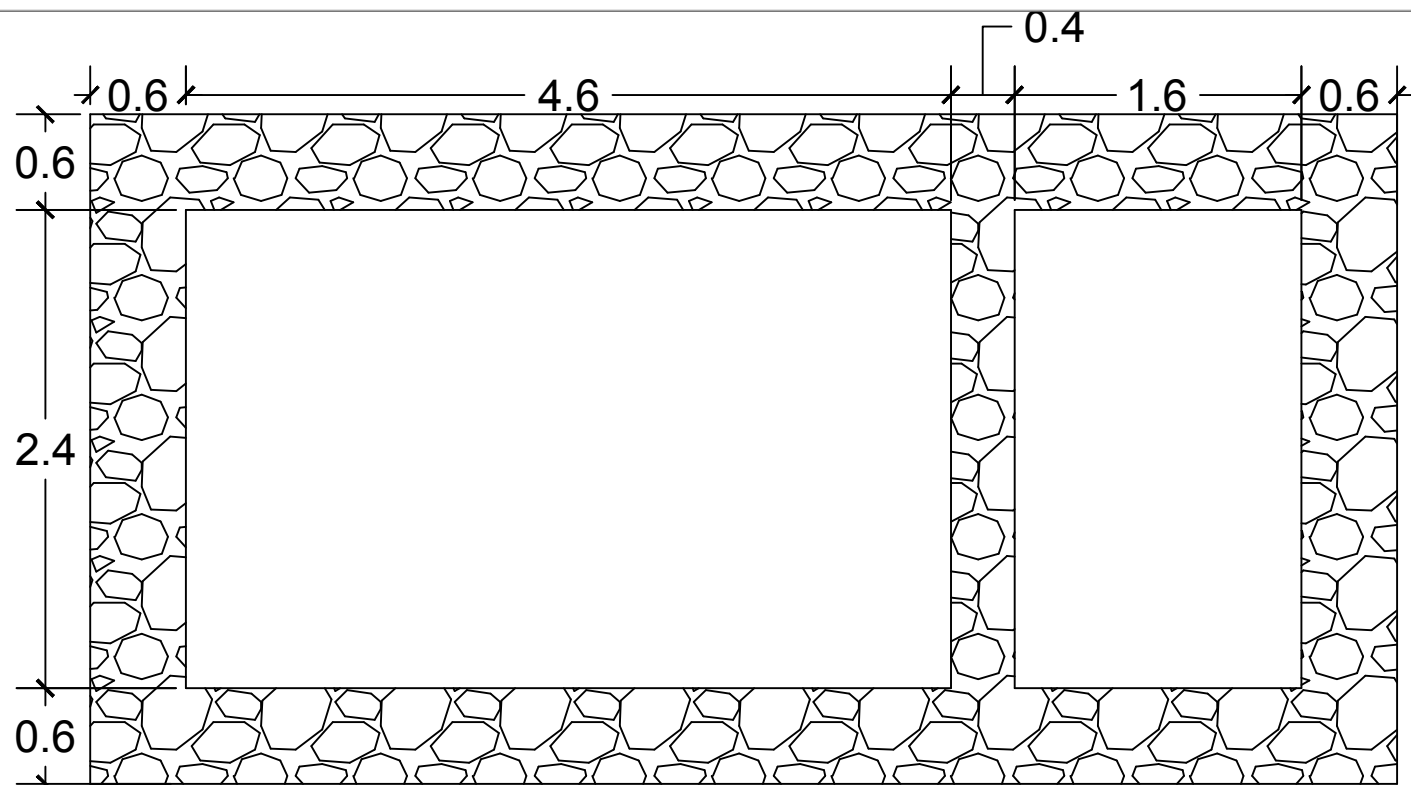


FOUNDATION PLAN

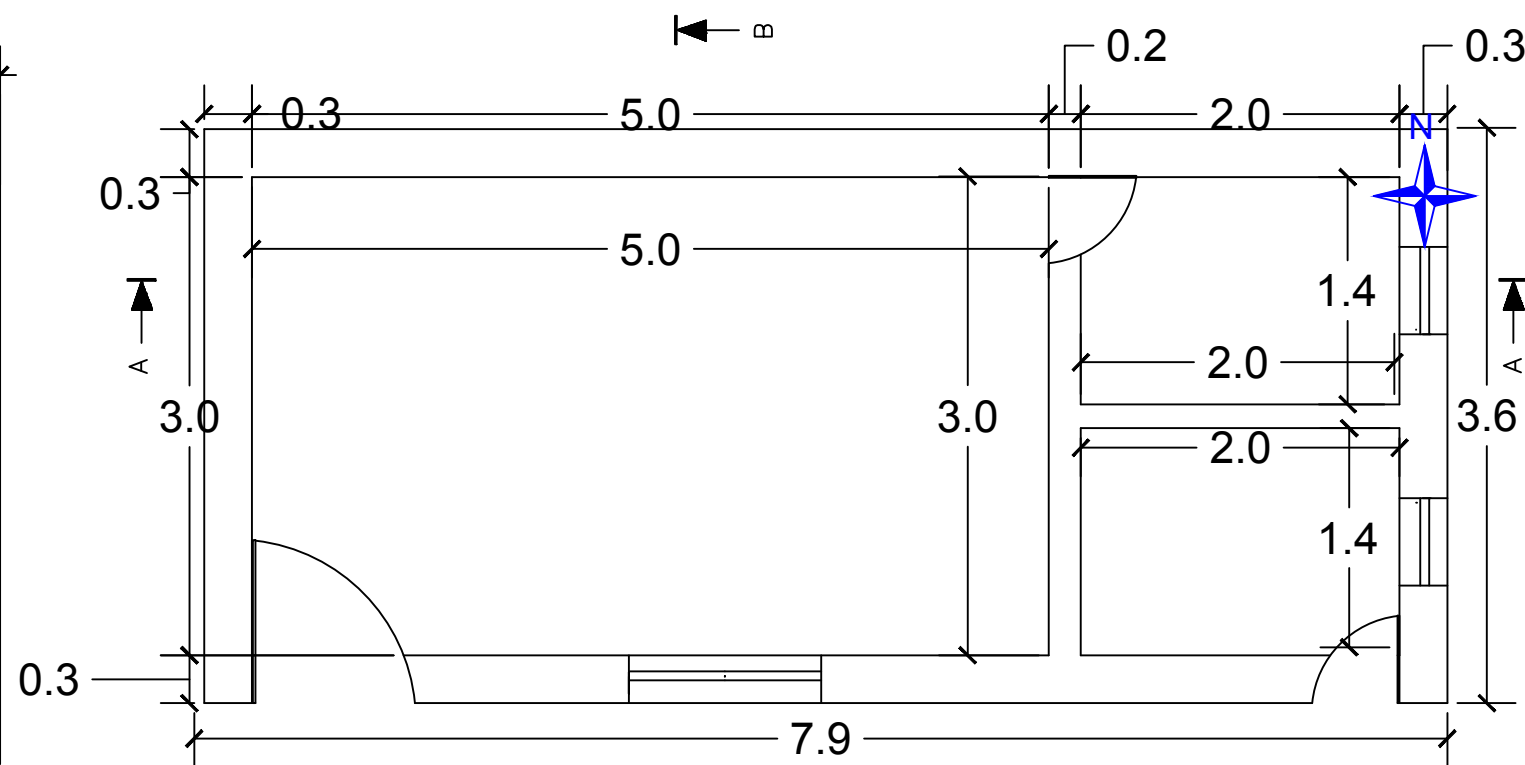

PLAN

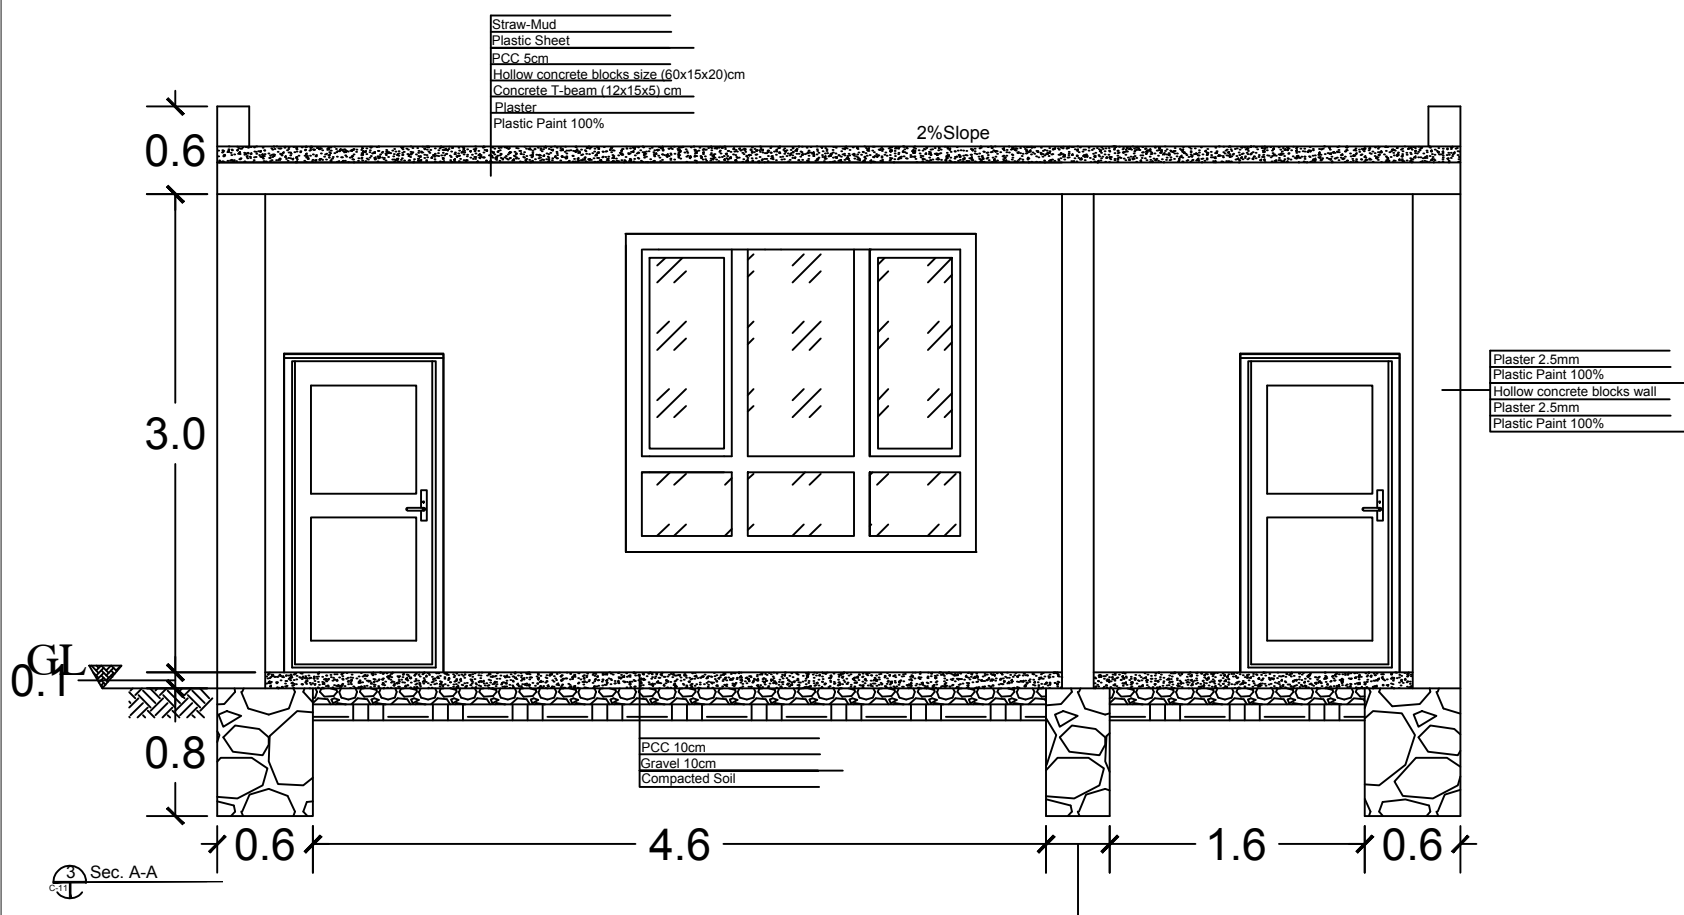






Sec. A-A

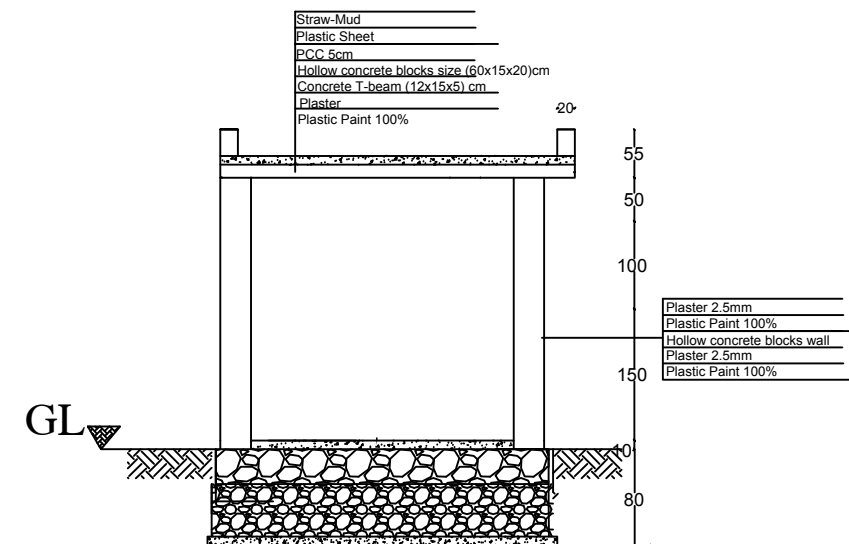




Sec. B-B

 
Note:
All units are [cm] unless otherwise presented.

	SURVEYED BY	MDM ENGINEER	CHECKED BY	MDM TEAM	SCALE		SHEET NO. 	PROVINCE	NIMROZ	PROJECT NAME: MAJOR REHABILITATION OF HEALTH CENTER
	DESIGNED BY	MDM ENGINEER	REVIEWED BY	MDM TEAM	DATE	01-06-2026		DISTRICT	DALARAM	
	DRAWN BY	MDM ENGINEER	APPROVED BY	MDM TEAM	DRAWING NO.			VILLAGE	QALA-E-FATH	DRAWING TITLE: C-11

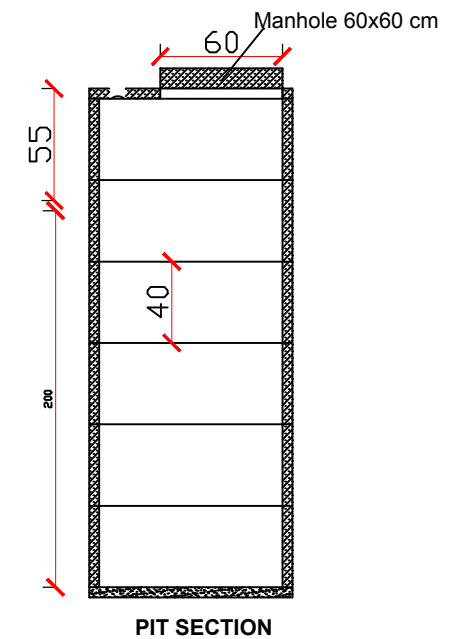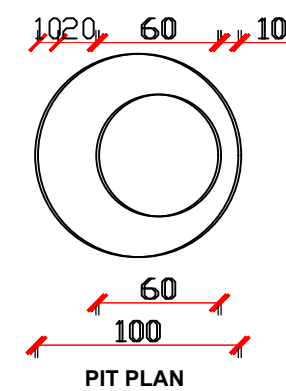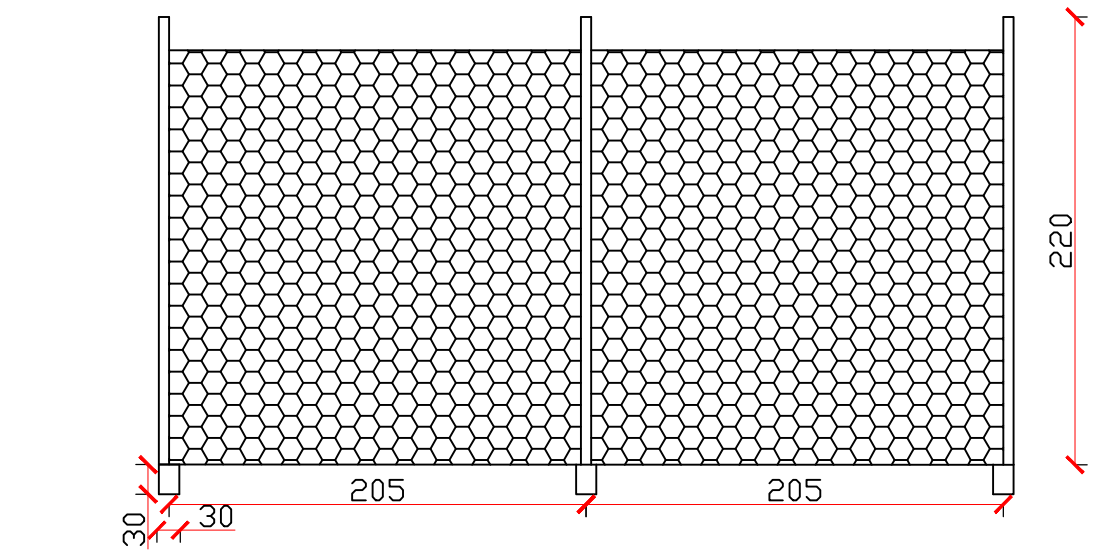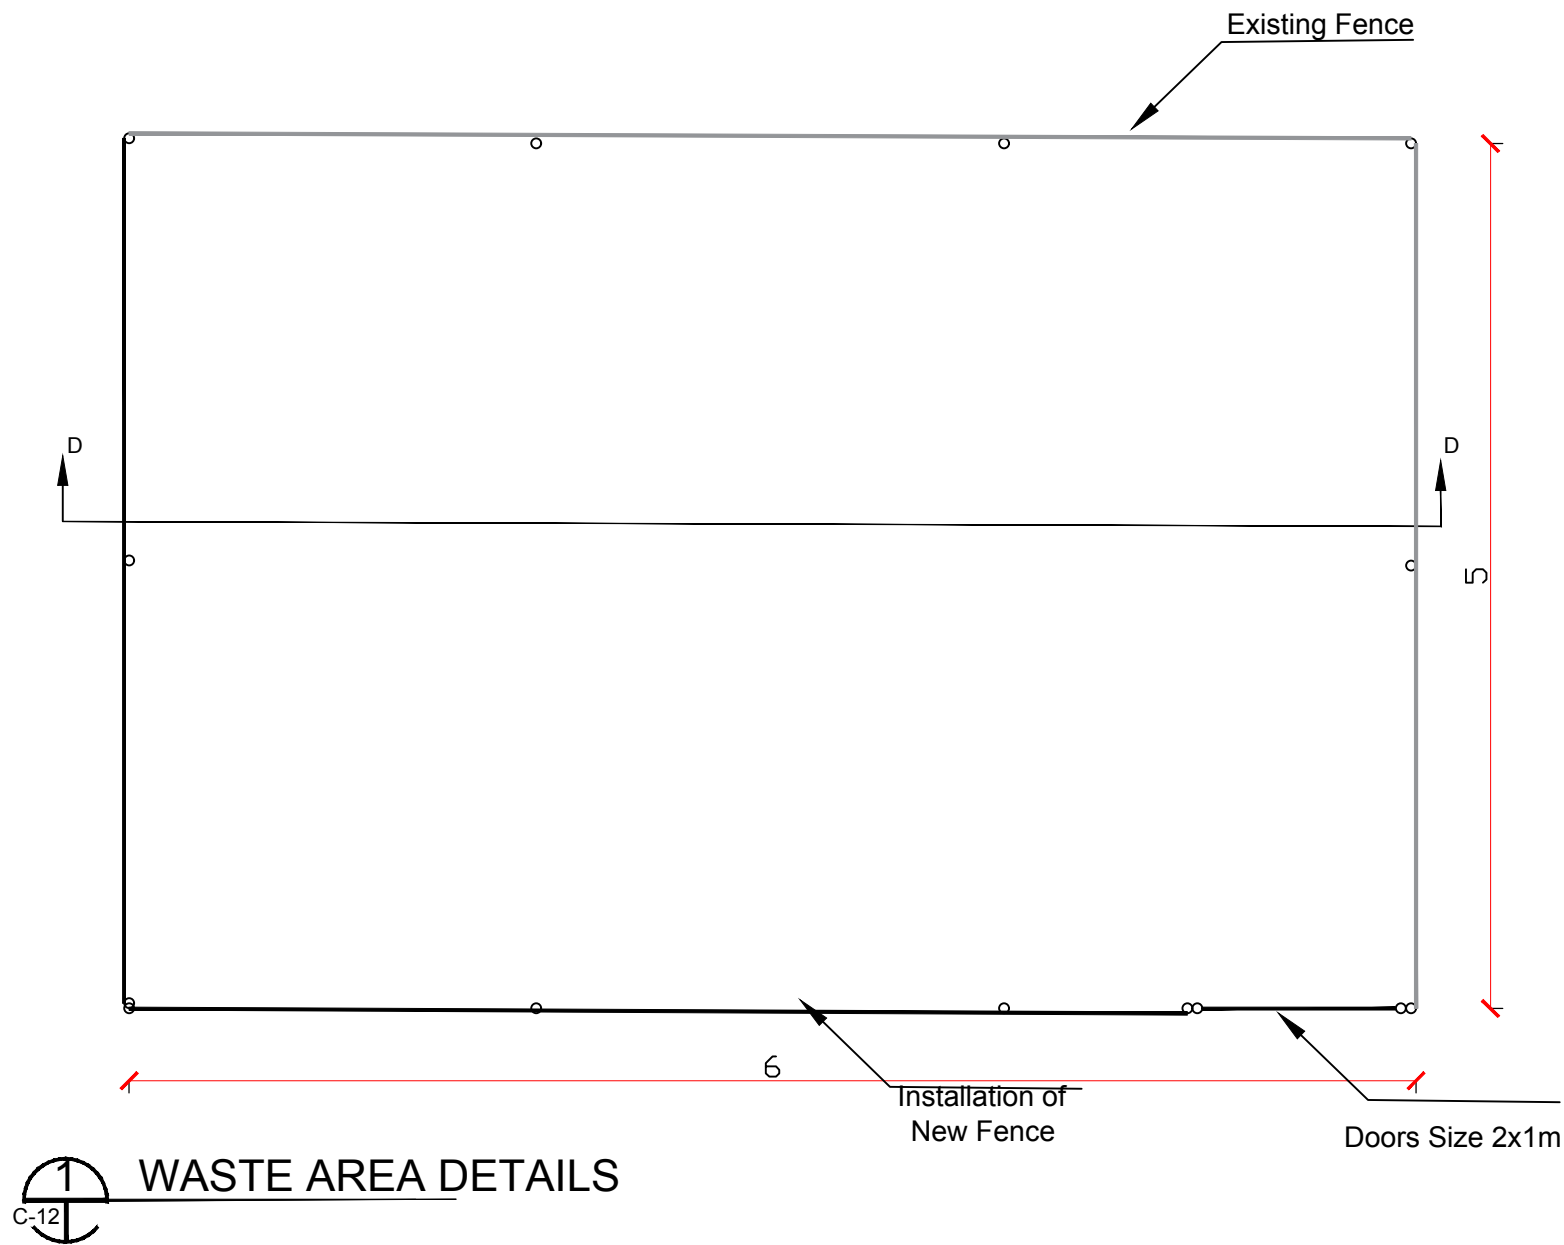

  MEDECINS DU MONDE MDM	SURVEYED BY	MDM ENGINEER	CHECKED BY	MDM TEAM	SCALE		SHEET NO. 	PROVINCE	NIMROZ	PROJECT NAME: MAJOR REHABILITATION OF HEALTH CENTER
	DESIGNED BY	MDM ENGINEER	REVIEWED BY	MDM TEAM	DATE	01-06-2026		DISTRICT	DALARAM	
	DRAWN BY	MDM ENGINEER	APPROVED BY	MDM TEAM	DRAWING NO.			VILLAGE	QALA-E-FATH	DRAWING TITLE: C-12

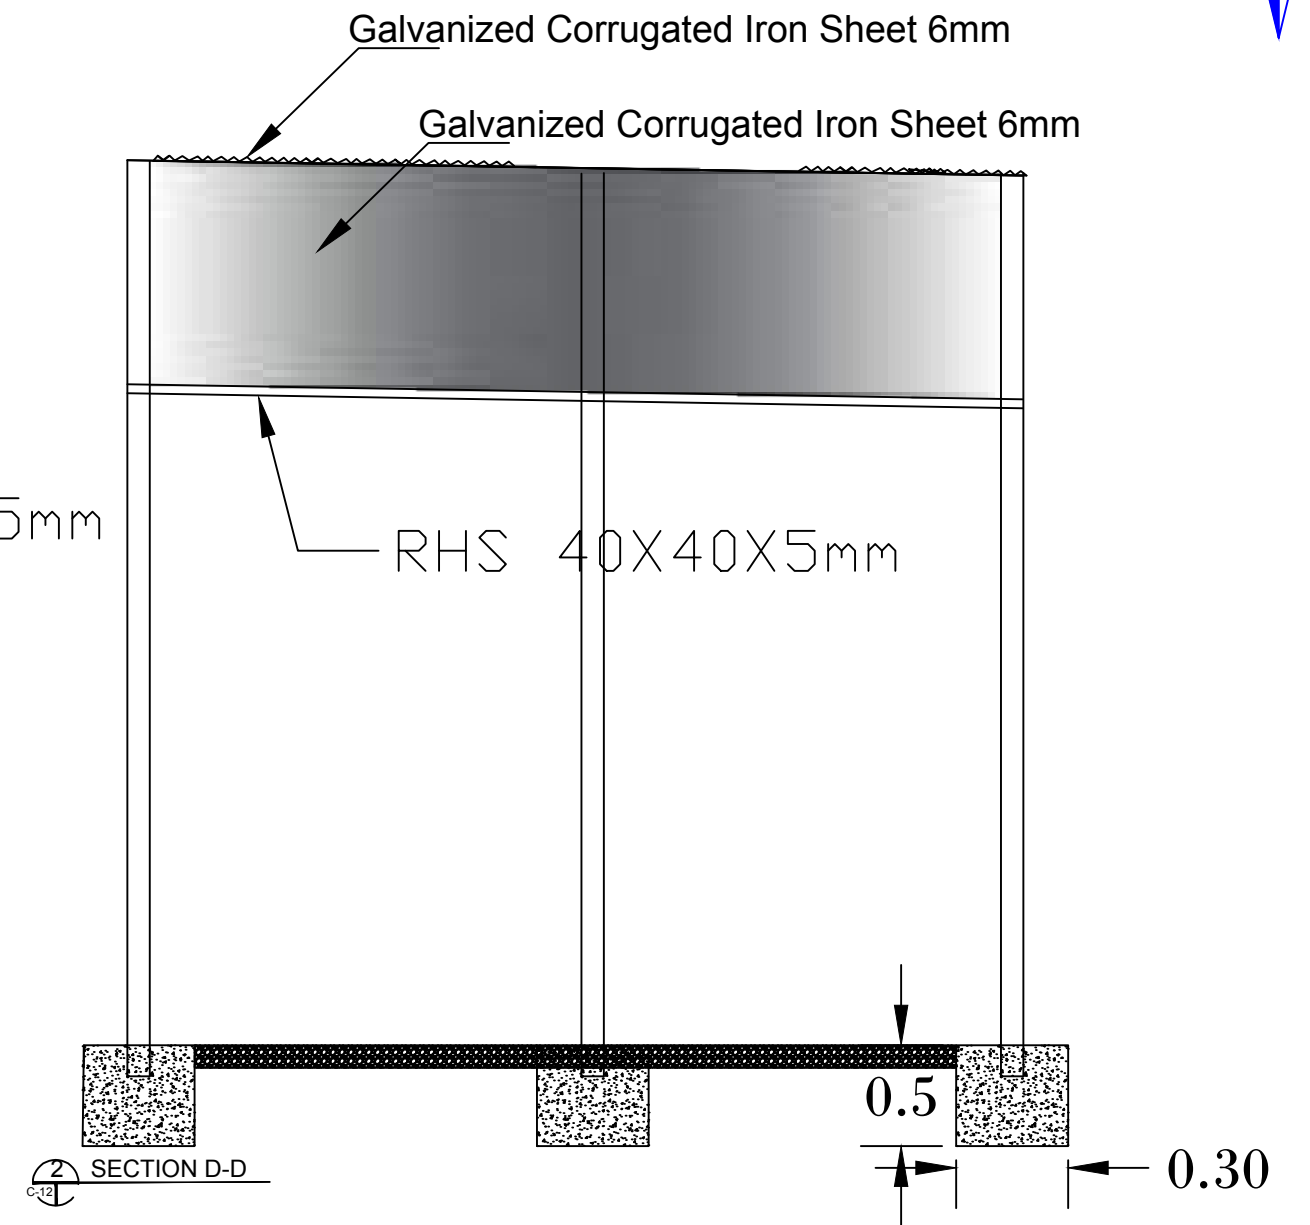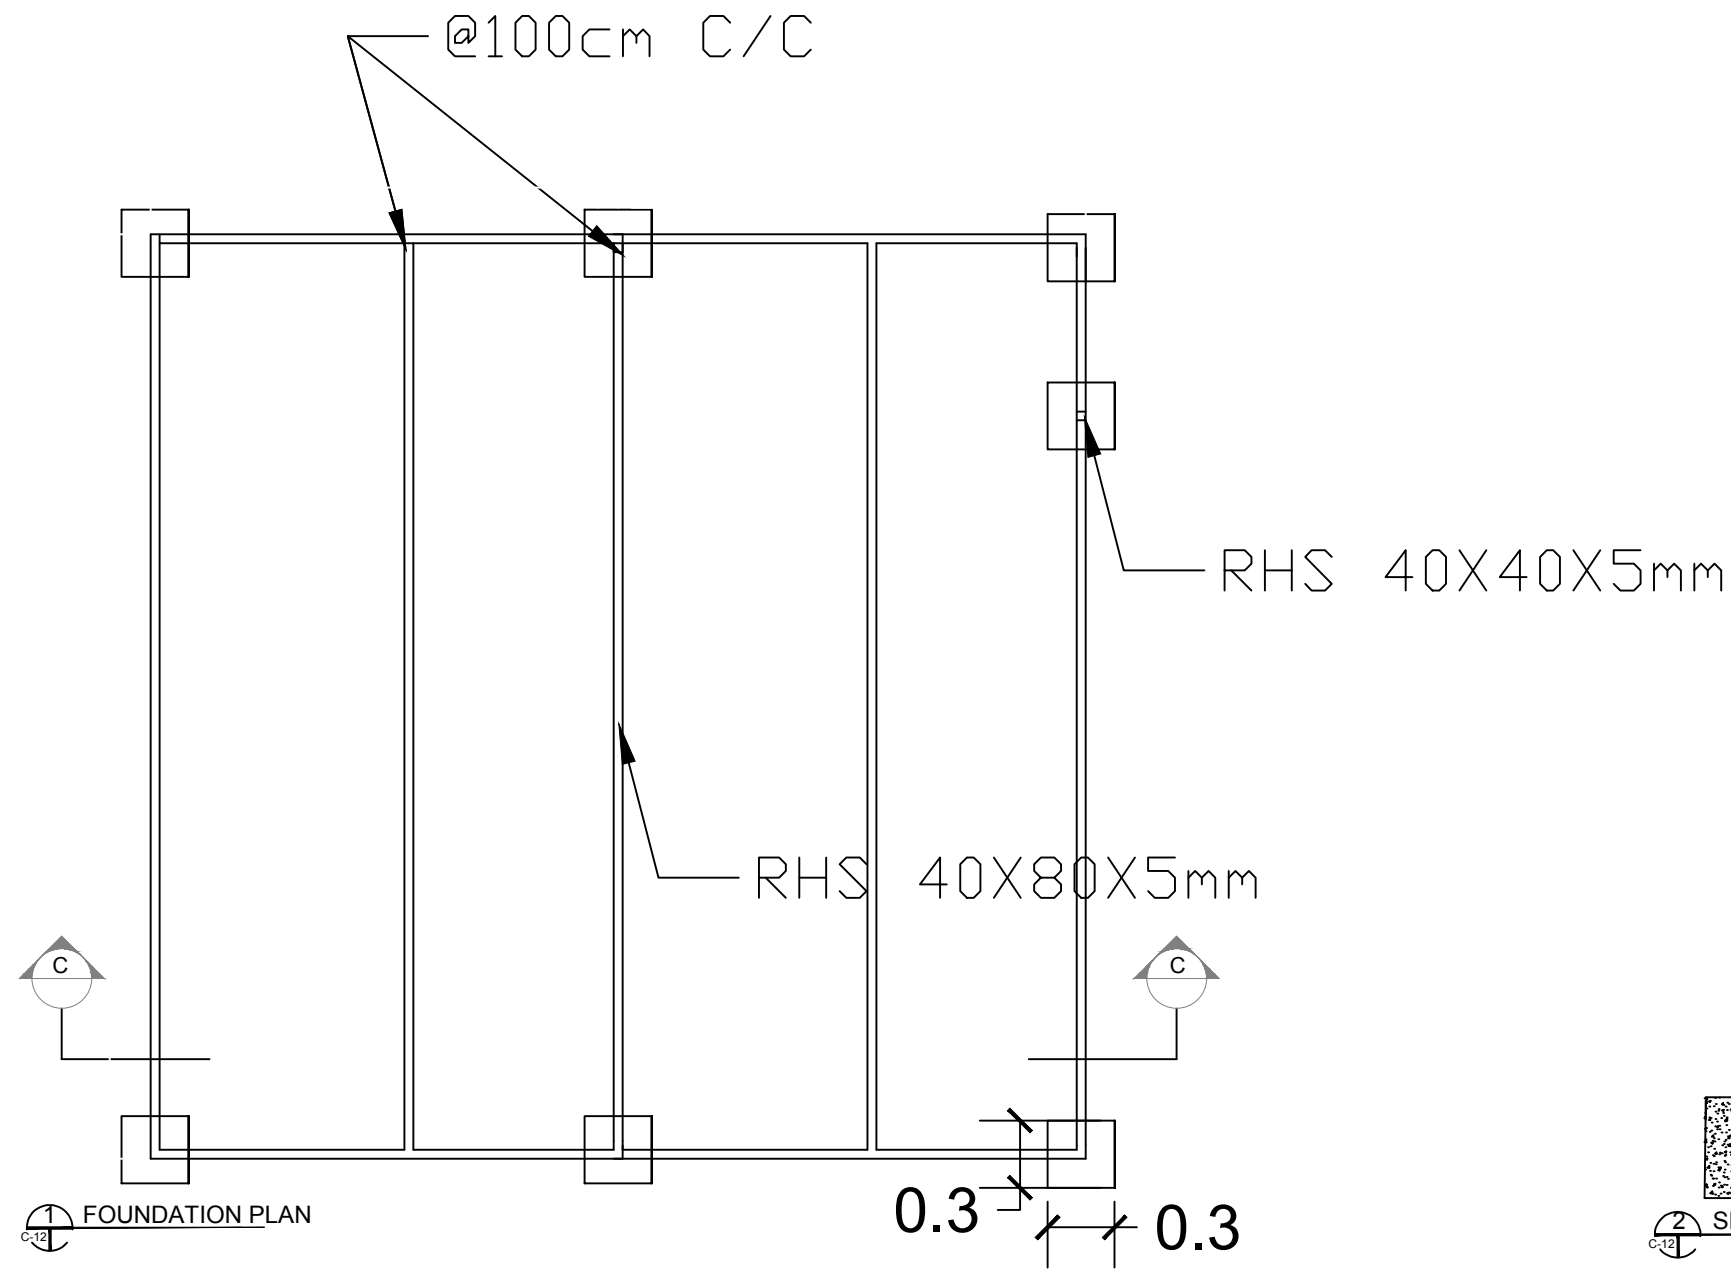

  MEDECINS DU MONDE MDM	SURVEYED BY	MDM ENGINEER	CHECKED BY	MDM TEAM	SCALE		SHEET NO. 	PROVINCE	NIMROZ	PROJECT NAME: MAJOR REHABILITATION OF HEALTH CENTER
	DESIGNED BY	MDM ENGINEER	REVIEWED BY	MDM TEAM	DATE	01-06-2026		DISTRICT	DALARAM	
	DRAWN BY	MDM ENGINEER	APPROVED BY	MDM TEAM	DRAWING NO.			VILLAGE	QALA-E-FATH	DRAWING TITLE: C-13